


CONSTRUCTION PLANS FOR SOUTH RESERVOIR PUMPING FACILITIES & DISCHARGE

WATER DIVISION NO.2 WATER DISTRICT NO.14
PUEBLO COUNTY, COLORADO

PREPARED FOR:

TRIVIEW METROPOLITAN DISTRICT
16055 OLD FOREST PT., SUITE 302
MONUMENT, CO 80132

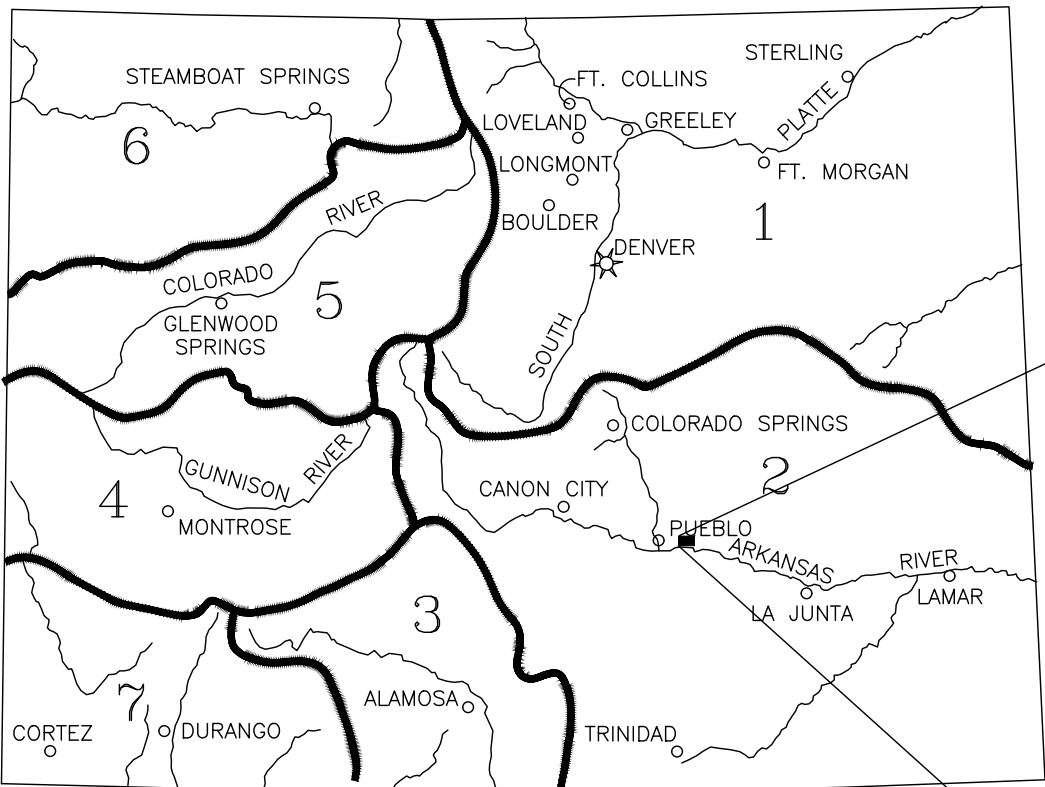

STATE OF COLORADO
PROJECT LOCATION MAP

SCALE: NONE


NOTES:

DEERE AND AULT CONSULTANTS, INC. IS NOT A GUARANTOR OF THE PERFORMANCE OF THE WORK.

DEERE AND AULT CONSULTANTS, INC. IS NOT RESPONSIBLE FOR SAFETY, IN, ON, OR ABOUT THE PROJECT SITE, NOR FOR COMPLIANCE BY THE APPROPRIATE PARTY WITH ANY REGULATIONS RELATED THERETO.

DEERE AND AULT CONSULTANTS, INC. EXERCISES NO CONTROL OVER THE SAFETY OR ADEQUACY OF ANY EQUIPMENT, BUILDING COMPONENTS, FORMS, OR OTHER WORK AIDS USED IN OR ABOUT THE PROJECT, OR OVER THE SUPERINTENDING OF THE SAME.

WRITTEN SCALES ON PLAN ARE FOR FULL SIZED 22" x 34" PLANS AND DO NOT APPLY TO REDUCED PLAN SETS.

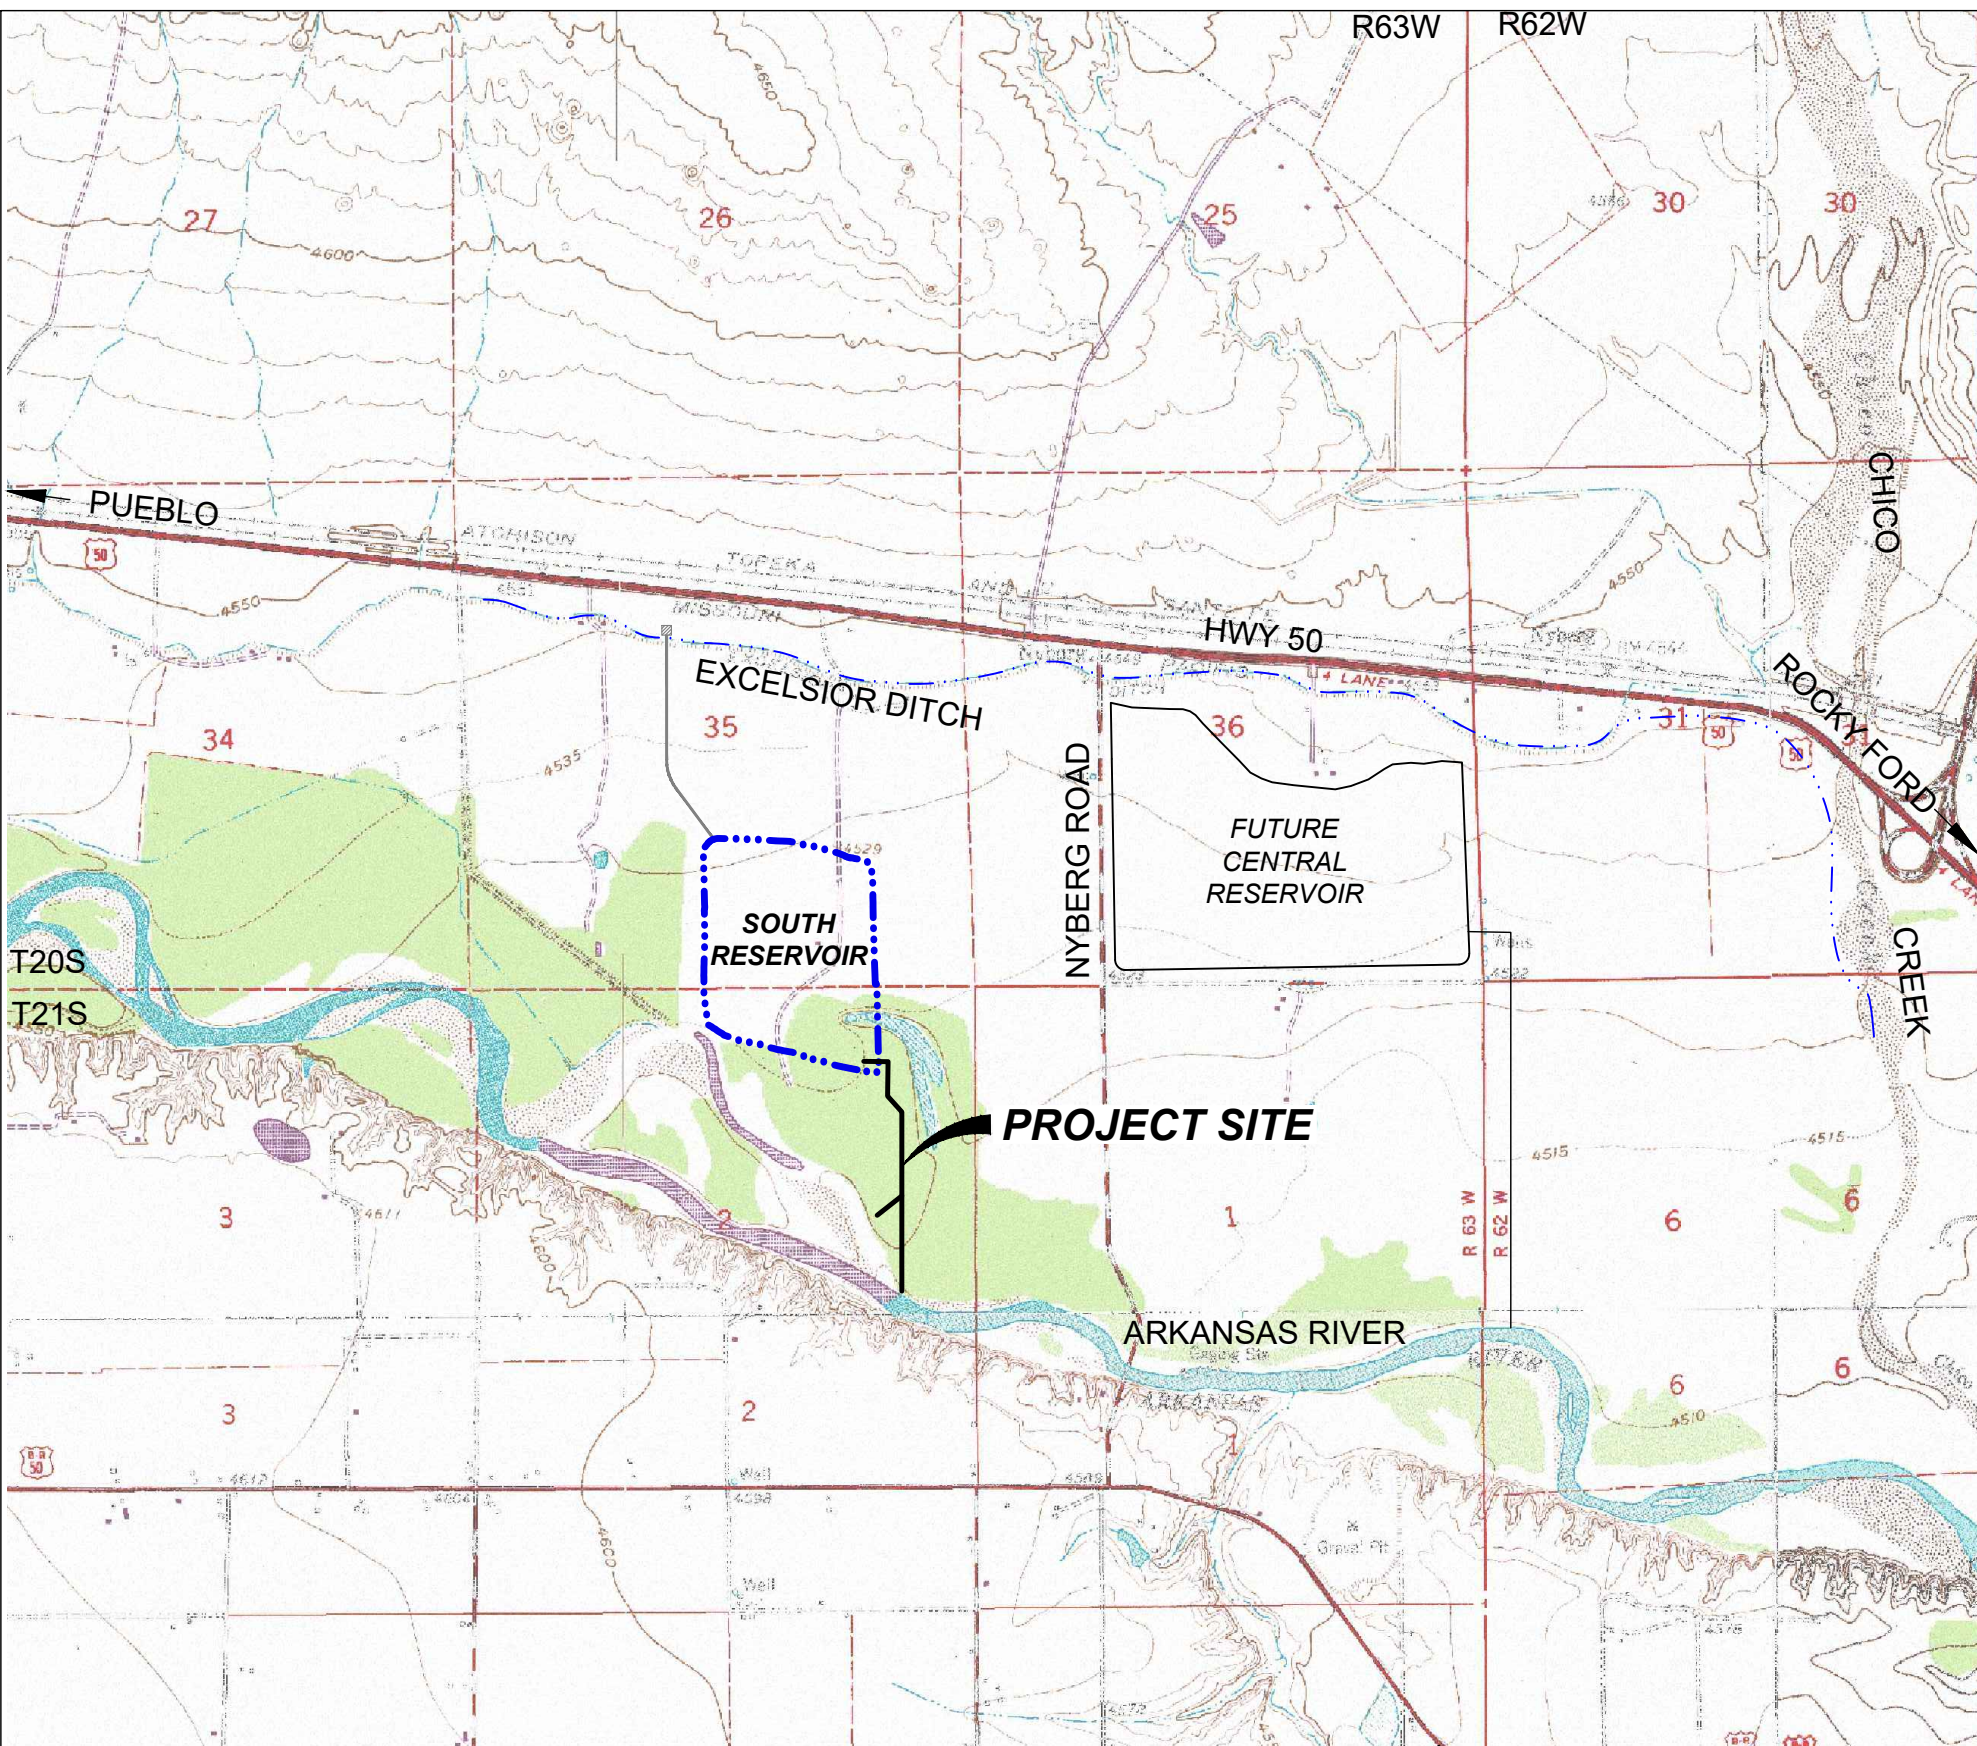

PROJECT VICINITY MAP

0 2000 4000
SCALE IN FEET



CALL 2-BUSINESS DAYS IN ADVANCE BEFORE YOU DIG, GRADE, OR EXCAVATE FOR THE MARKING OF UNDERGROUND MEMBER UTILITIES.

DEERE & AULT CONSULTANTS, INC. ASSUMES NO RESPONSIBILITY FOR EXISTING UTILITY LOCATIONS (HORIZONTAL AND VERTICAL). THE EXISTING UTILITIES SHOWN ON THIS DRAWING HAVE BEEN PLOTTED FROM THE BEST AVAILABLE INFORMATION. IT IS, HOWEVER, THE RESPONSIBILITY OF THE CONTRACTOR TO FIELD VERIFY THE LOCATION OF ALL UTILITIES PRIOR TO THE COMMENCEMENT OF ANY CONSTRUCTION ACTIVITIES.

CERTIFICATION:

I HEREBY CERTIFY THAT THESE PLANS FOR THE CONSTRUCTION OF THE SOUTH RESERVOIR PUMPING FACILITIES AND DISCHARGE WERE PREPARED UNDER MY DIRECT SUPERVISION FOR THE OWNERS THEREOF

BY: Bryan Black 11/12/21
BRYAN BLACK, P.E. DATE:
COLORADO, P.E. #54374

TRIVIEW METROPOLITAN DISTRICT DOES HEREBY ACCEPT AND APPROVE THESE PLANS FOR THE SOUTH RESERVOIR PUMPING FACILITIES AND DISCHARGE.

BY: _____
TRIVIEW METROPOLITAN DISTRICT

SHEET INDEX:

- COVER SHEET
- GENERAL PLAN
- PIPELINE PLAN & PROFILE
- OUTLET WORKS - PIPING
- COLUMN PUMP PLAN & PROFILE
- GRAVITY LINE PLAN & PROFILE
- OUTLET WORKS - DISCHARGE STRUCTURE
- INTAKE STRUCTURE PLAN & SECTION
- FLOW METER VAULT
- COLUMN PUMP STRUCTURE
- PUMP BUILDING DETAILS
- MISCELLANEOUS DETAILS
- ROAD FILL & DITCH PLAN
- PIPE & VALVE SCHEDULE
- E-00 ELECTRICAL COVER SHEET
- E-01 SITE ELECTRICAL PLAN
- E-02 ELECTRICAL DIAGRAMS & DETAILS



SOUTH RESERVOIR PUMPING FACILITIES & DISCHARGE

COVER SHEET

DEERE & AULT
A SCHWABEL ENGINEERING COMPANY
600 S. AIRPORT RD., BLDG. A, SUITE 205
LONGMONT, CO 80503
TEL 303.651.1468 FAX 303.651.1469

DESIGNED BY: BAB APPROVED BY: GGC JOB NO. SHEET:
DRAWN BY: HOG DATE: 4/15/21 20C26014.02 1
CHECKED BY: MAS SCALE: AS NOTED

Friday, November 12, 2021 3:35:02 PM DRAWING: G:\2020\Longmont\20C26014.02 Temporary Outlet - Pump Facility\03_SE_Products\08-CAD\04-CONTRACT_DWG\SS-SPFP Pipeline Profiles.DWG

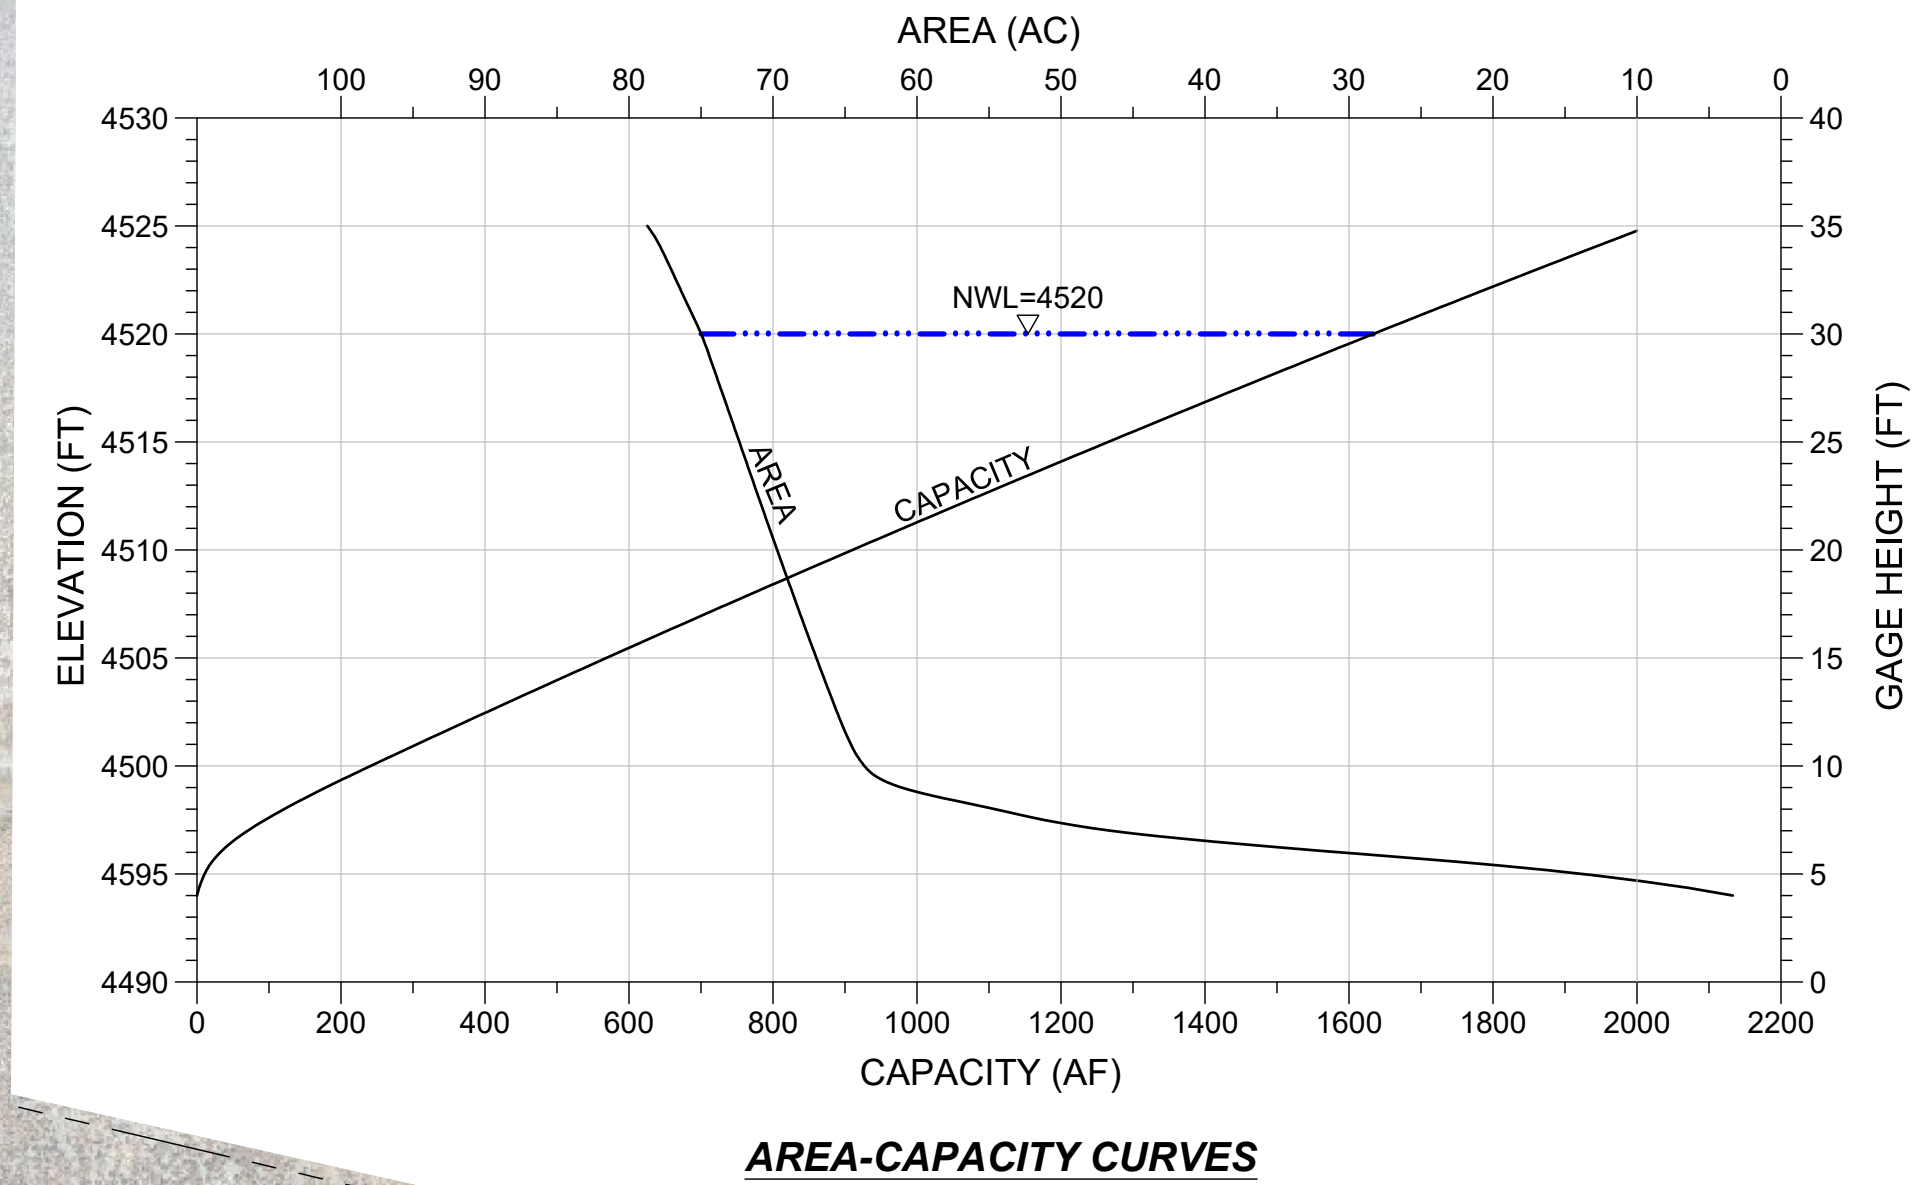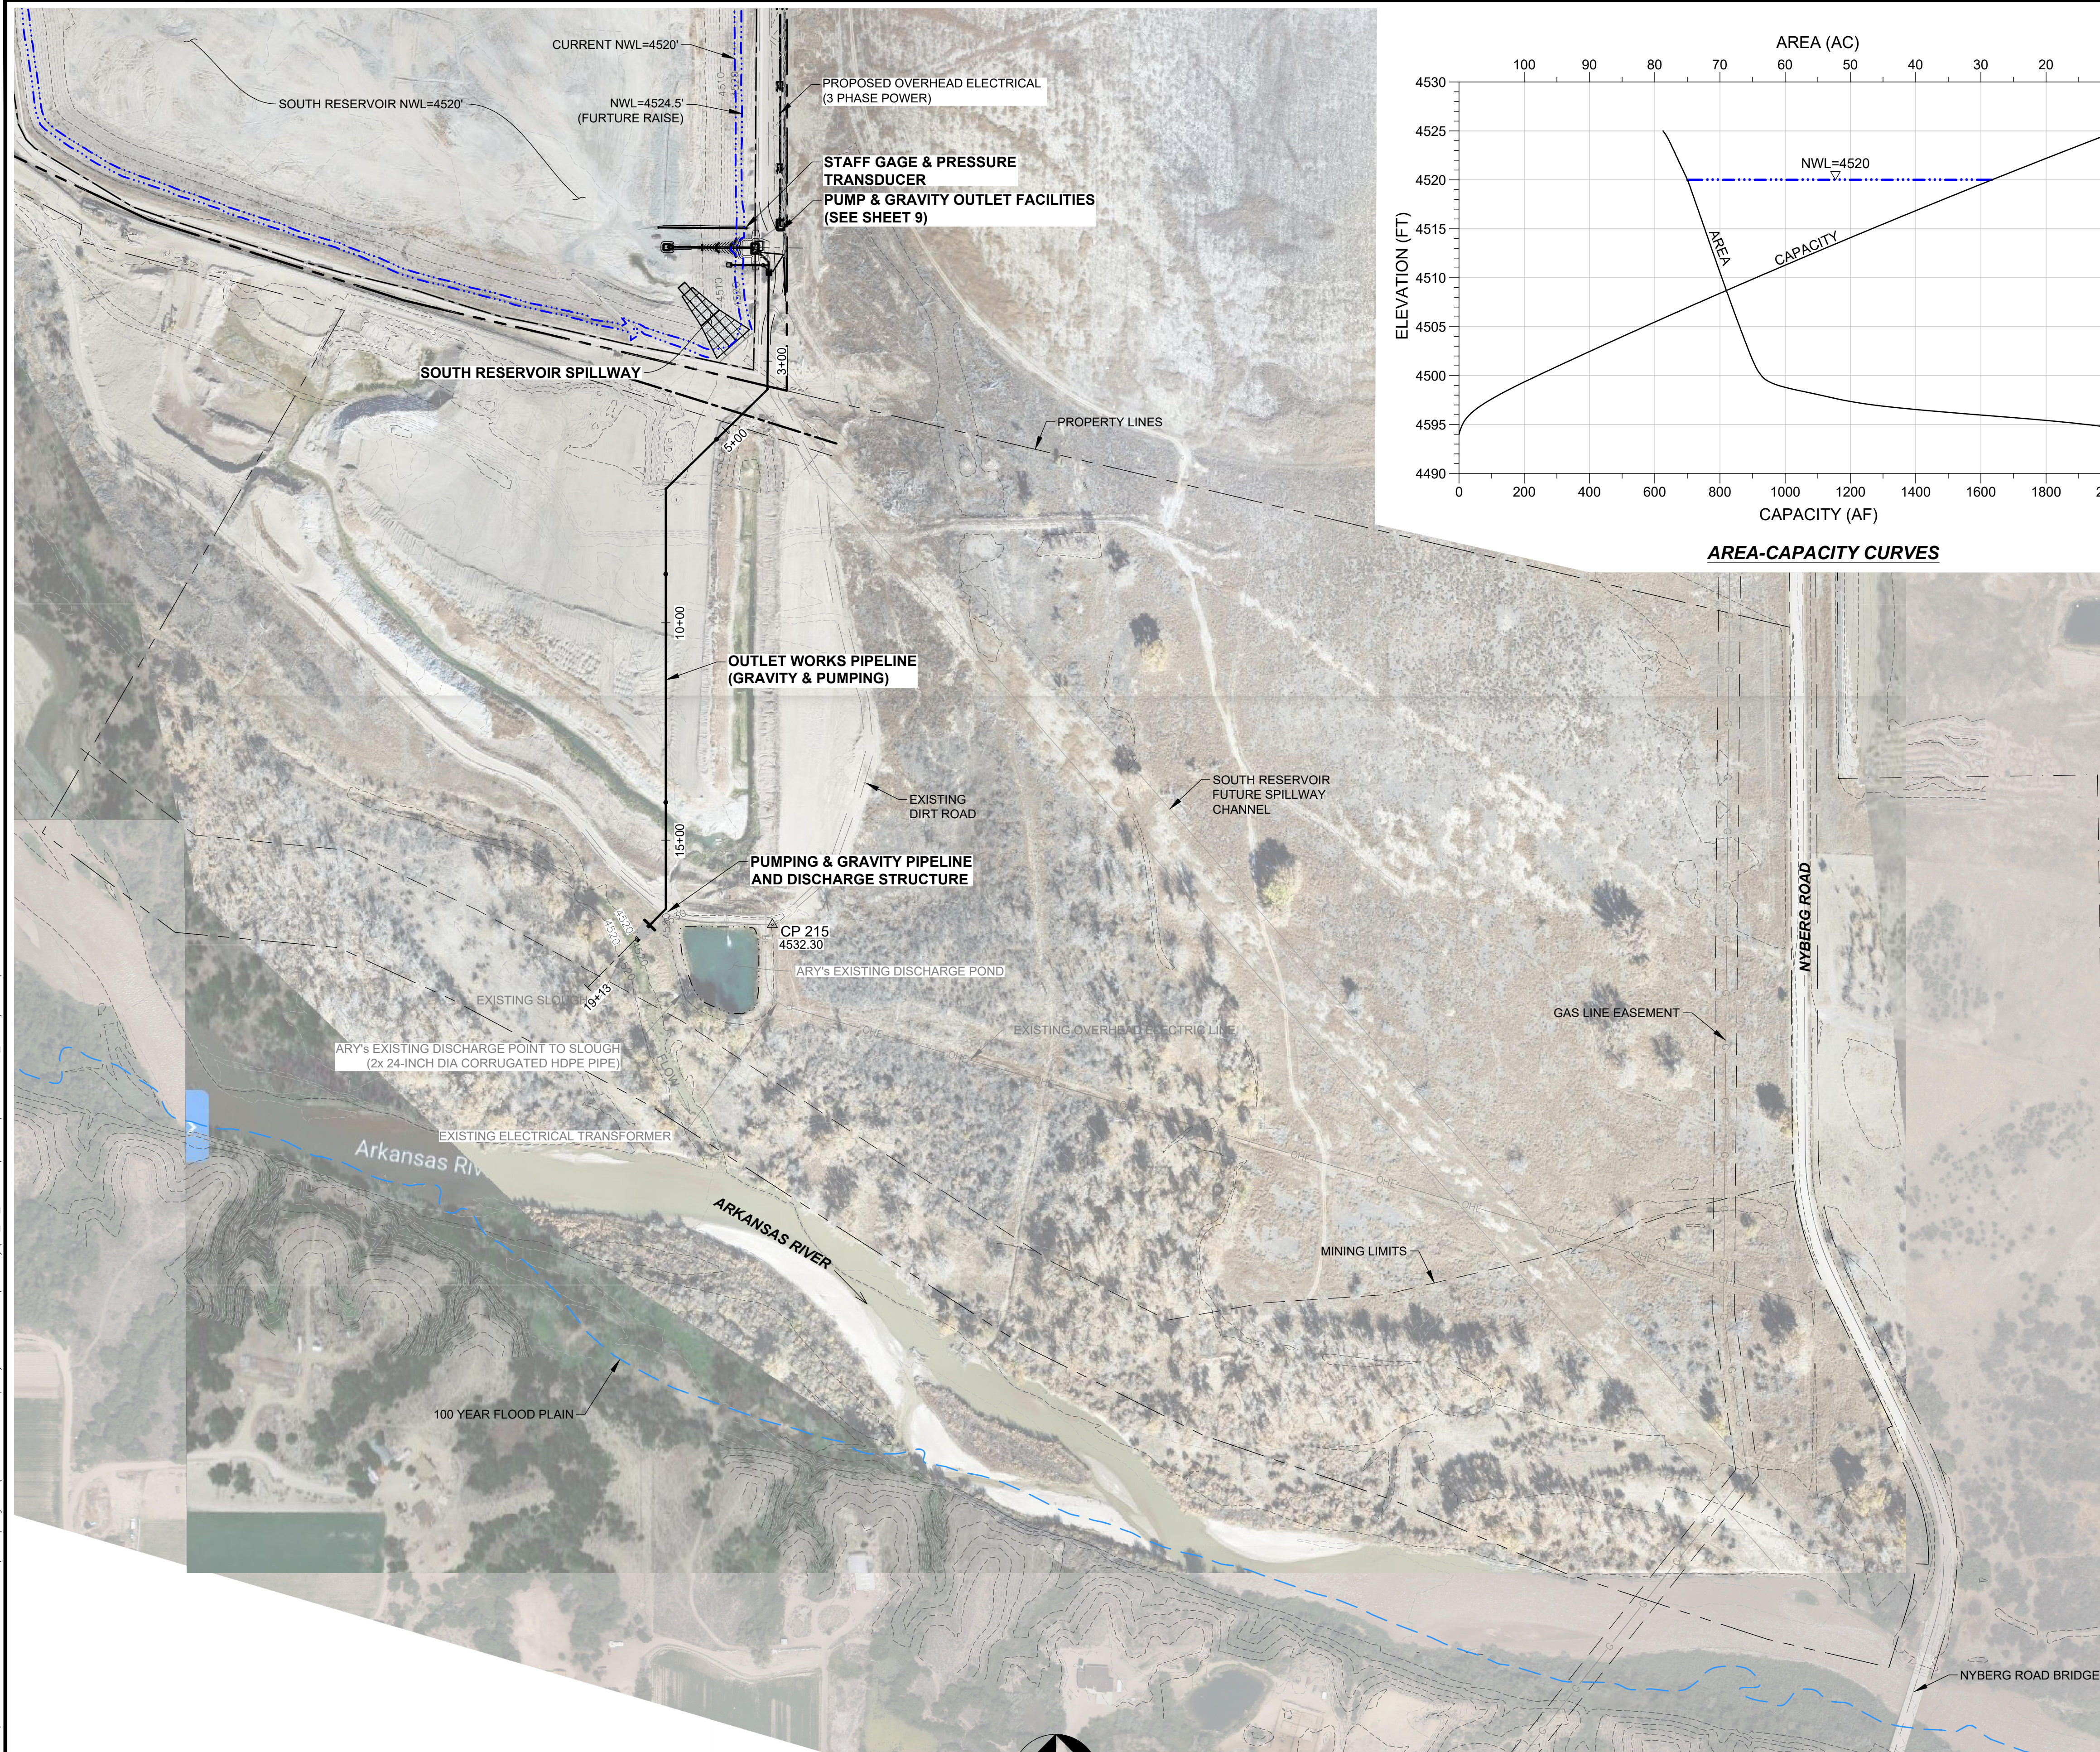

AREA-CAPACITY TABLE				
ELEVATION (FT)	GAGE HEIGHT (FT)	AREA (AC)	CAPACITY (AF)	NOTES
4494	4	3.35	0.00	
4495	5	11.32	7.34	
4496	6	31.09	28.54	
4497	7	48.48	68.33	
4498	8	54.24	119.69	
4499	9	62.11	177.86	
4500	10	63.80	240.82	
4501	11	64.62	305.03	
4502	12	65.27	369.97	
4503	13	65.85	435.53	
4504	14	66.43	501.67	
4505	15	66.99	568.38	
4506	16	67.55	635.65	
4507	17	68.10	703.47	
4508	18	68.64	771.85	
4509	19	69.18	840.76	
4510	20	69.72	910.21	
4511	21	70.25	980.19	
4512	22	70.77	1050.70	
4513	23	71.30	1121.74	
4513.5	23.5	71.56	1157.52	GRAVITY OUTLET WORKS INVERT
4514	24	71.82	1193.29	
4515	25	72.34	1265.37	
4516	26	72.86	1337.98	
4517	27	73.38	1411.10	
4518	28	73.91	1484.74	
4519	29	74.43	1558.91	
4520	30	74.96	1633.60	CURRENT NWL
* 4521	31	75.69	1708.93	
* 4522	32	76.39	1784.97	
* 4523	33	77.08	1861.70	
* 4524	34	77.79	1939.13	
* 4524.5	34.5	78.18	1976.12	FUTURE RAISE NWL
* 4525	35	78.73	2017.35	

* IS FOR FUTURE RAISE AREA CAPACITY

LEGEND:

- PROPOSED CONTOURS
- EXISTING CONTOURS
- EXISTING BEDROCK CONTOURS
- APPROXIMATE PROPERTY LINE
- OVERHEAD ELECTRIC
- ROADS
- DITCHES & RIVERS
- APPROXIMATE FLOODPLAIN LIMITS
- NORMAL HIGH WATER LINE
- SLURRY WALL
- FENCE
- GAS LINE
- GAS LINE EASEMENT

A

NAME OF SECTION

SHEET WHERE SECTION IS SHOWN

1

NAME OF DETAIL

SHEET WHERE SECTION OR DETAIL IS TAKEN

* IF SECTION OR DETAIL IS ON THE SAME PAGE

CONTROL POINT TABLE				
POINT NAME	NORTHING	EASTING	ELEVATION	DESCRIPTION
CP-208	1585202.29	3312068.80	4537.03	NO. 4 REBAR WITH YELLOW PLASTIC CAP
CP-209	1584262.90	3312085.93	4531.19	NO. 4 REBAR WITH YELLOW PLASTIC CAP
CP-211	1583048.45	3312032.86	4535.80	CONTROL POINT
CP-212	1582080.82	3311900.92	4532.91	CONTROL POINT
CP-215	1579972.87	3314295.27	4532.30	CONTROL POINT

NOTES:

- TOPOGRAPHY OF EXCELSIOR DITCH AND SOUTH INLET CHANNEL COMPLETED BY MANGINI & ASSOCIATES, INC. ON 7-31-20 & 9-29-20. SOUTH RESERVOIR TOPOGRAPHY TAKEN FROM 2019 A&S CONSTRUCTION CO. SURVEY.
- AERIAL PHOTO PROVIDED BY TRIVIEW FROM ARY CORP 11-10-21
- HORIZONTAL DATUM=NAD83
VERTICAL DATUM=NAVD 88
- PROPERTY BOUNDARY AND EASEMENTS BASED FROM BOUNDARY SURVEY PREPARED BY MANGINI REEVES, INC. 10-20-06.
- ORIGINAL PROPERTY BOUNDARY (STONEWALL SPRINGS, LLC) LEGAL DESCRIPTION DESCRIBED IN BOOK 2933, PAGES 644 AND 645, CASE NUMBER 96-09-197, FILE NO. 5022. PUEBLO COUNTY CLERK AND RECORDER.
- SLURRY WALL LOCATION TAKEN FROM SOUTH RESERVOIR SURVEY PROVIDED BY HALL-IRWIN CONSTRUCTION, 2019.
- FEMA FLOODPLAIN LIMIT FOR ARKANSAS RIVER TAKEN FROM FEMA FLOOD INSURANCE RATE MAP (FIRM) NO. 08101C0550D 8-15-19.

SEO CONSTRUCTION FILE NO. 20C26014.02

SOUTH RESERVOIR PUMPING FACILITIES & DISCHARGE

REVISIONS

NO.	DESCRIPTION	DATE	BY
1	DRAFT	4-16-21	BAB
2	FOR BID	11-12-21	BAB

GENERAL PLAN

DEERE & AULT

A SCHWASEL ENGINEERING COMPANY

DESIGNED BY: BAB APPROVED BY: GGC


DRAWN BY: HOG DATE: 4/15/21

CHECKED BY: MAS SCALE: AS NOTED

600 S. AIRPORT RD., BLDG. A, SUITE 205
LONGMONT, CO 80503
TEL 303.651.1468 FAX 303.651.1469


JOB NO. 20C26014.02


SHEET: 2

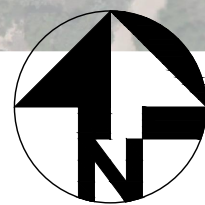


0 200 400
SCALE IN FEET
EXISTING CONTOUR INTERNAL = 2'

Friday, November 12, 2021 3:33:12 PM DRAWING: G:\2020\Longmont\20C26014.02 Temporary Outlet - Pump Facility\03_SE_Products\08-CAD\04-CONTRACT-DWG\SSPFE Pipeline Profiles.DWG


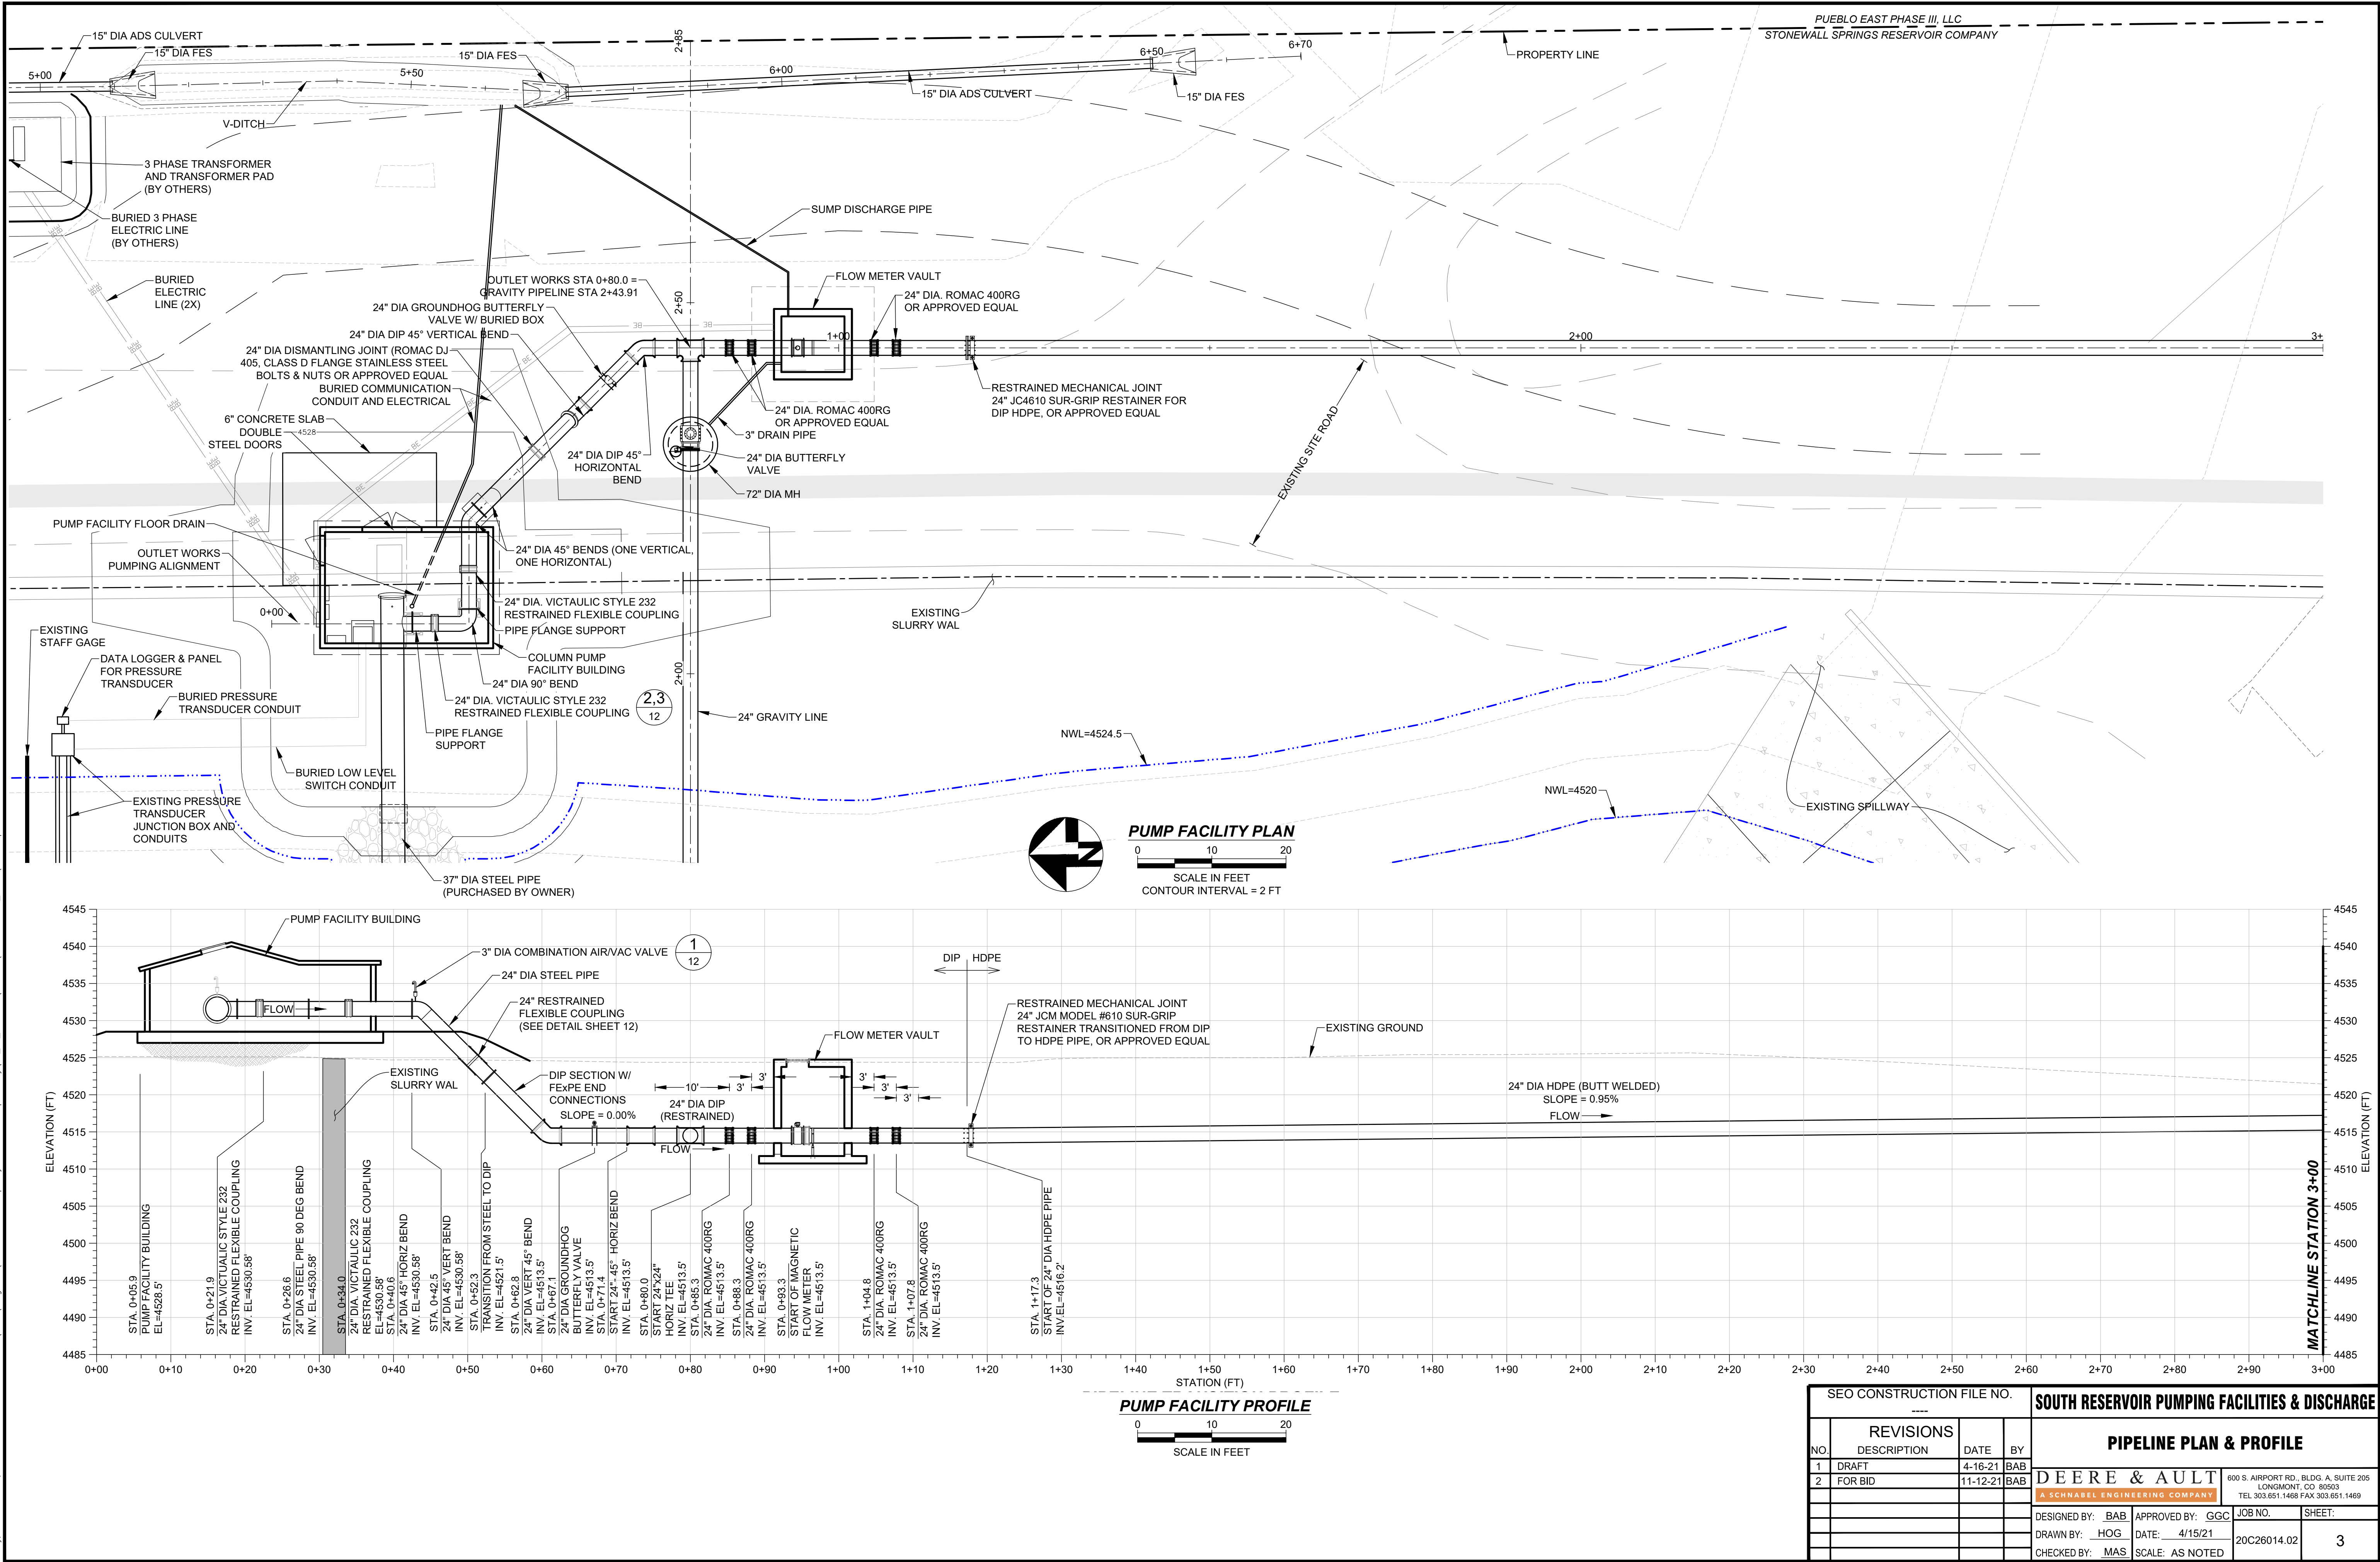


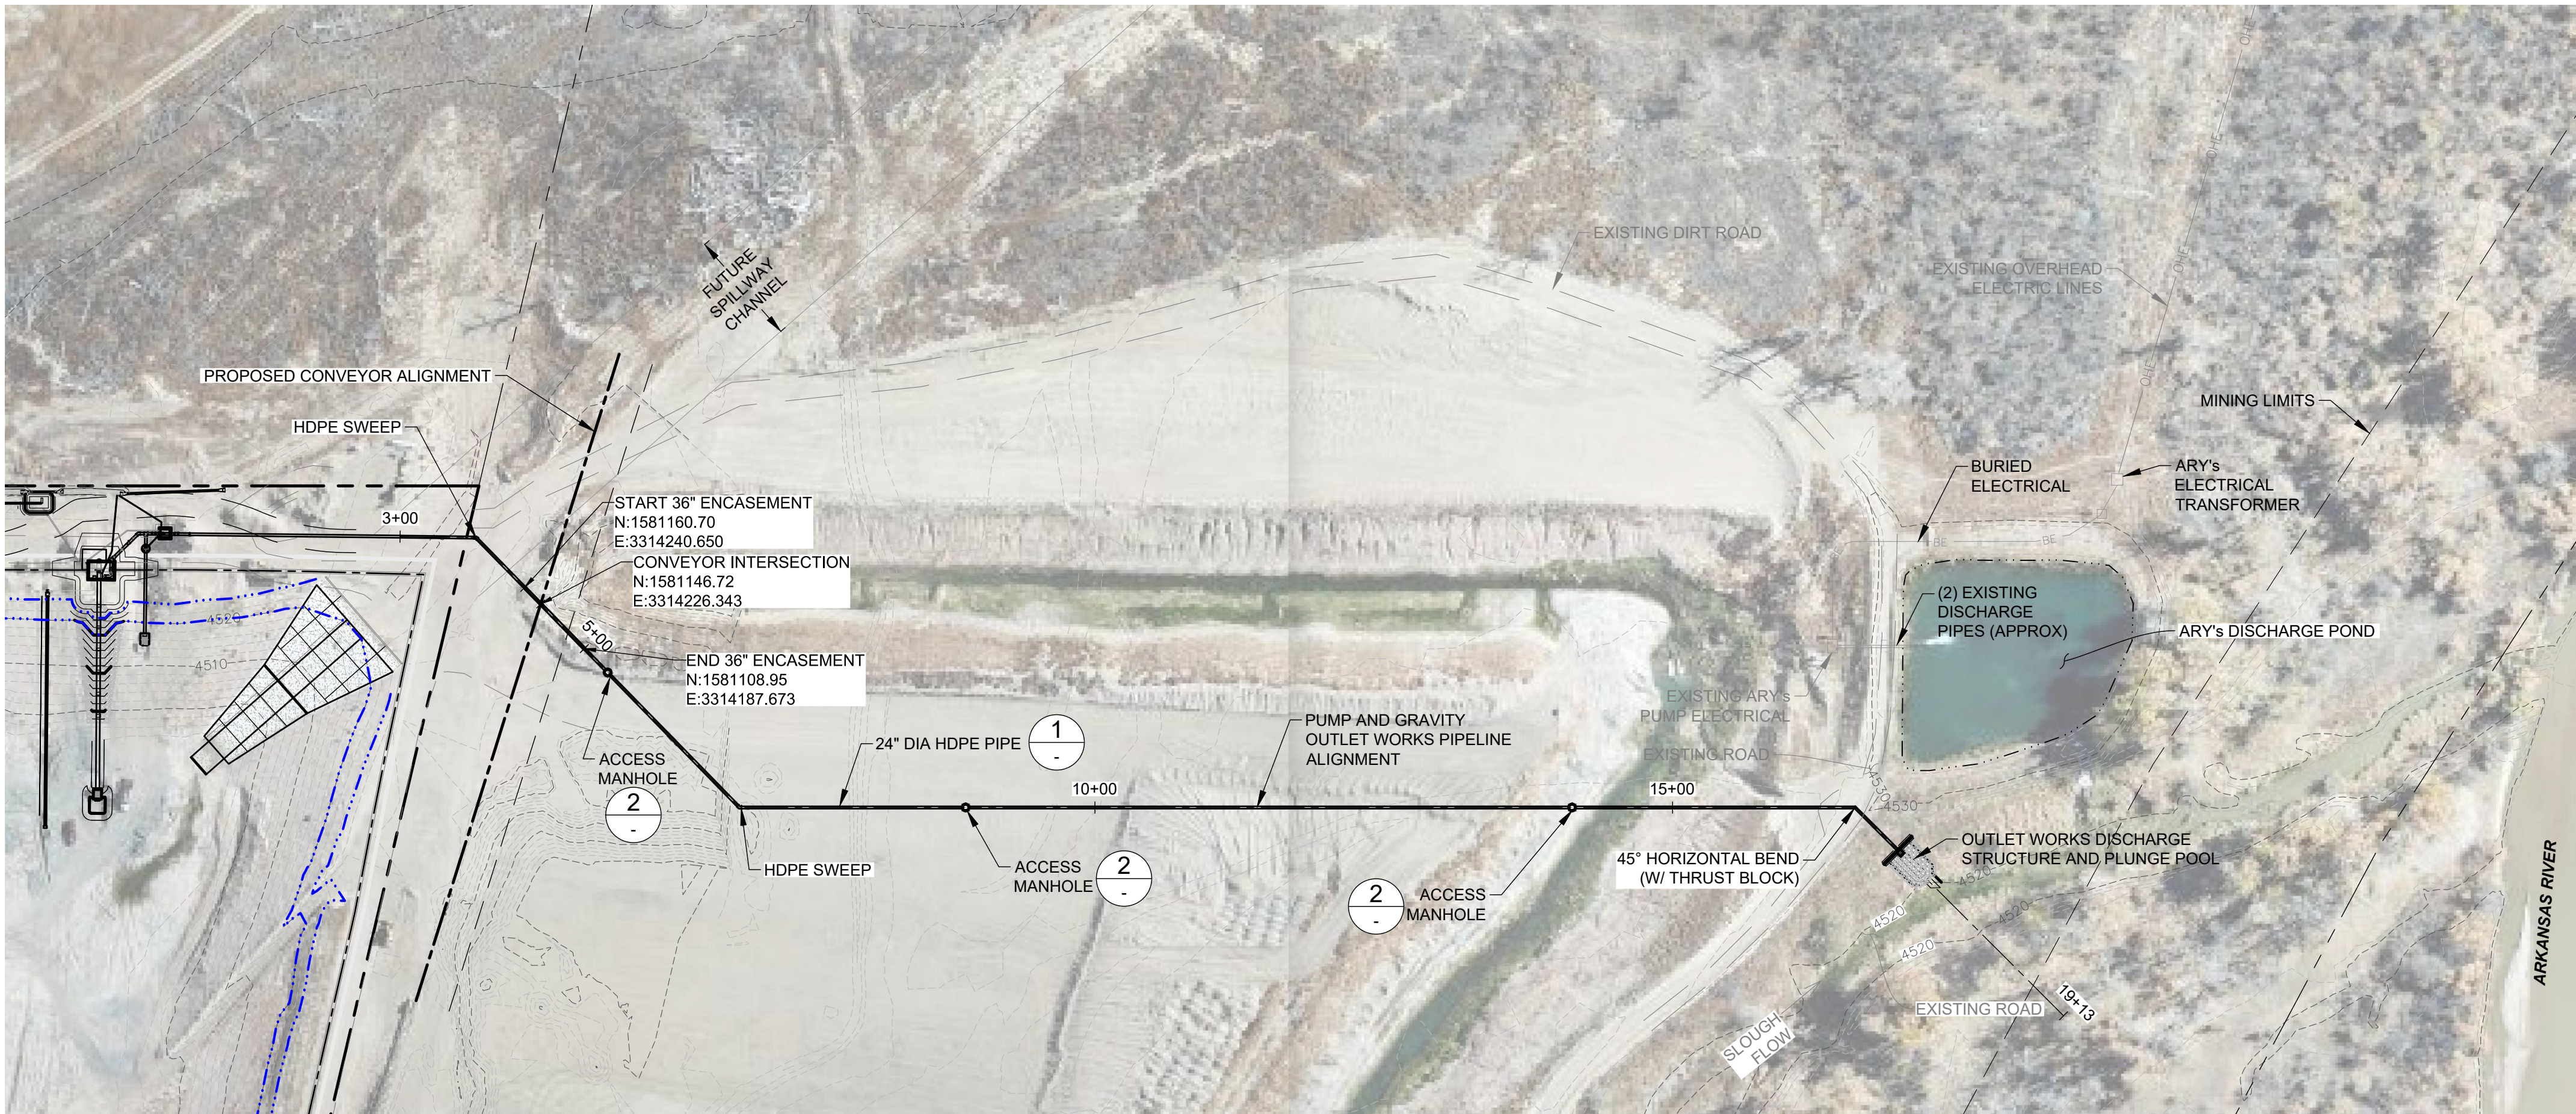




NOTE:
AERIAL PHOTO PROVIDED BY TRIVIEW FROM ARY CORP 11-10-21

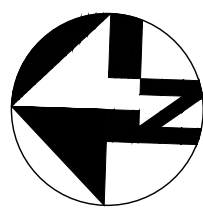


OUTLET WORKS PIPING PLAN

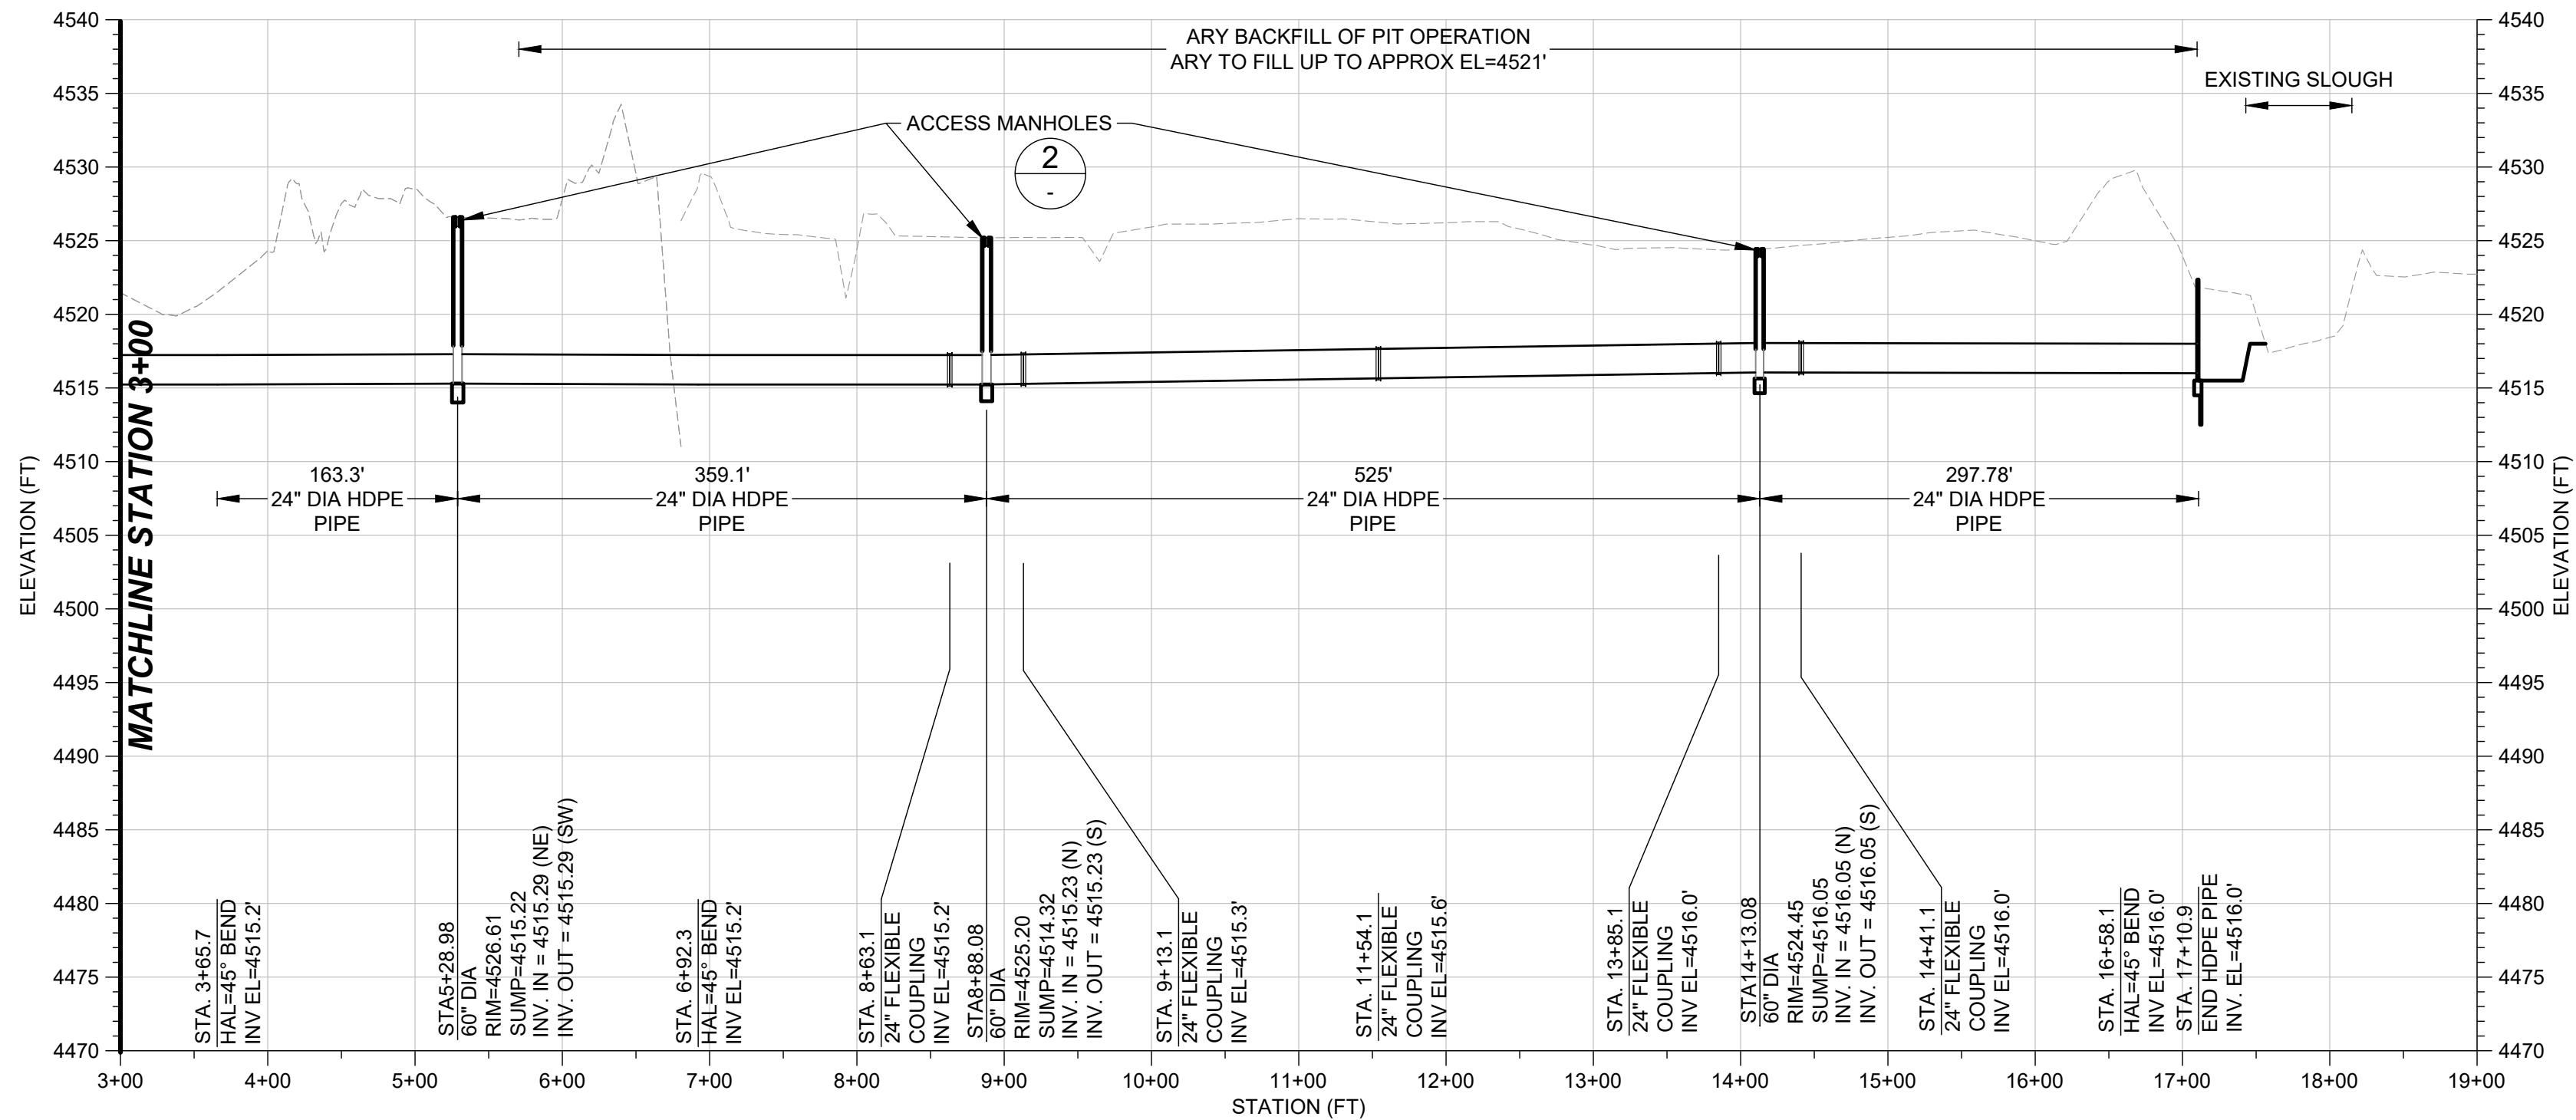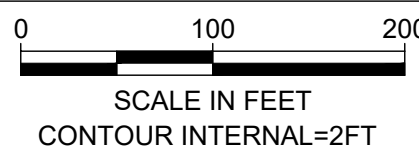

OUTLET WORKS PIPING PROFILE

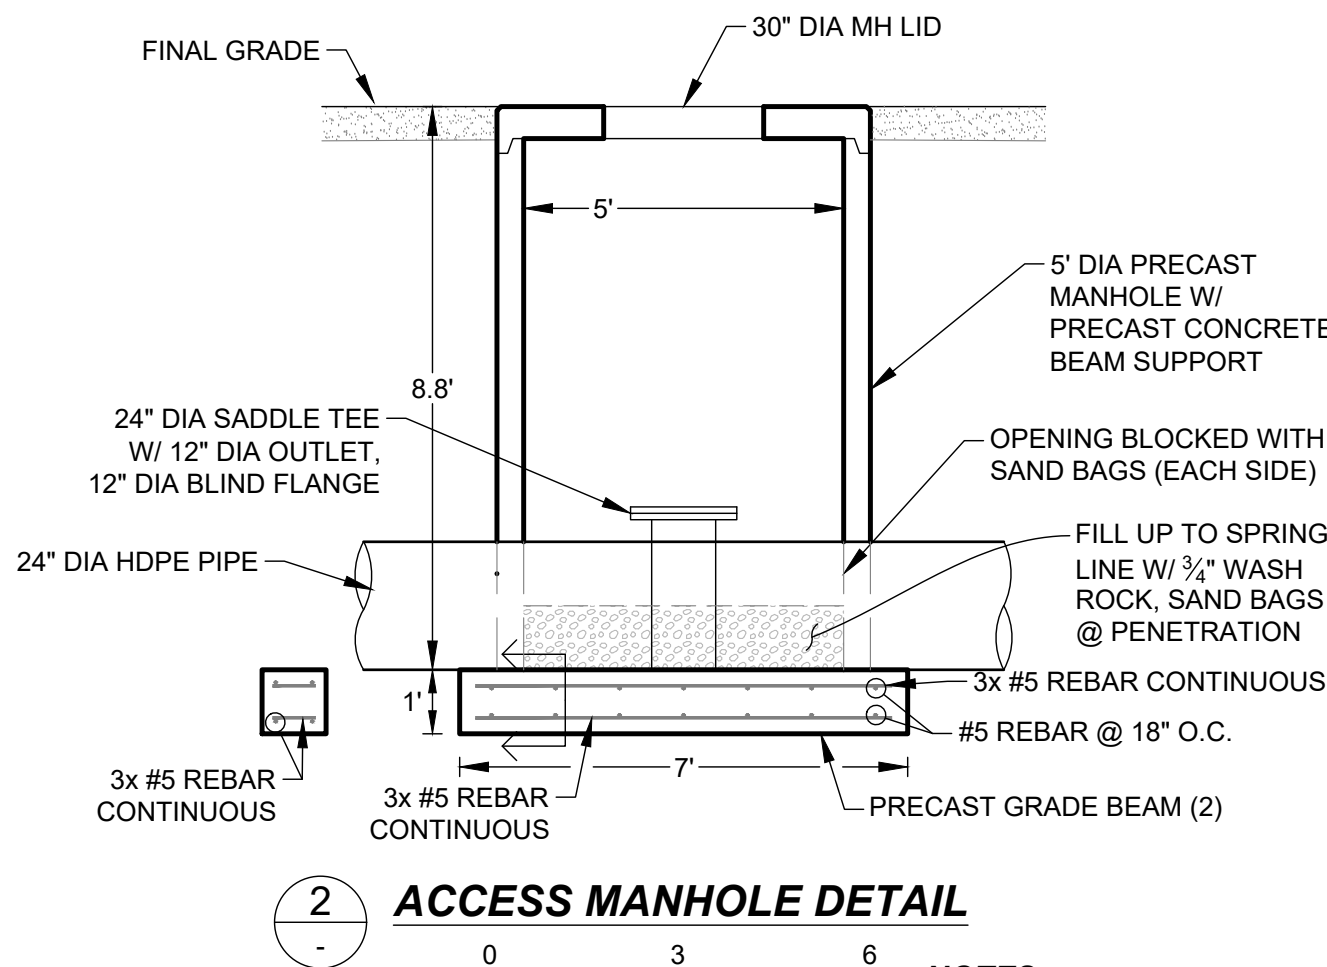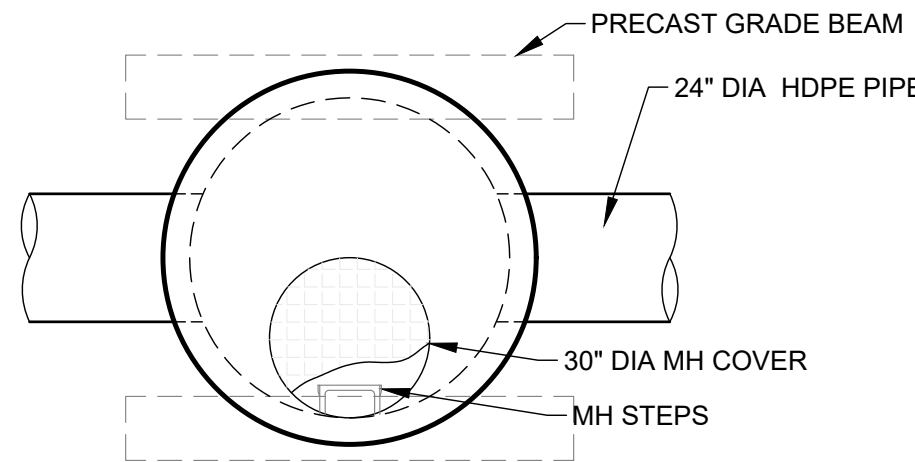 


NOTES:
1. MANHOLES SHALL BE RATED FOR H2O LOADING

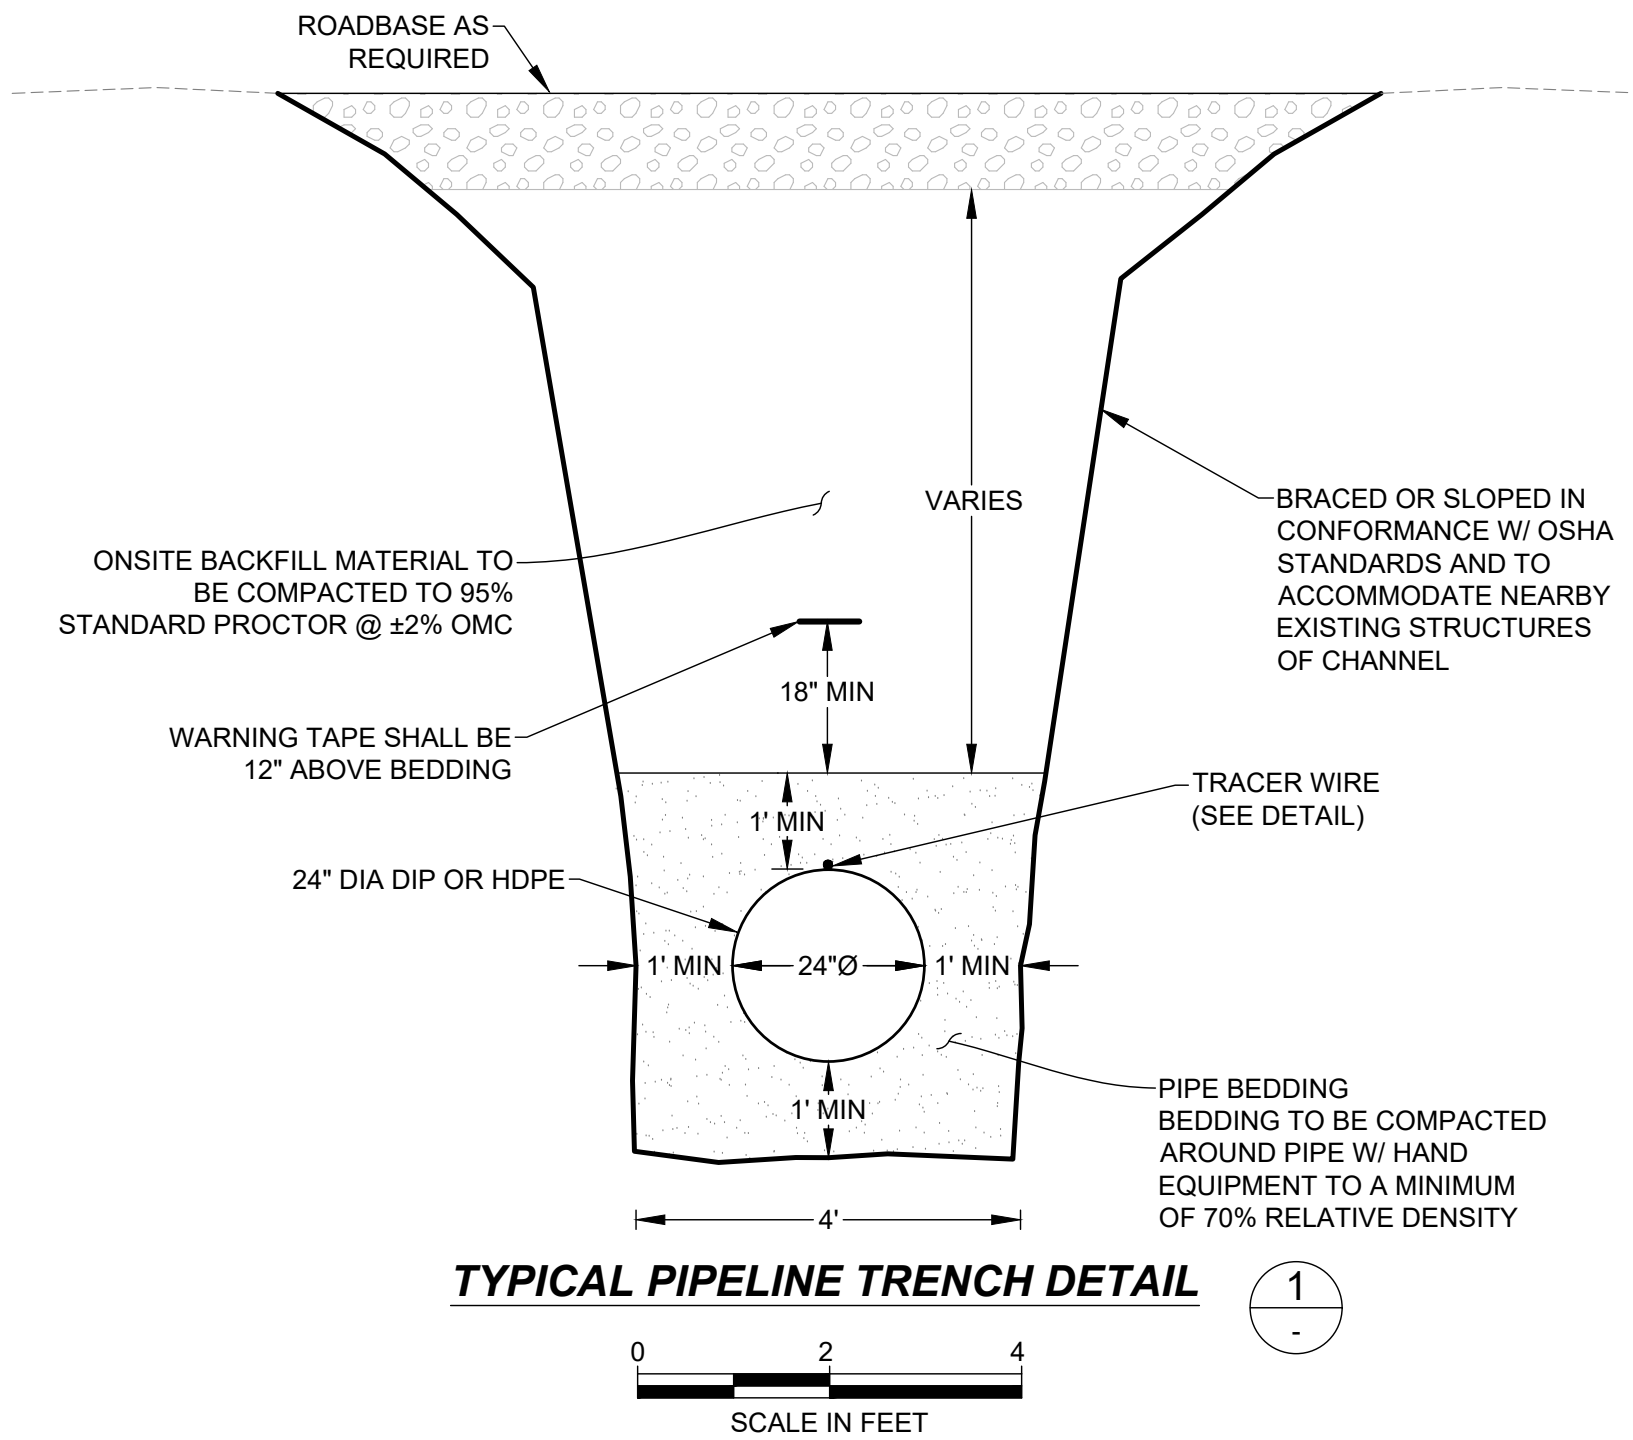


SEO CONSTRUCTION FILE NO.				SOUTH RESERVOIR PUMPING FACILITIES & DISCHARGE			

REVISIONS				OUTLET WORKS - PIPING			
NO.	DESCRIPTION	DATE	BY				
1	DRAFT	4-16-21	BAB				
2	FOR BID	11-12-21	BAB				

Friday, November 12, 2021 3:35:59 PM DRAWING: G:\2020\Longmont\20C26014.02 Temporary Outlet - Pump Facility\03_SE_Products\08-CAD\04-CONTRACT_DWG\SSPFE Pipeline Profiles.DWG

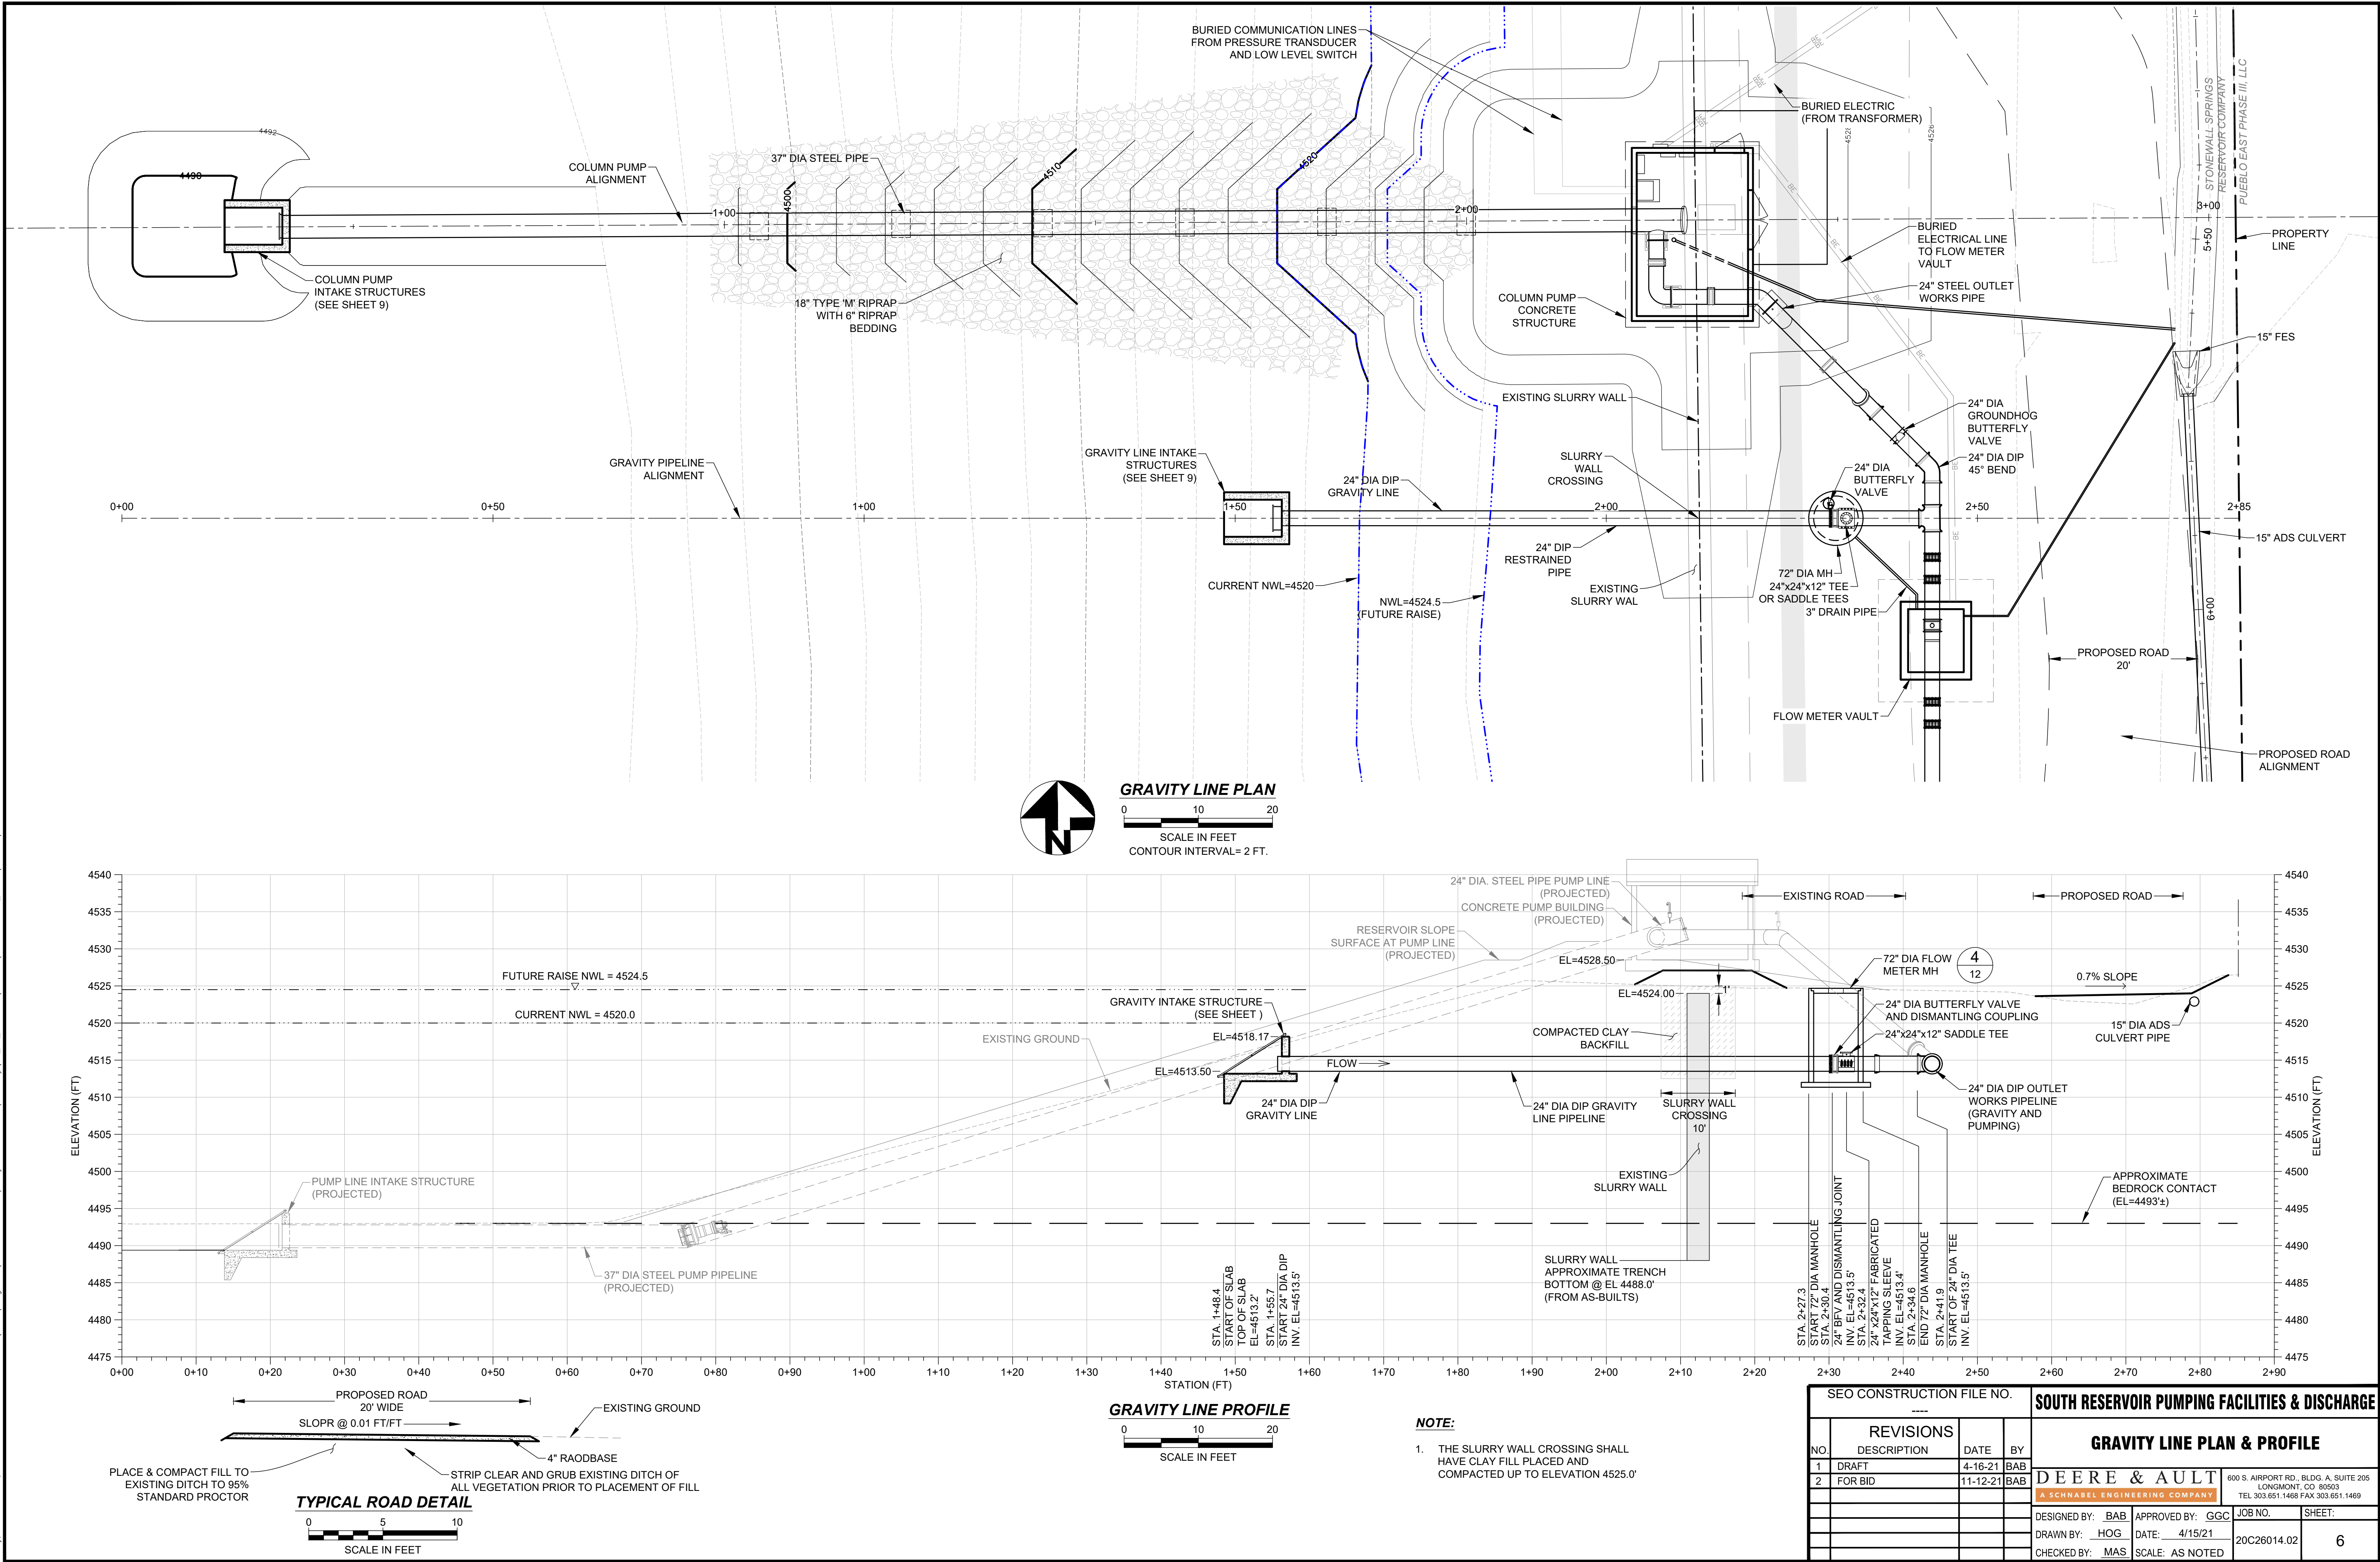

GRAVITY LINE PROFILE




 


NOTE:



1. THE SLURRY WALL CROSSING SHALL HAVE CLAY FILL PLACED AND COMPACTED UP TO ELEVATION 4525.0'

SEO CONSTRUCTION FILE NO.				SOUTH RESERVOIR PUMPING FACILITIES & DISCHARGE			
REVISIONS				GRAVITY LINE PLAN & PROFILE			
NO.	DESCRIPTION	DATE	BY	DEERE & AULT			
1	DRAFT	4-16-21	BAB	A SCHWABER ENGINEERING COMPANY			
2	FOR BID	11-12-21	BAB	DESIGNED BY: BAB APPROVED BY: GGC			
				DRAWN BY: HOG DATE: 4/15/21			
				CHECKED BY: MAS SCALE: AS NOTED			
				JOB NO. 20C26014.02			
				SHEET: 6			




Friday, November 12, 2021 3:34:12 PM DRAWING: G:\2020\Longmont\20C26014.02 Temporary Outlet - Pump Facility\03_SE_Products\08-CAD\04-CONTRACT_DWG\SSPP Pipeline Profiles.DWG

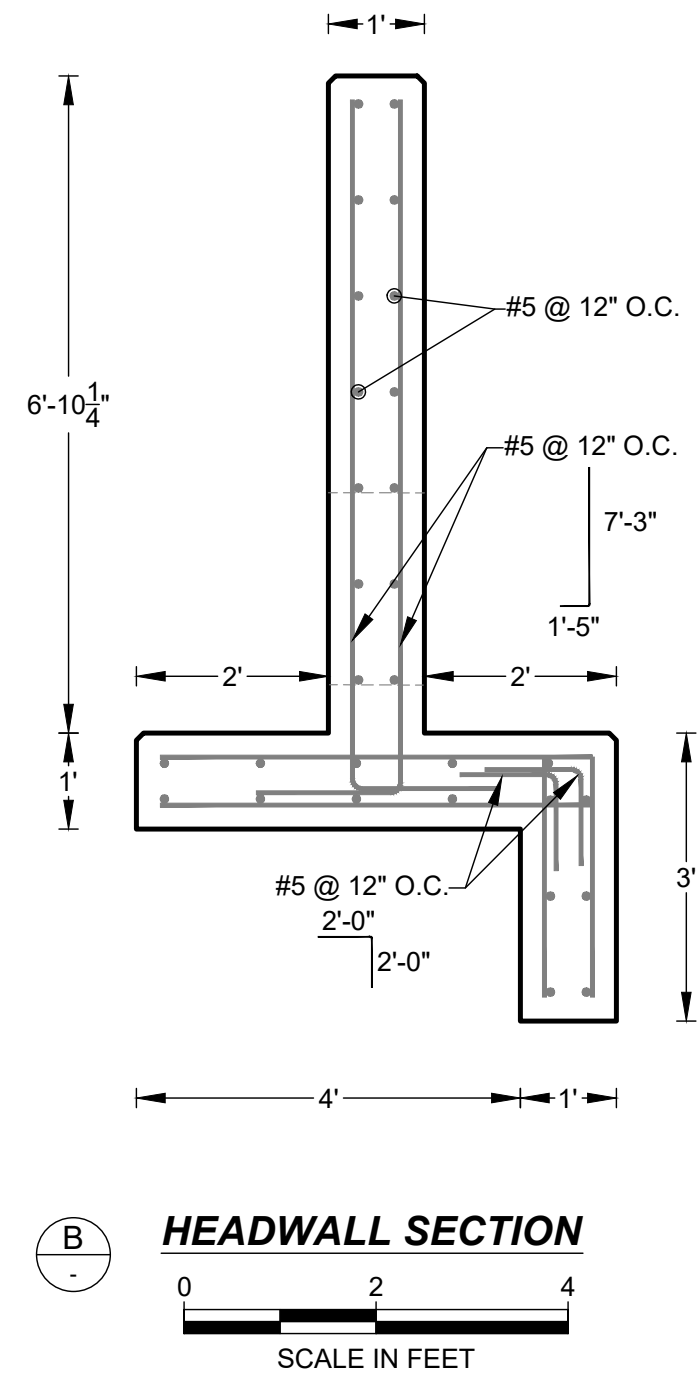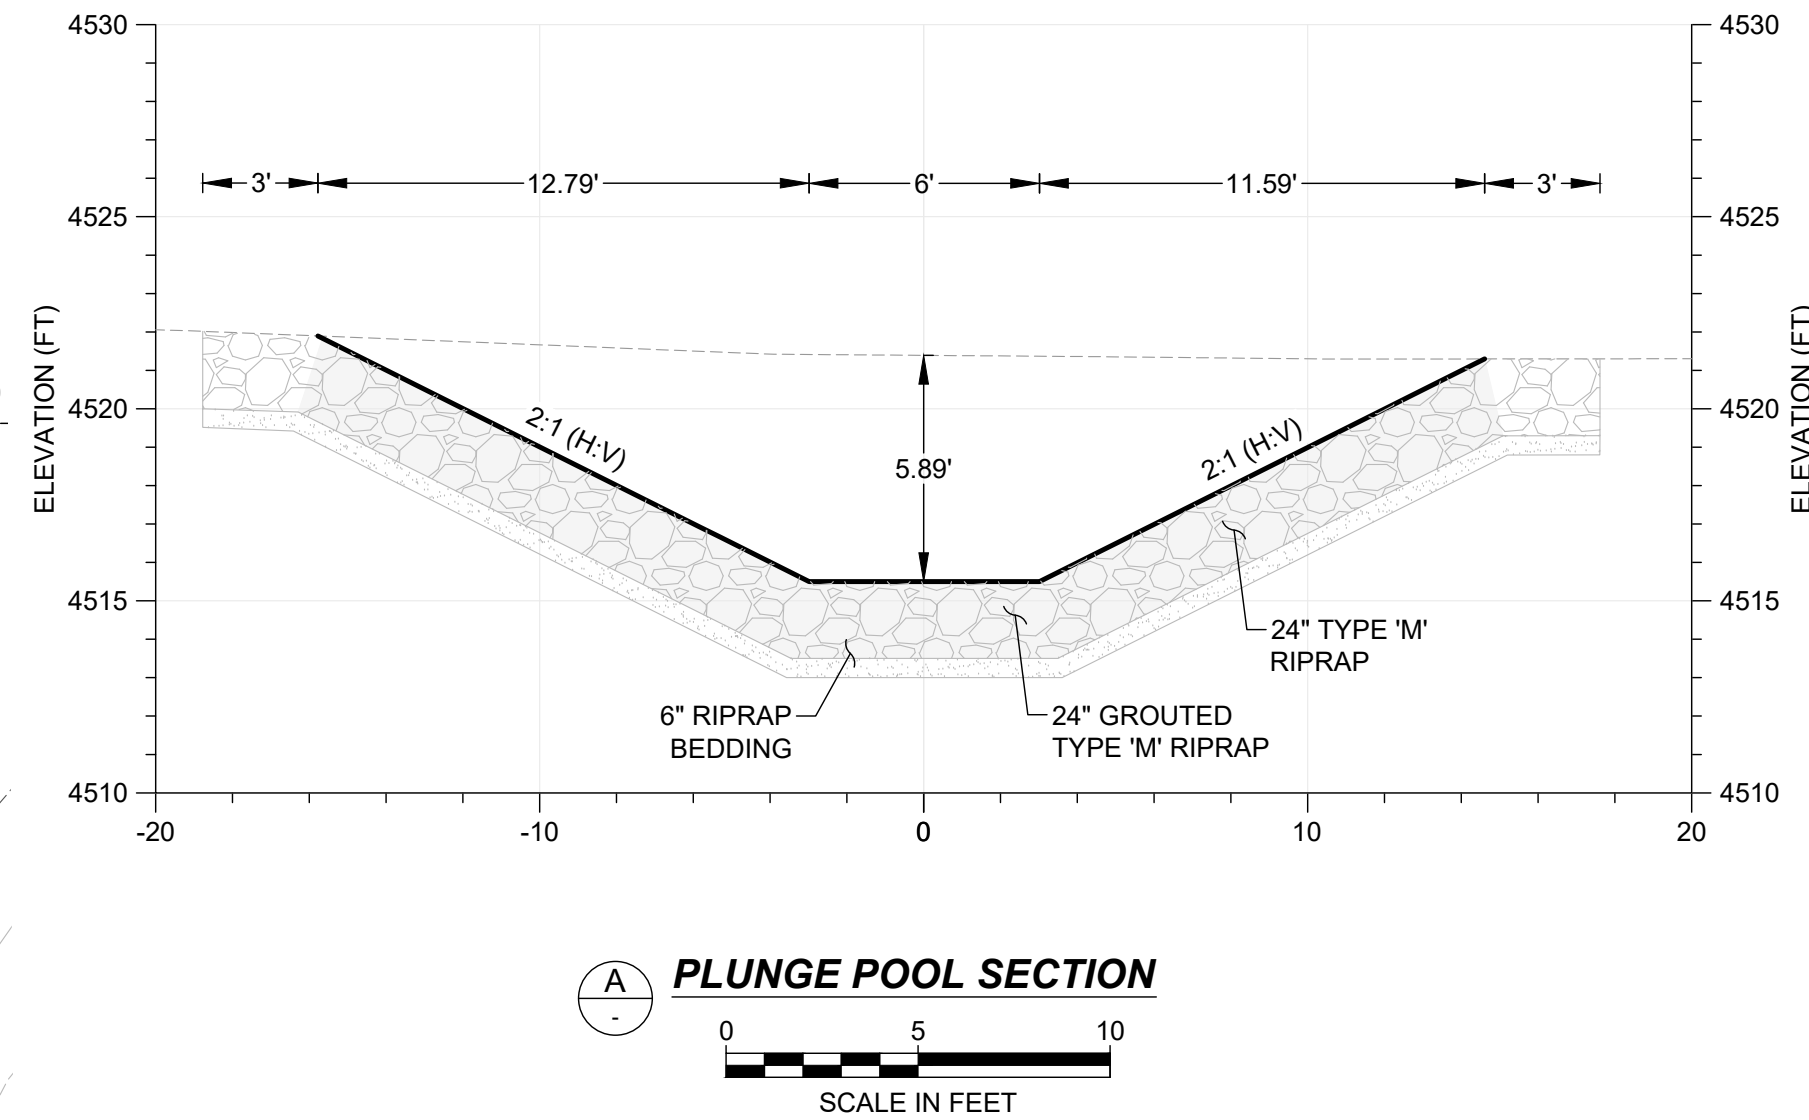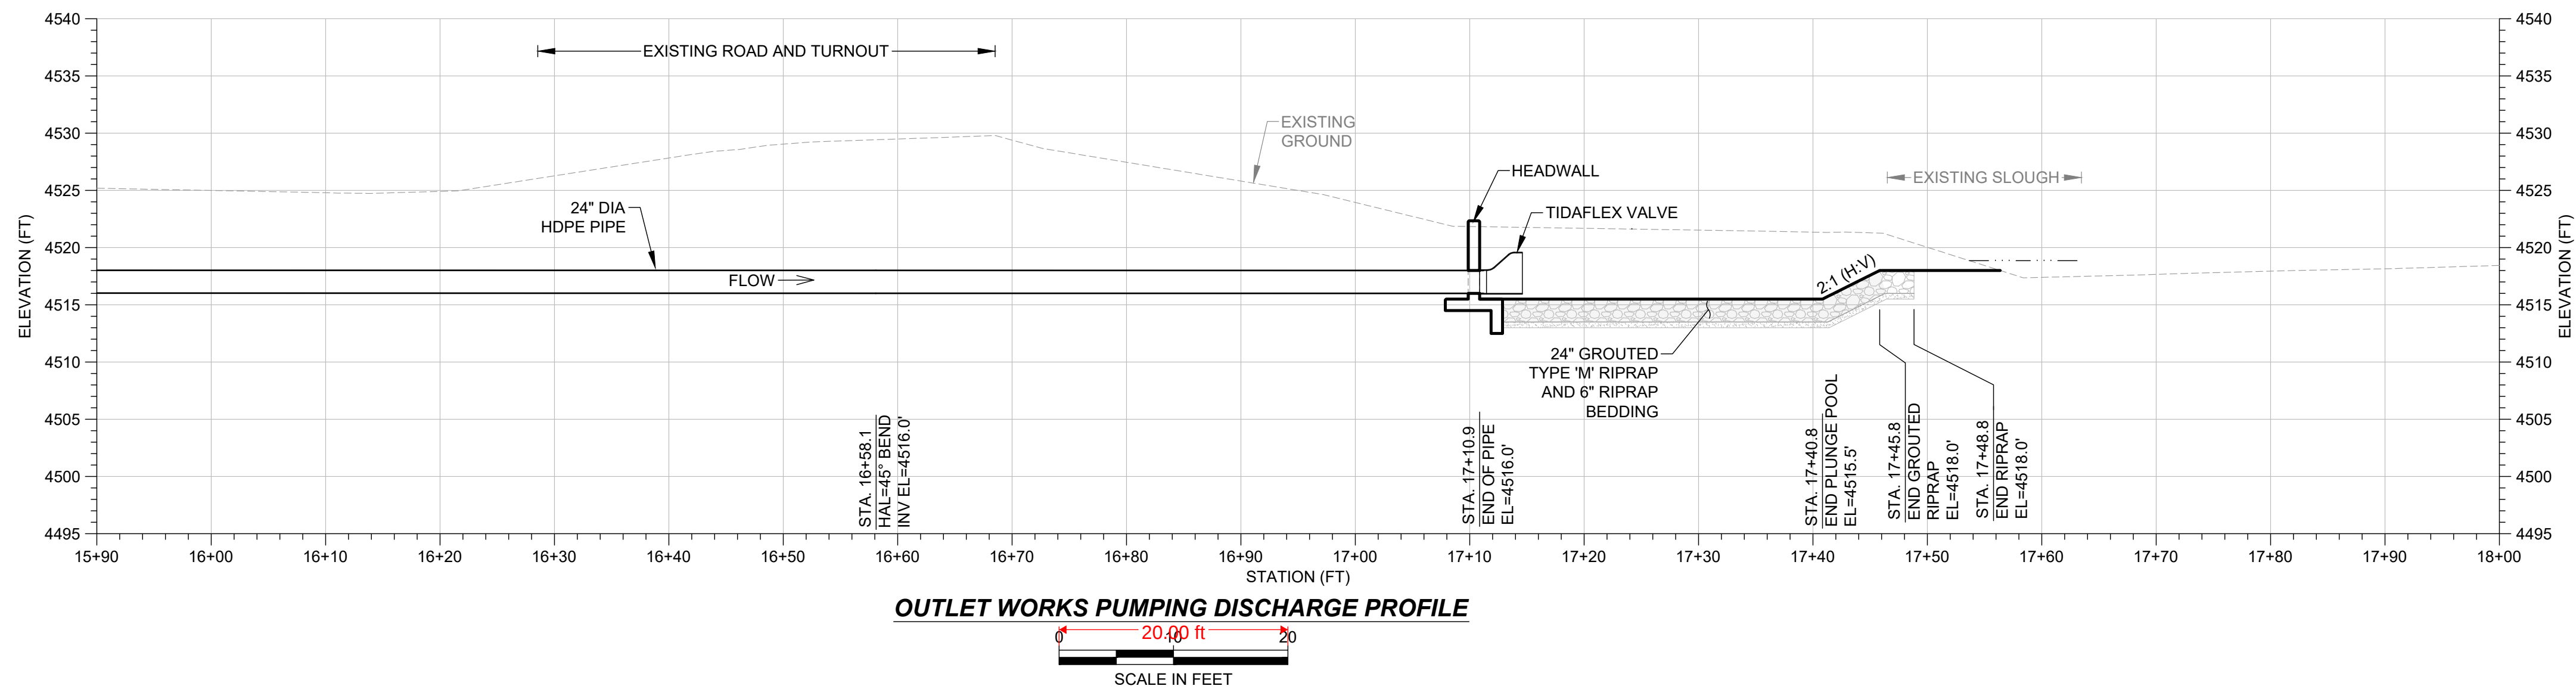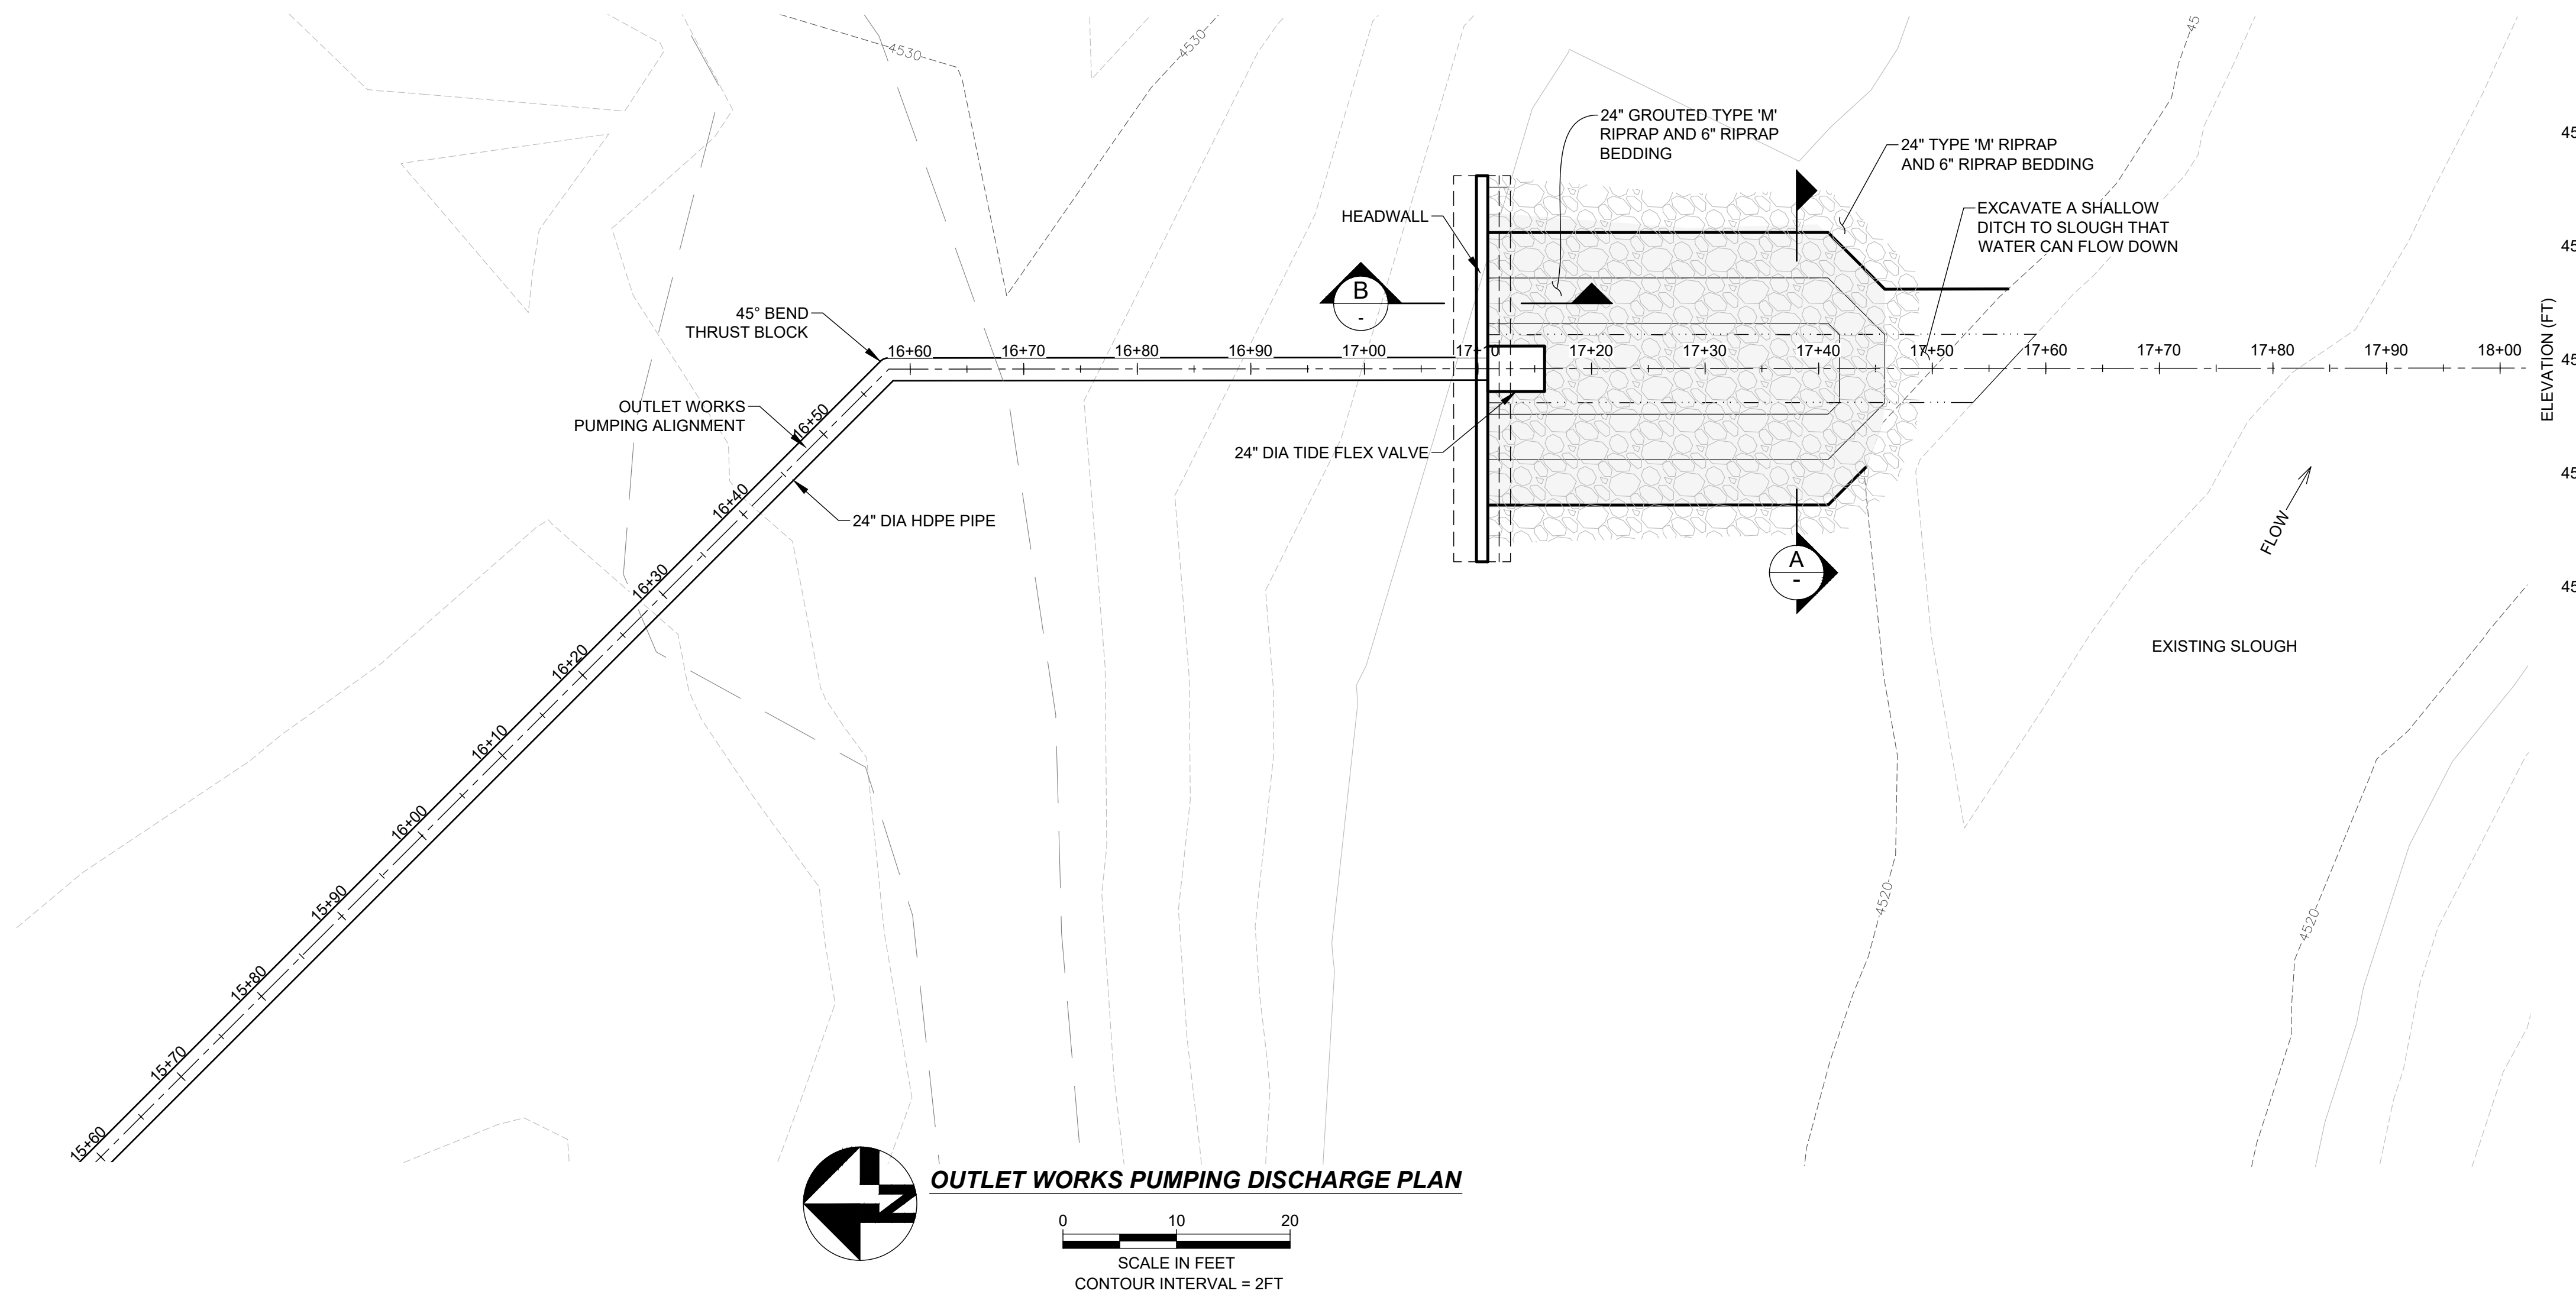


SEO CONSTRUCTION FILE NO. ----				SOUTH RESERVOIR PUMPING FACILITIES & DISCHARGE			
REVISIONS				OUTLET WORKS - DISCHARGE STRUCTURE			
NO.	DESCRIPTION	DATE	BY	DEERE & AULT			
1	DRAFT	4-16-21	BAB	A. SCHNABEL ENGINEERING COMPANY			
2	FOR BID	11-12-21	BAB	DESIGNED BY: BAB APPROVED BY: GGC			
				DRAWN BY: HOG DATE: 4/15/21			
				CHECKED BY: MAS SCALE: AS NOTED			
				JOB NO. 20C26014.02		SHEET: 7	

  

  MANHOLE LIDS AND COVERS FOR THE FLOW
METER VAULT SHALL BE WATER TIGHT.

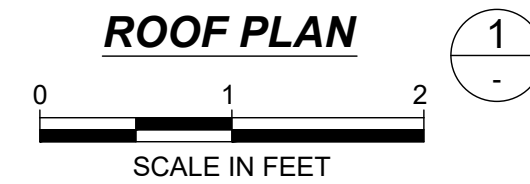


SUMP PUMP DETAIL

 

1. FINAL LOCATION TO BE VERIFIED IN FIELD WITH ENGINEER.

 1 BOLLARD DETAIL







1. INSIDE FACE BENT REBAR @ CORNERS
SHALL BE HOOK & SPLICE LENGTHS .
OUTSIDE FACE BENT REBAR @ CORNERS
SHALL BE LAP & LAP LENGTHS.
2. HORIZONTAL AND VERTICAL CORNERS.

TYPICAL CORNER REINFORCEMENT DETAIL

NTS

SEO CONSTRUCTION FILE NO. -----				SOUTH RESERVOIR PUMPING FACILITIES & DISCHARGE			
REVISIONS				FLOW METER VAULT			
NO.	DESCRIPTION	DATE	BY	DEERE & AULT A SCHNABEL ENGINEERING COMPANY 600 S. AIRPORT RD., BLDG. A, SUITE 205 LONGMONT, CO 80503 TEL 303.651.1468 FAX 303.651.1469			
1	DRAFT	4-16-21	BAB				
2	FOR BID	11-12-21	BAB	DESIGNED BY: BAB APPROVED BY: GGC JOB NO. SHEET: DRAWN BY: HOG DATE: 4/15/21 CHECKED BY: MAS SCALE: AS NOTED 20C26014.02 9			

Friday, November 12, 2021 3:35:20 PM DRAWING: G:\2020\Longmont\20C26014.02 Temporary Outlet - Pump Facility\03_SE_Products\08-CAD\04-CONTRACT_DWG\SPPE Pipeline Profiles.DWG

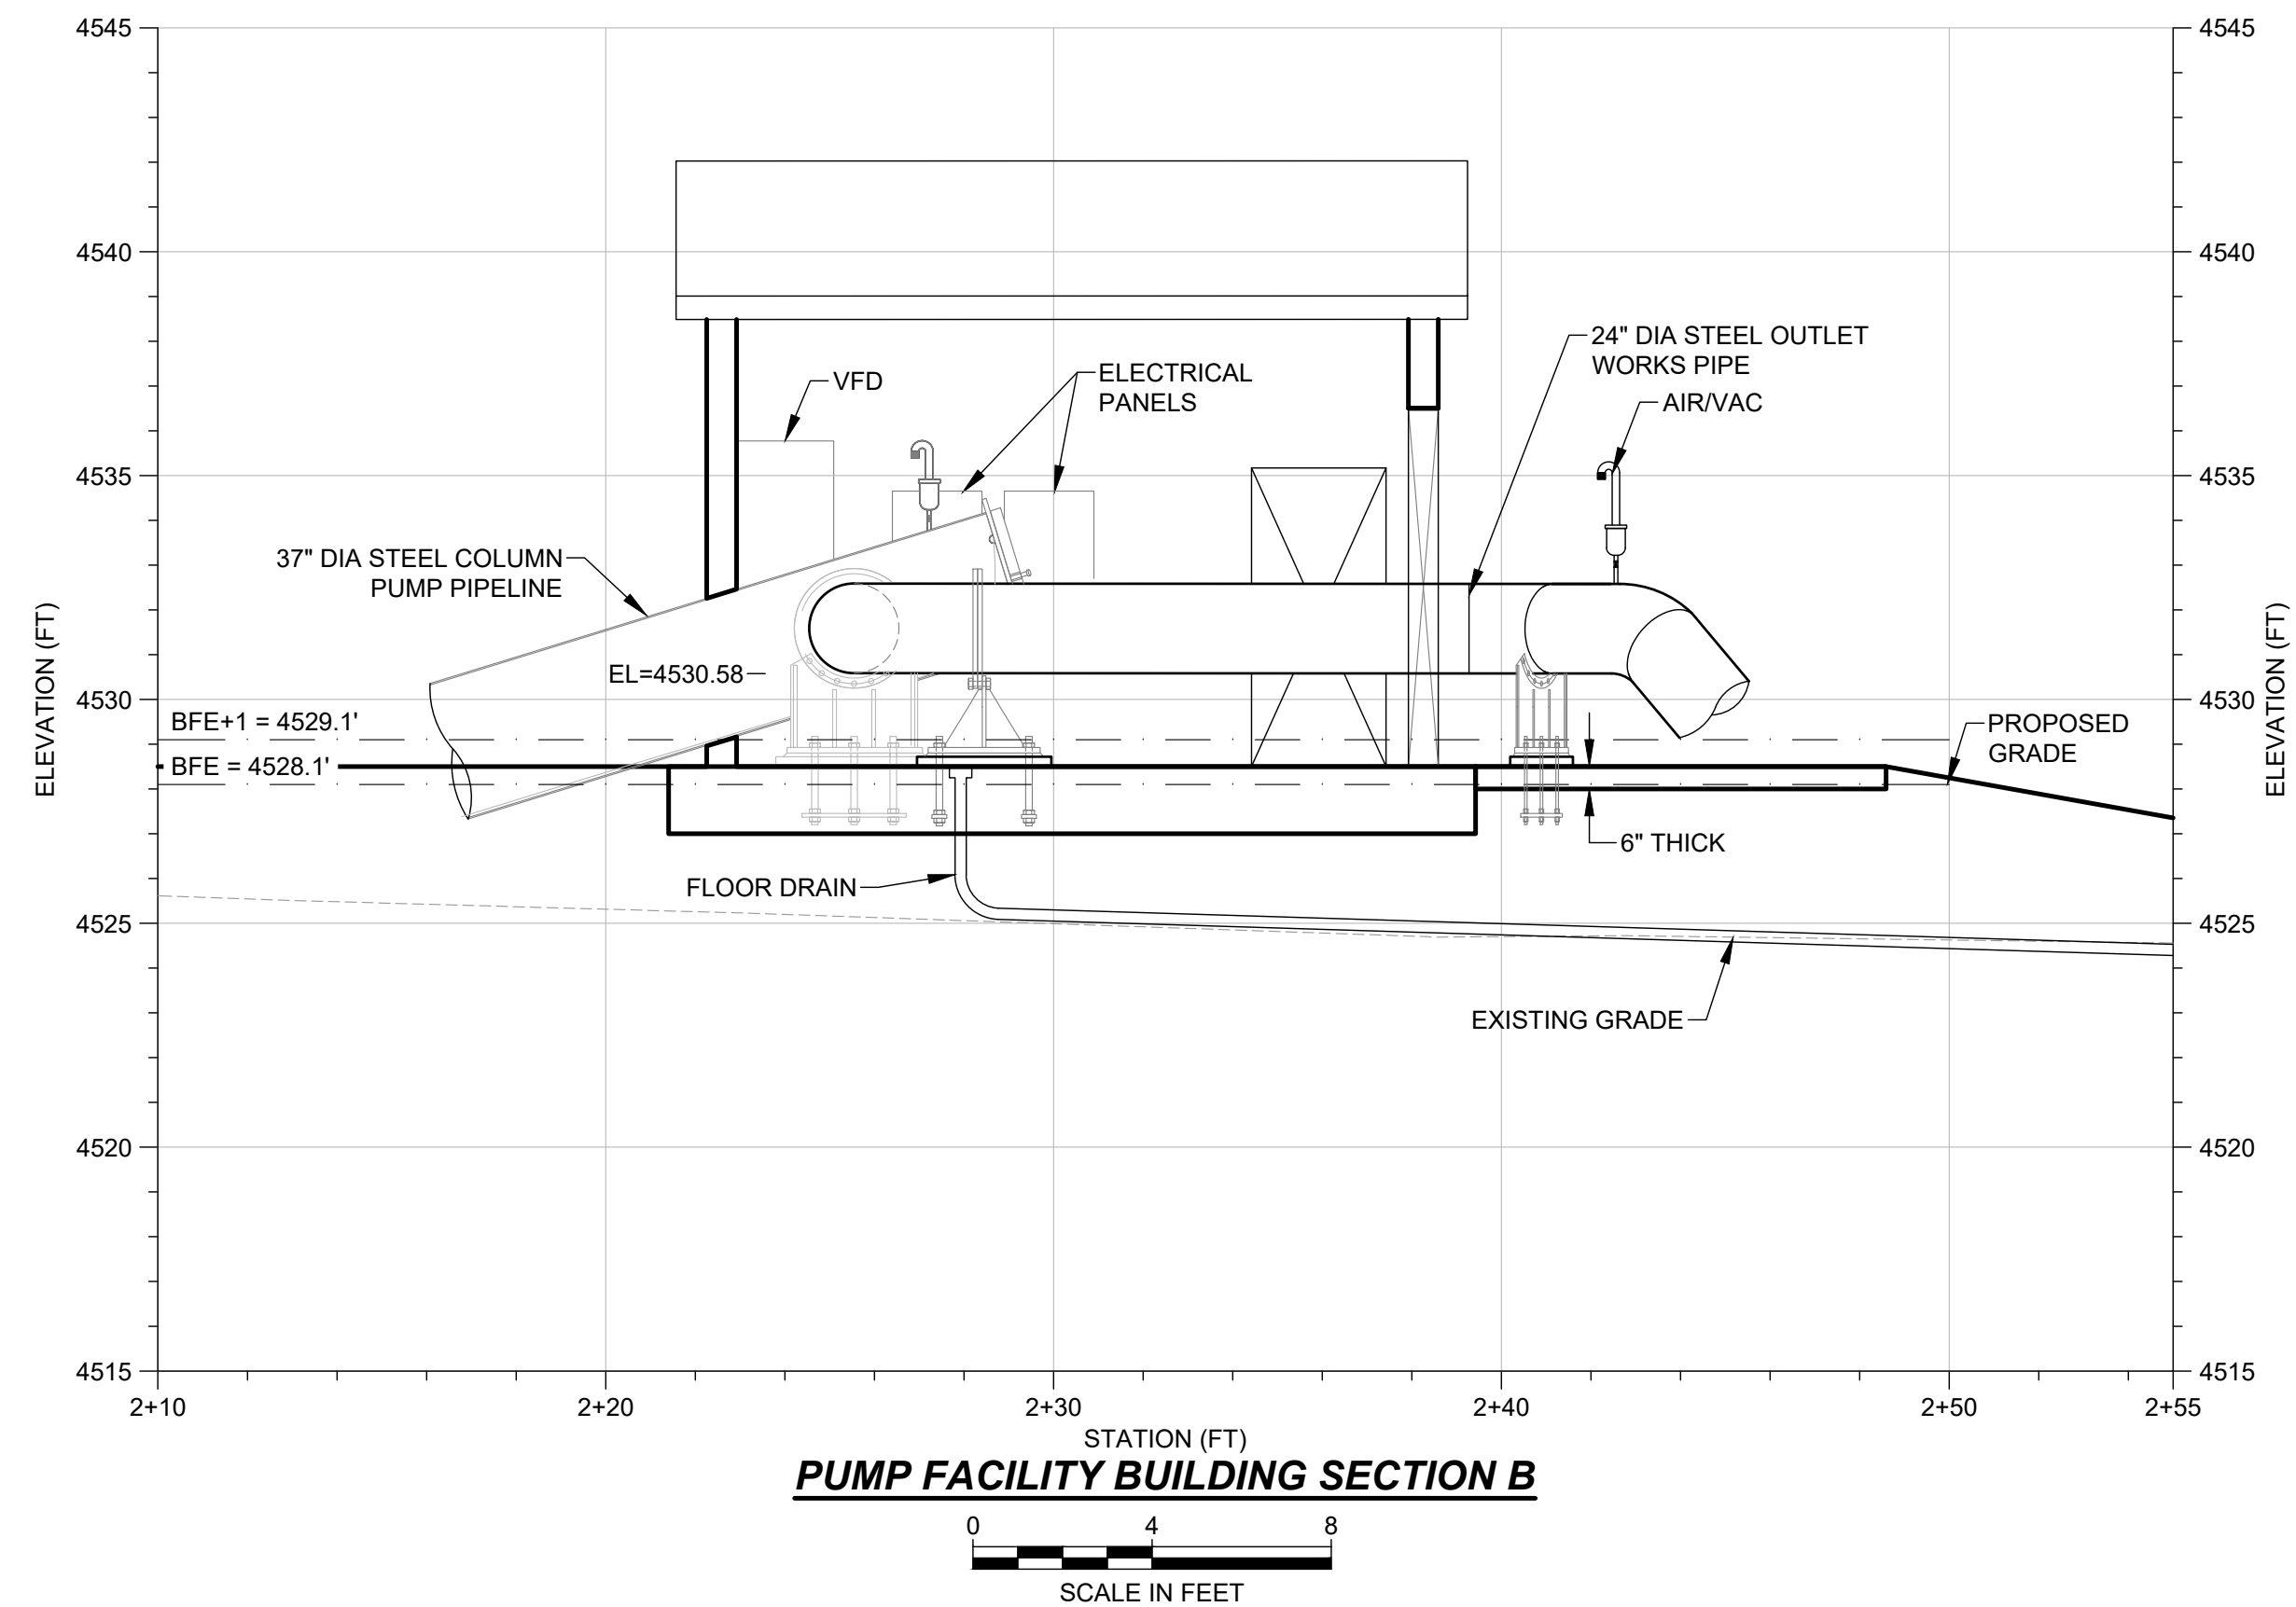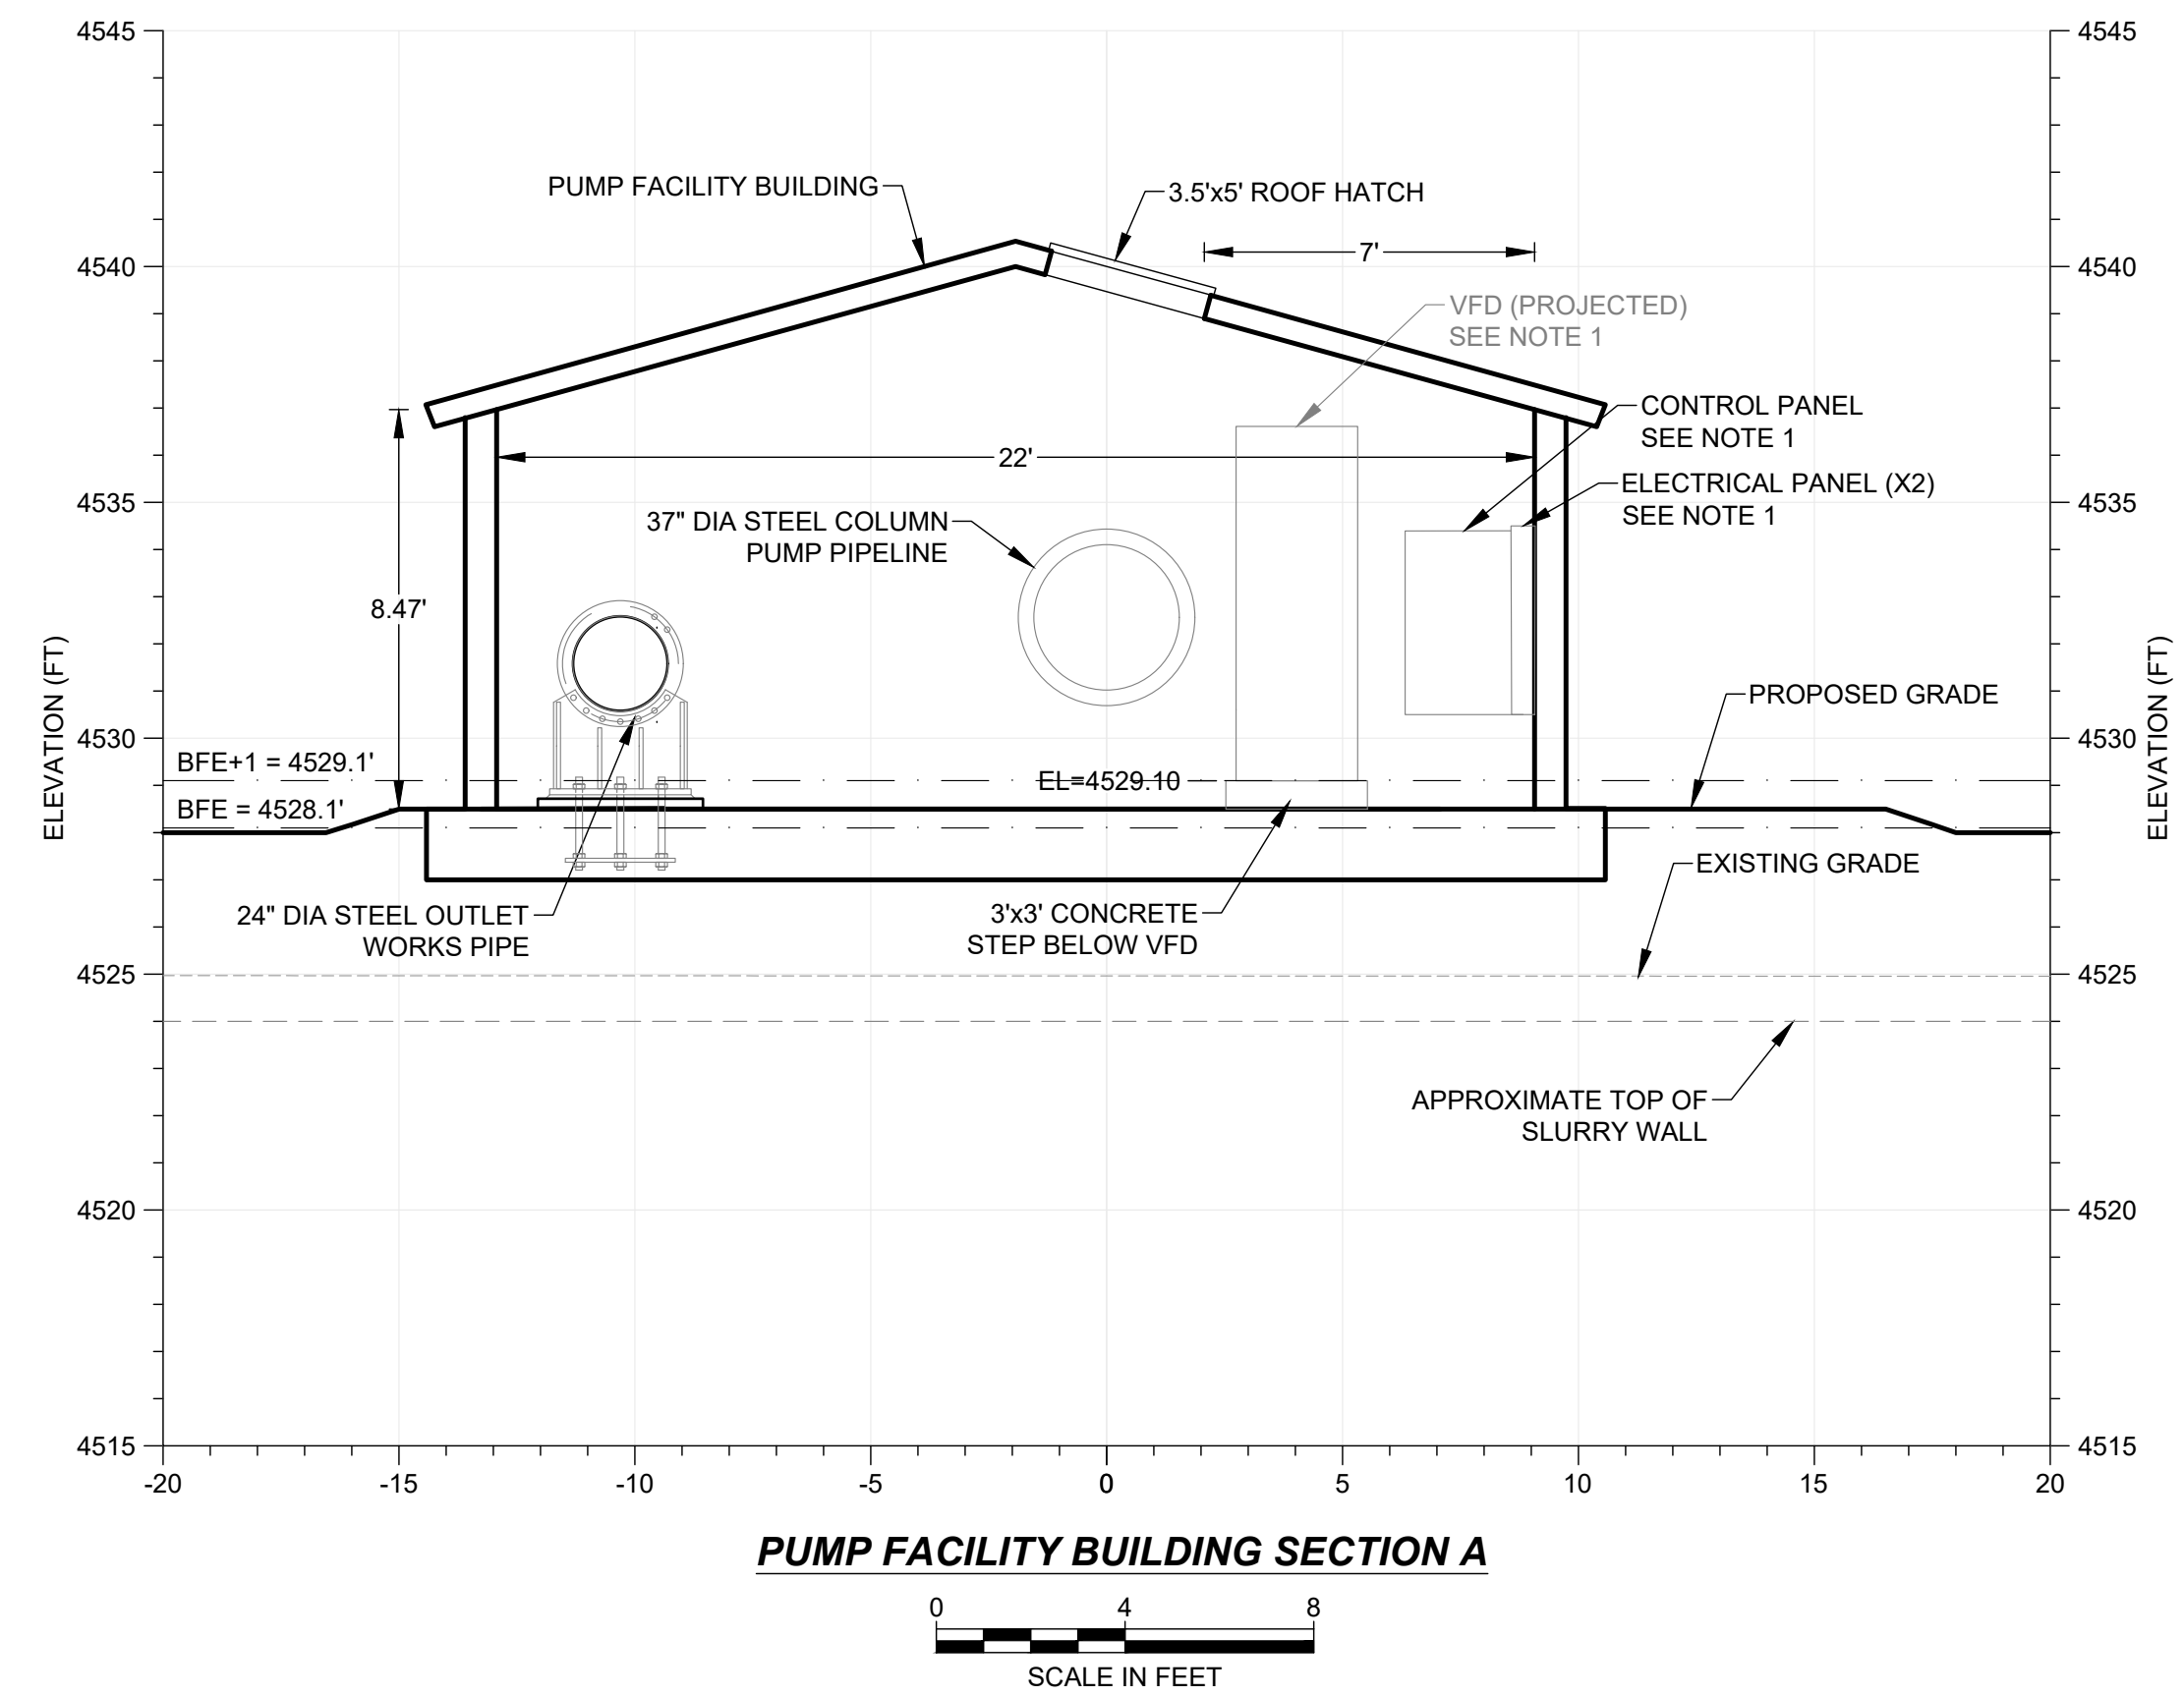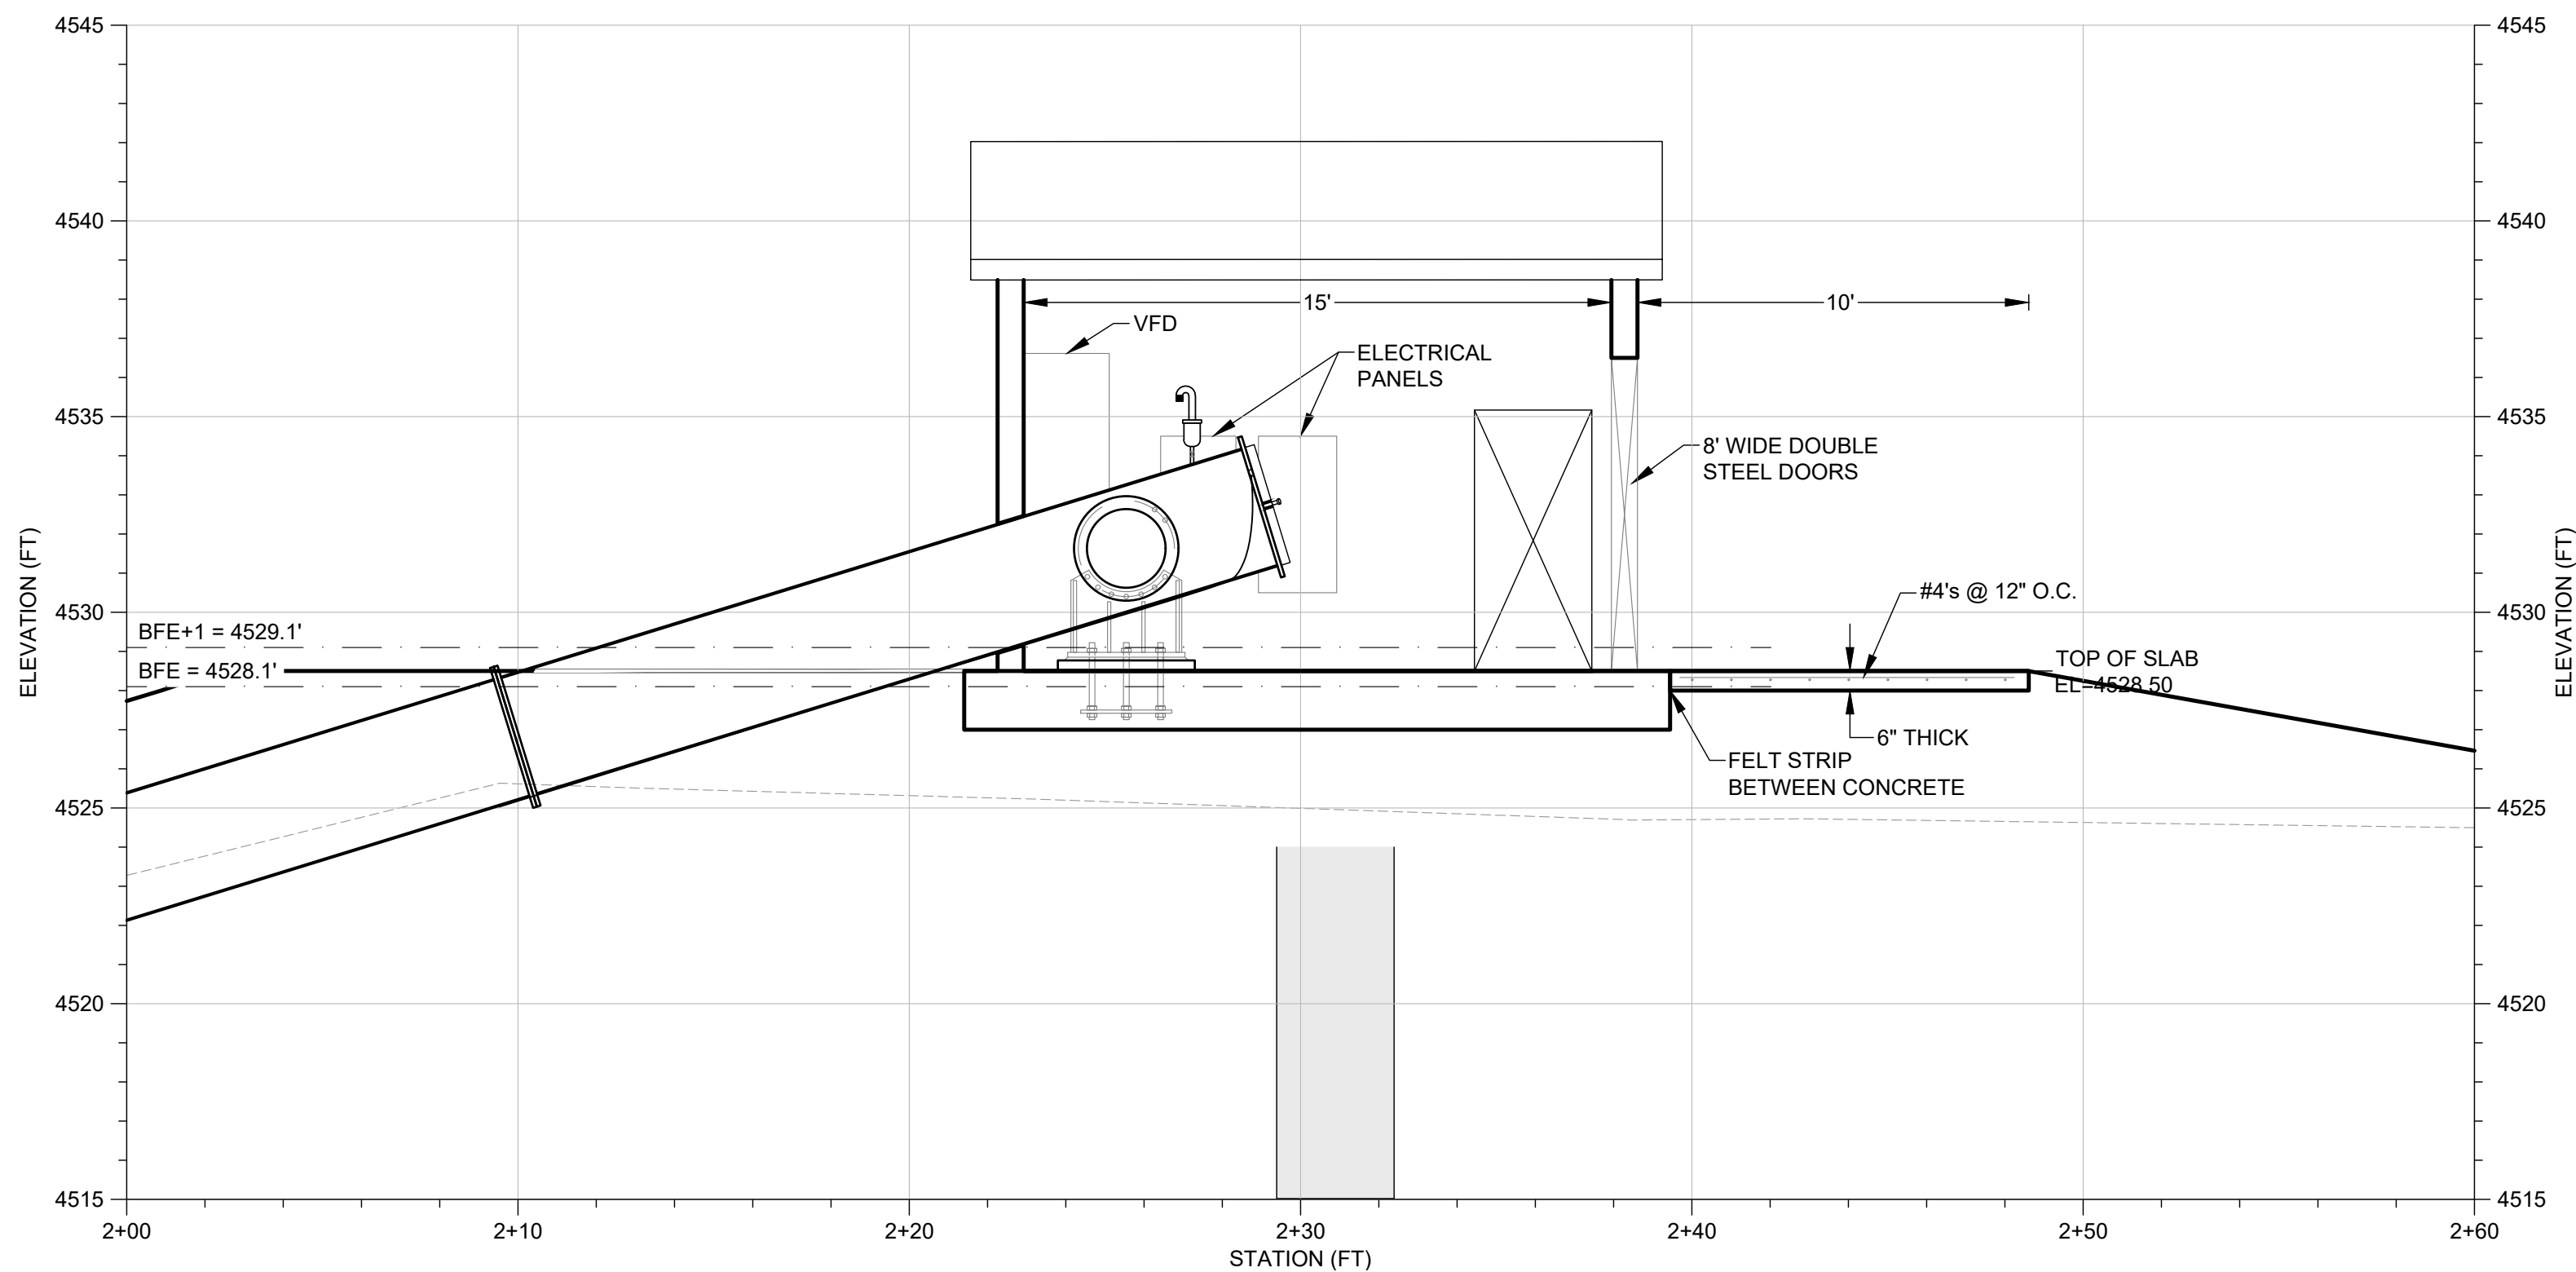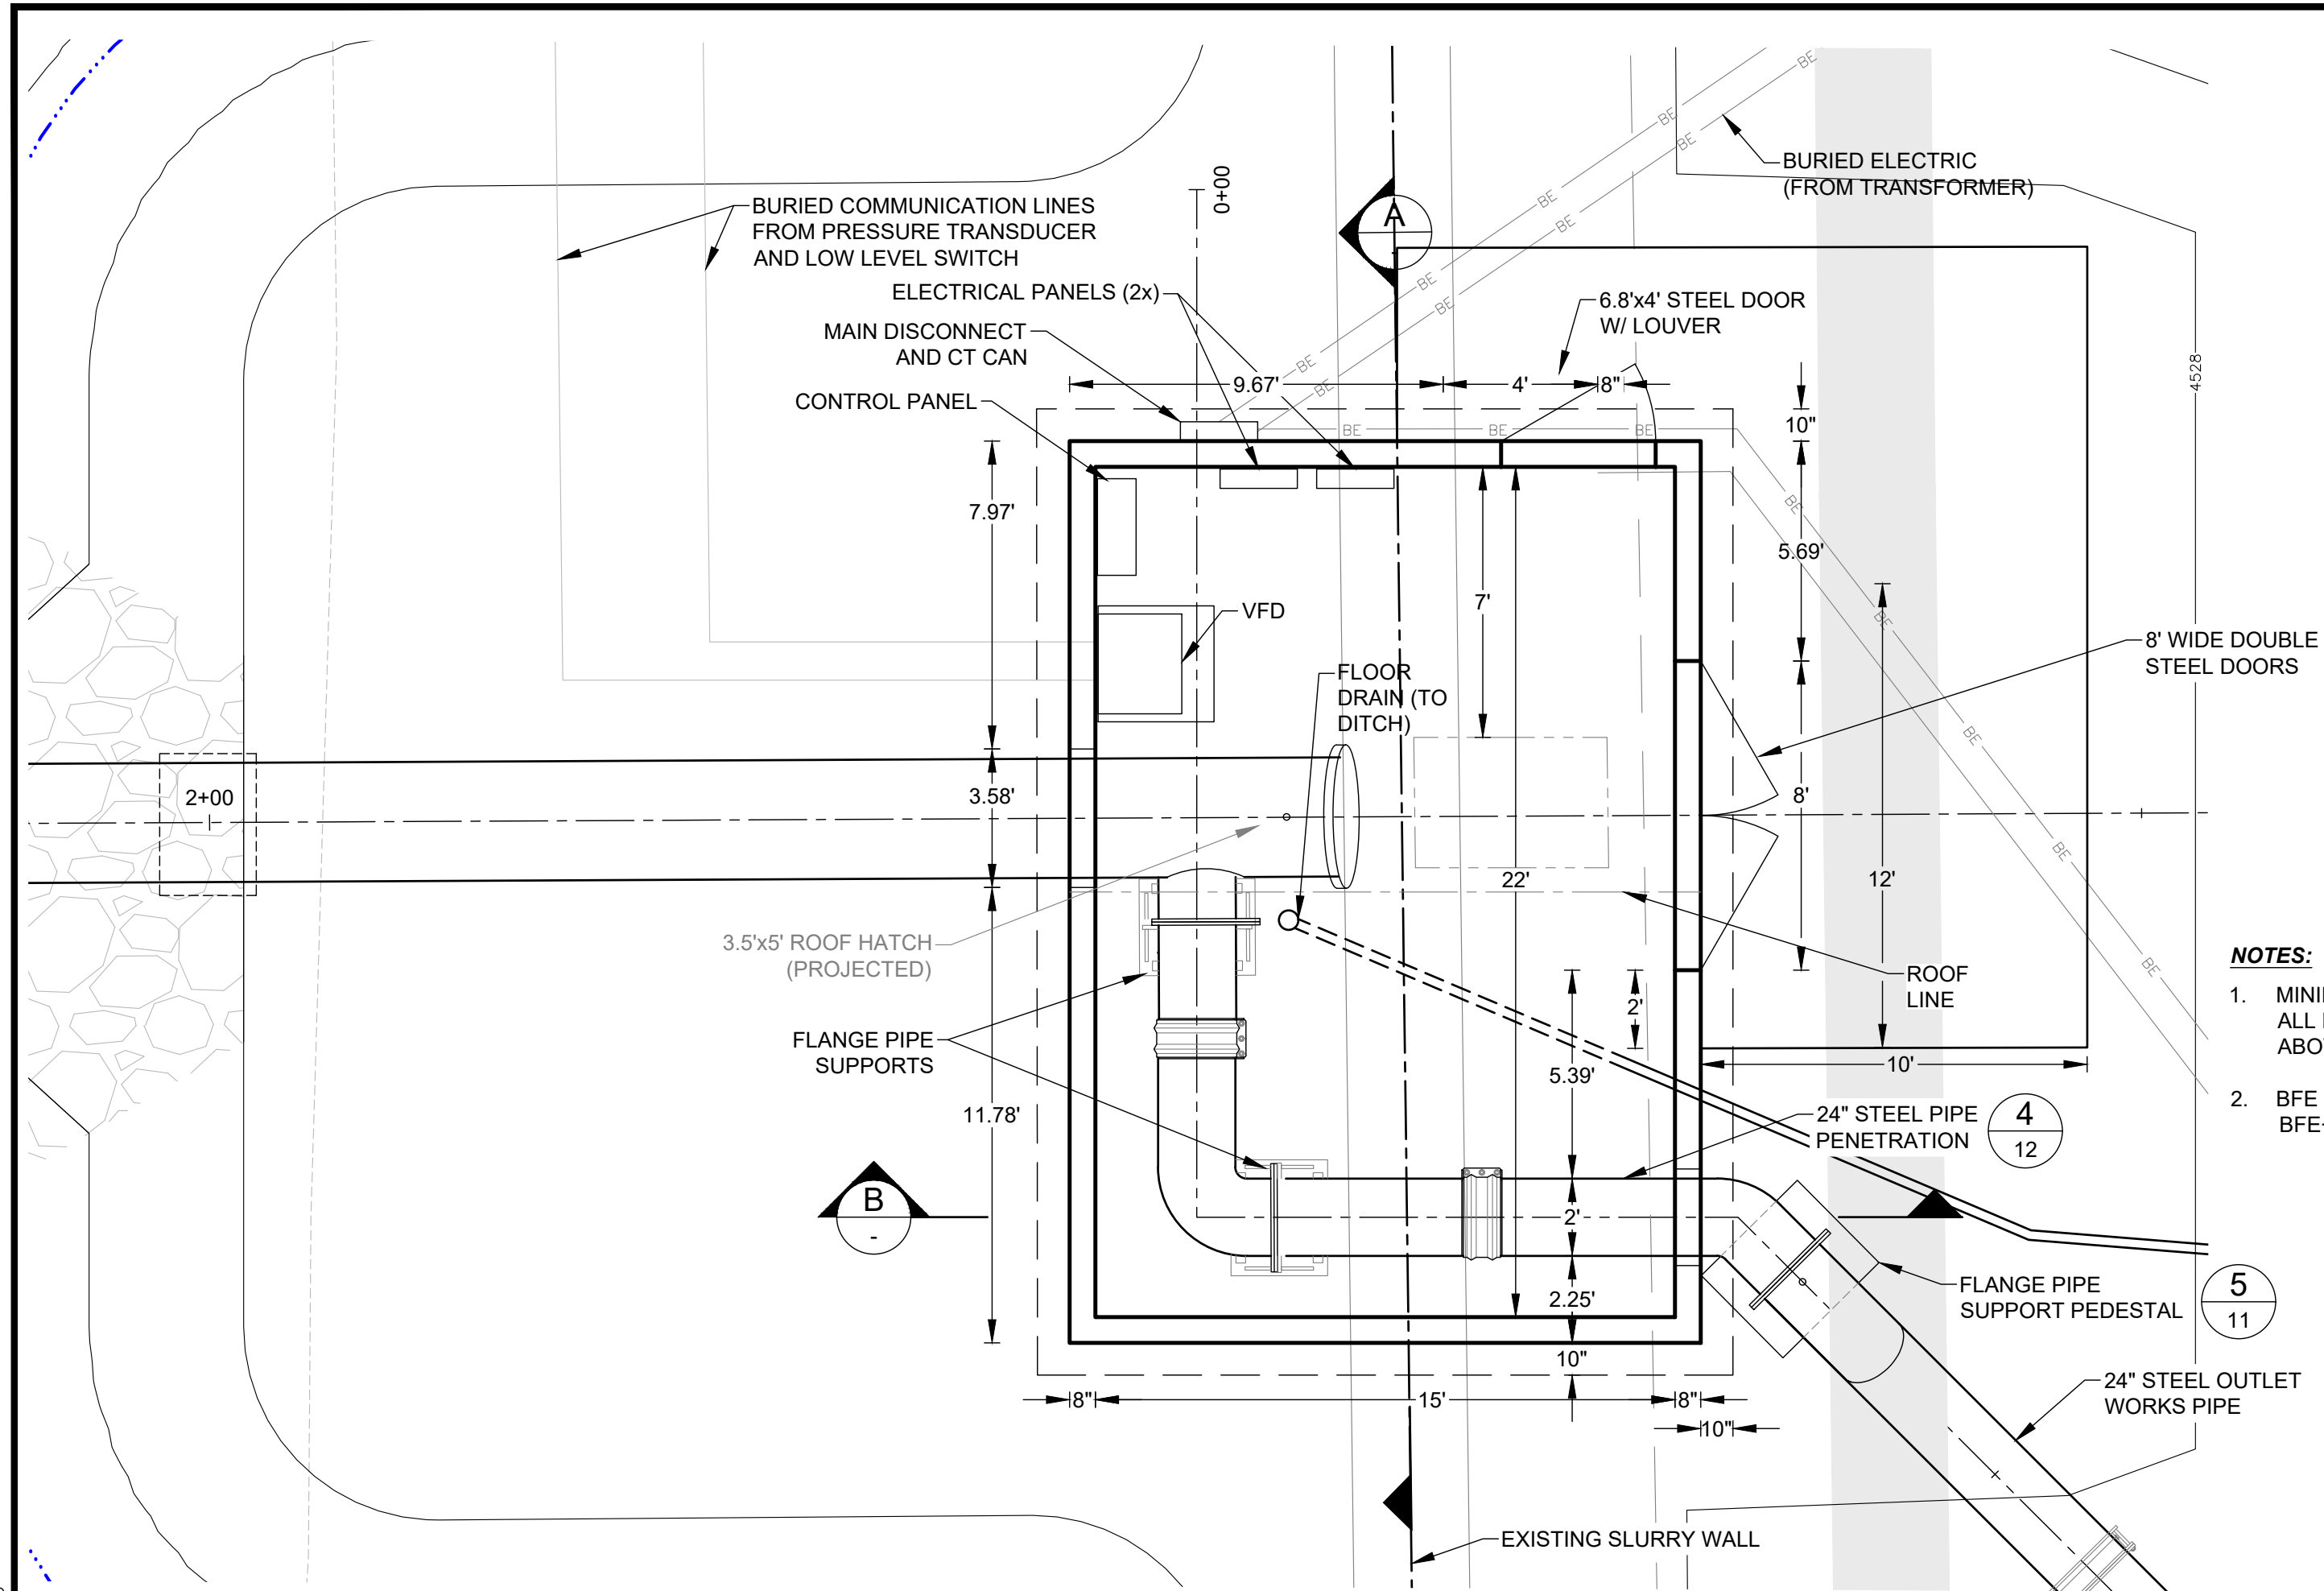


SEO CONSTRUCTION FILE NO.				SOUTH RESERVOIR PUMPING FACILITIES & DISCHARGE			
REVISIONS				COLUMN PUMP STRUCTURE			
NO.	DESCRIPTION	DATE	BY				
1	DRAFT	4-16-21	BAB				
2	FOR BID	11-12-21	BAB				



SEO CONSTRUCTION FILE NO.				SOUTH RESERVOIR PUMPING FACILITIES & DISCHARGE					

REVISIONS				PUMP BUILDING DETAILS					
NO.	DESCRIPTION	DATE	BY						
1	DRAFT	4-16-21	BAB	DEERE & AULT 600 S. AIRPORT RD., BLDG. A, SUITE 205 LONGMONT, CO 80503 TEL 303.651.1468 FAX 303.651.1469 A SCHNABEL ENGINEERING COMPANY					
2	FOR BID	11-12-21	BAB						
				DESIGNED BY:	BAB	APPROVED BY:	GGC	JOB NO.	SHEET:
				DRAWN BY:	HOG	DATE:	4/15/21	20C26014.02	11
				CHECKED BY:	MAS	SCALE:	AS NOTED		


Friday, November 12, 2021 3:47:49 PM DRAWING: G:\2020\Longmont\20C26014.02 Temporary Outlet - Pump Facility\03_SE_Products\08-CAD\04-CONTRACT-DWG\SEPF Pipeline Details.DWG

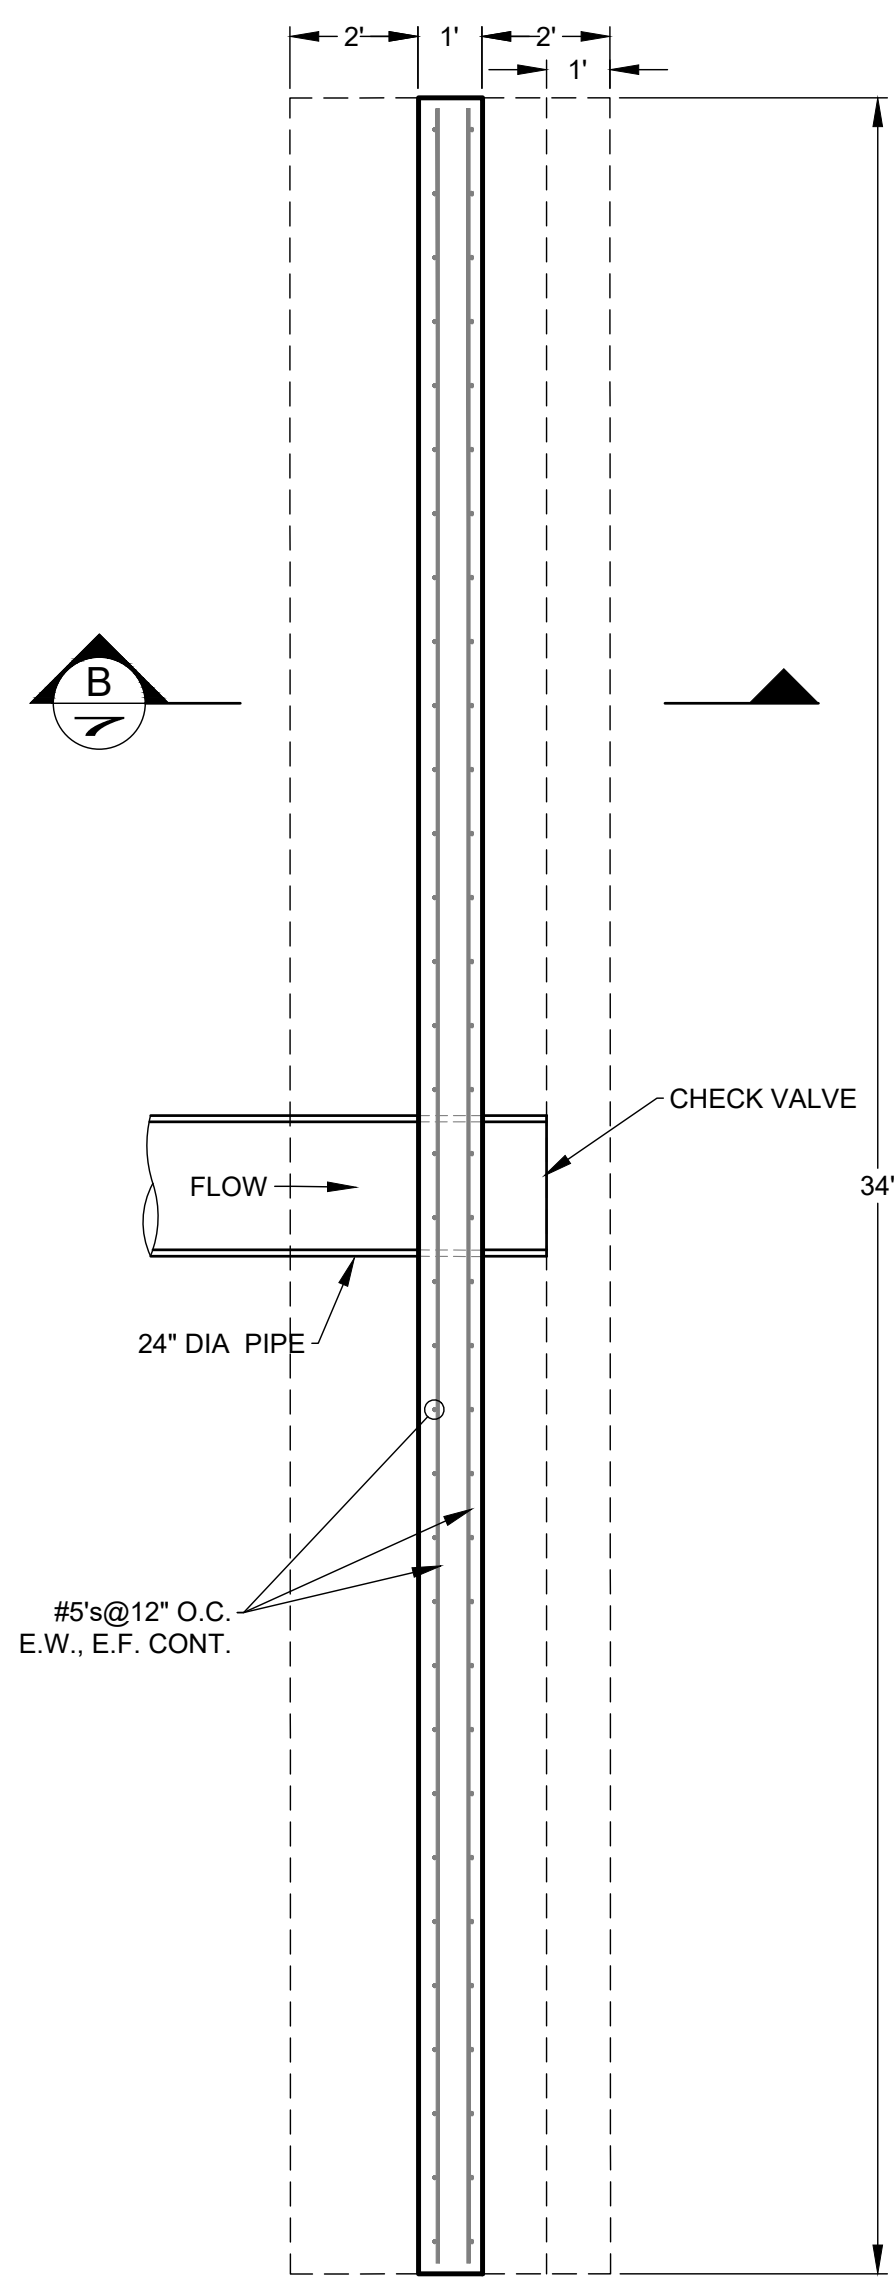

DISCHARGE STRUCTURE PLAN

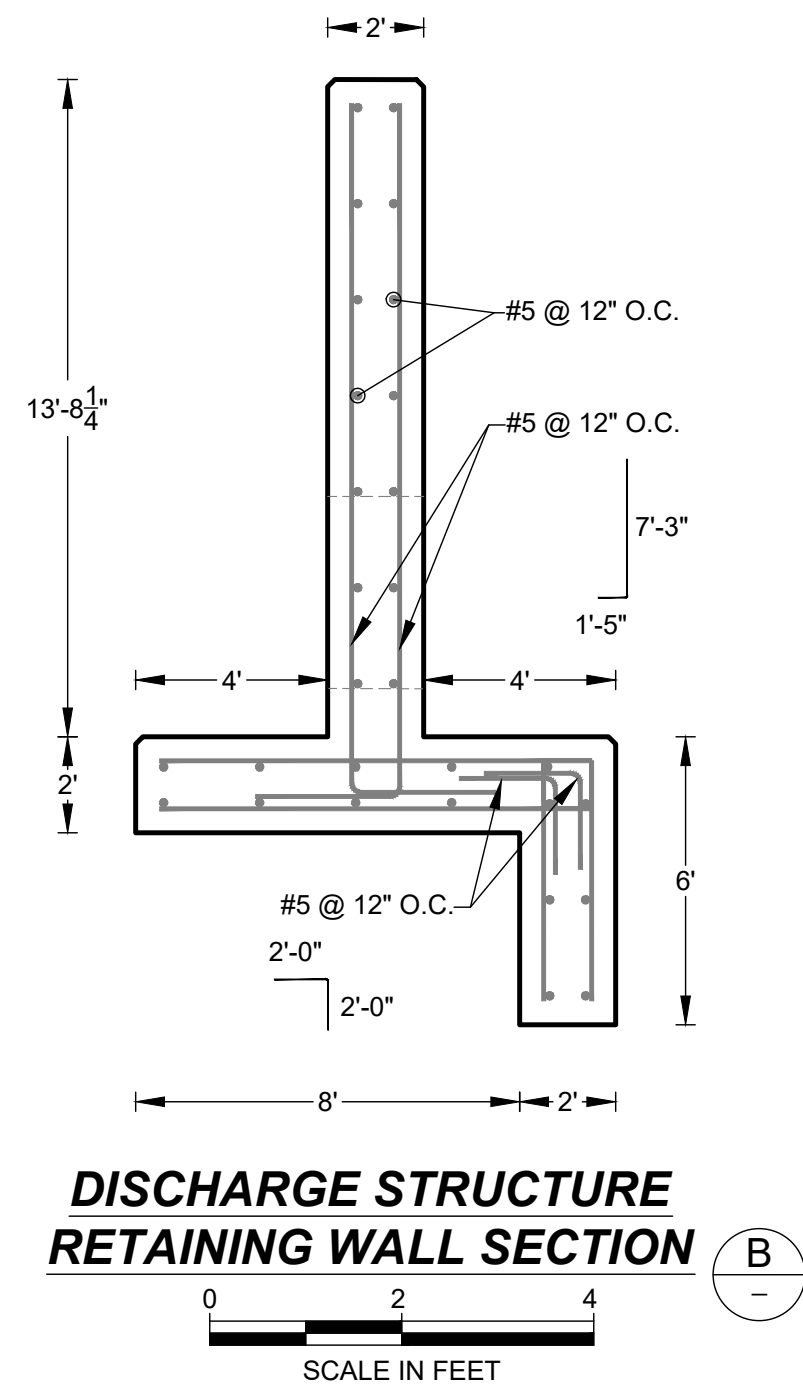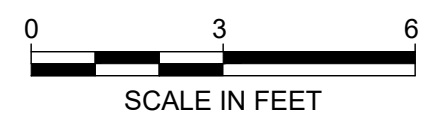


DISCHARGE STRUCTURE
RETAINING WALL SECTION


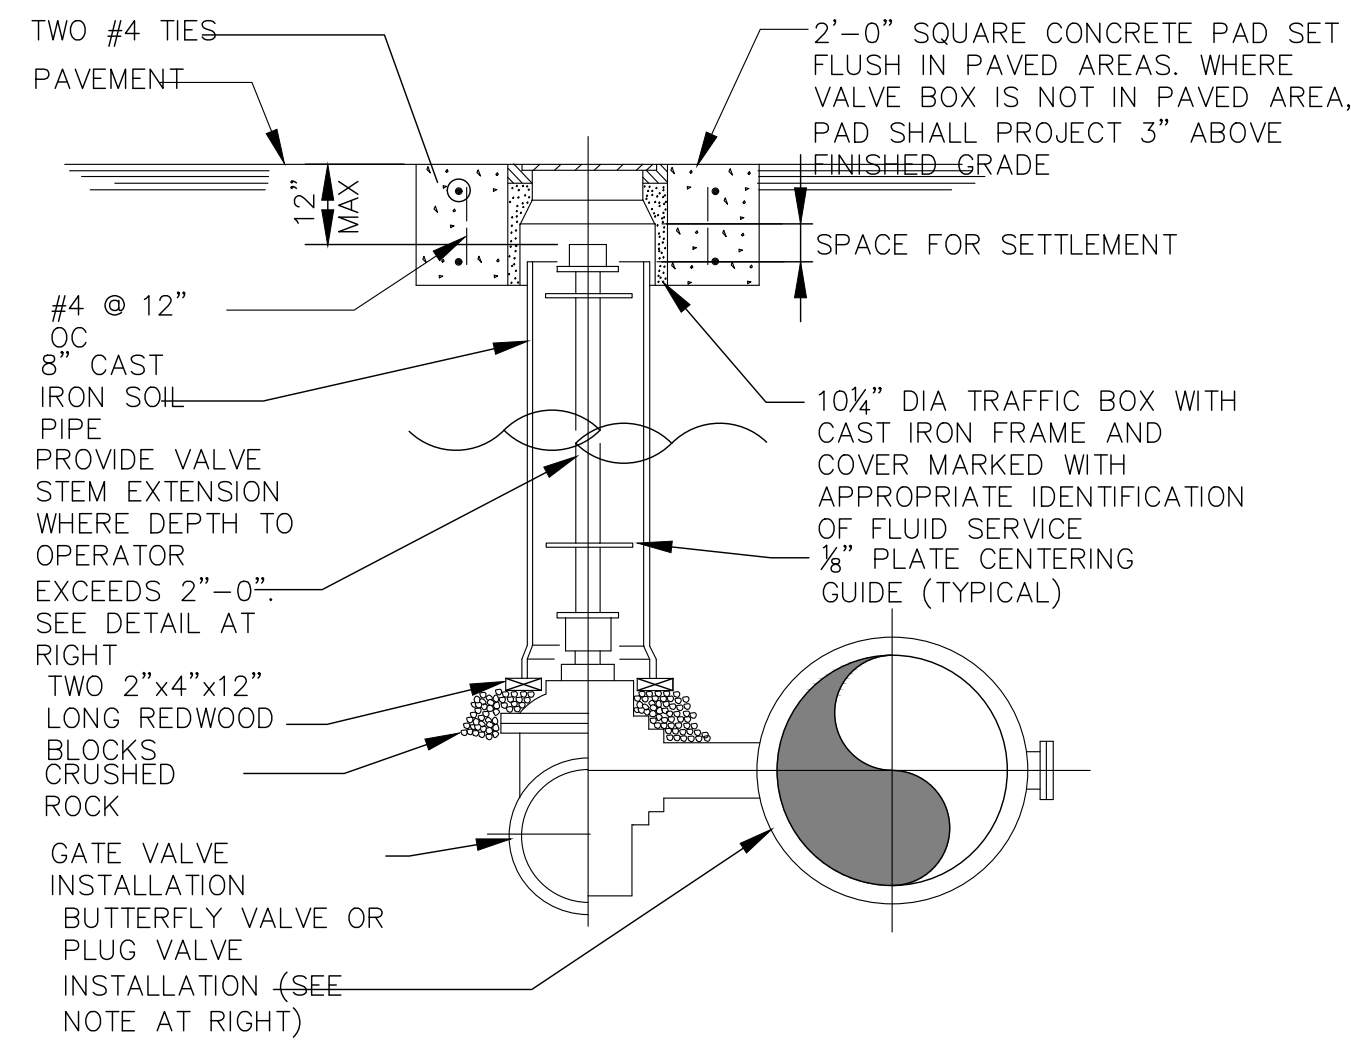


BURIED VALVE

NTS

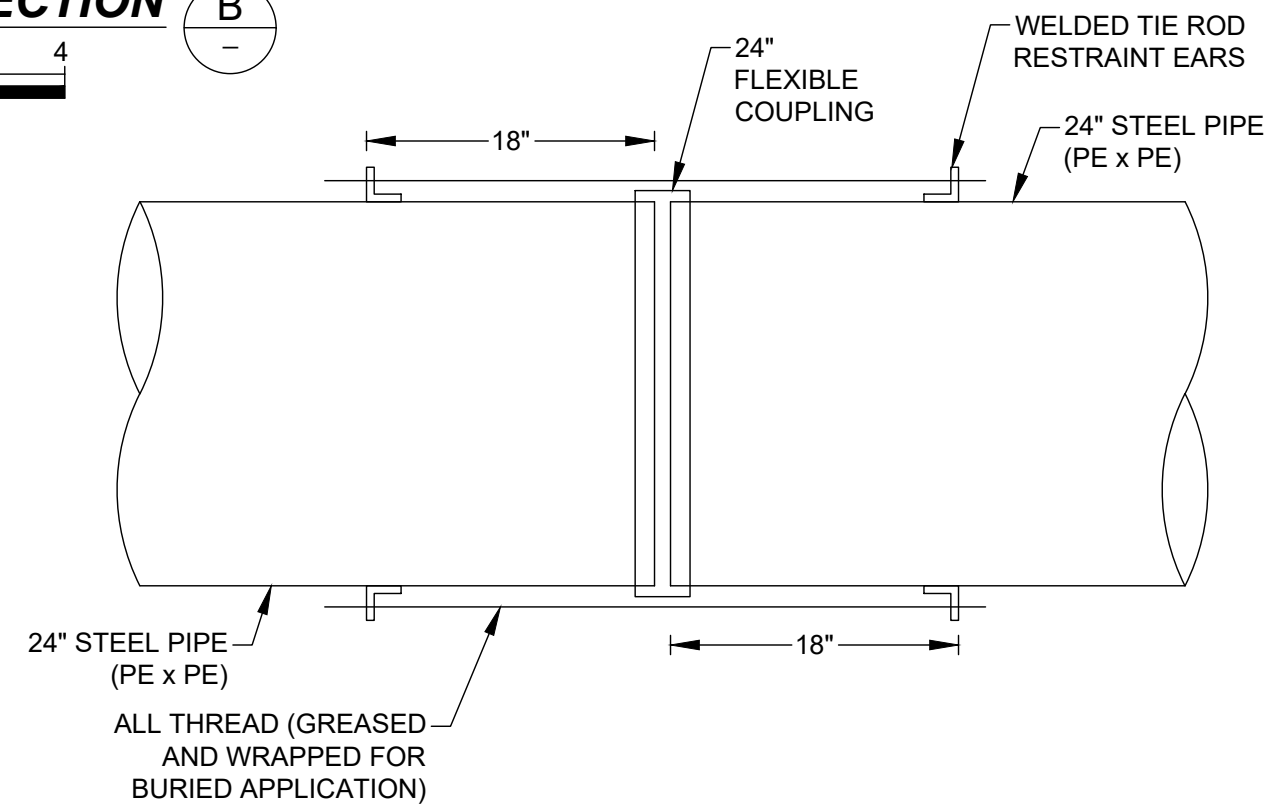


STEEL PIPE RESTRAINED FLEXIBLE COUPLING

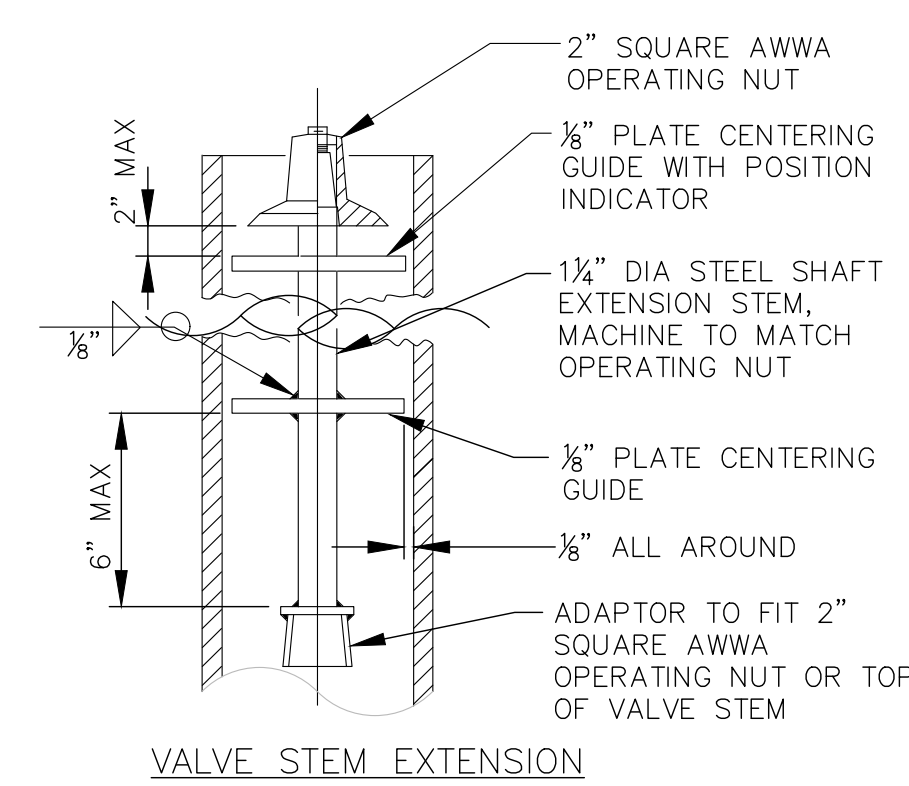 

VALVE STEM EXTENSION


NOTE:

FOR LUBRICATED PLUG VALVE, EXTEND LUBRICATION LINE TO GRADE PER MANUFACTURERS INSTRUCTIONS

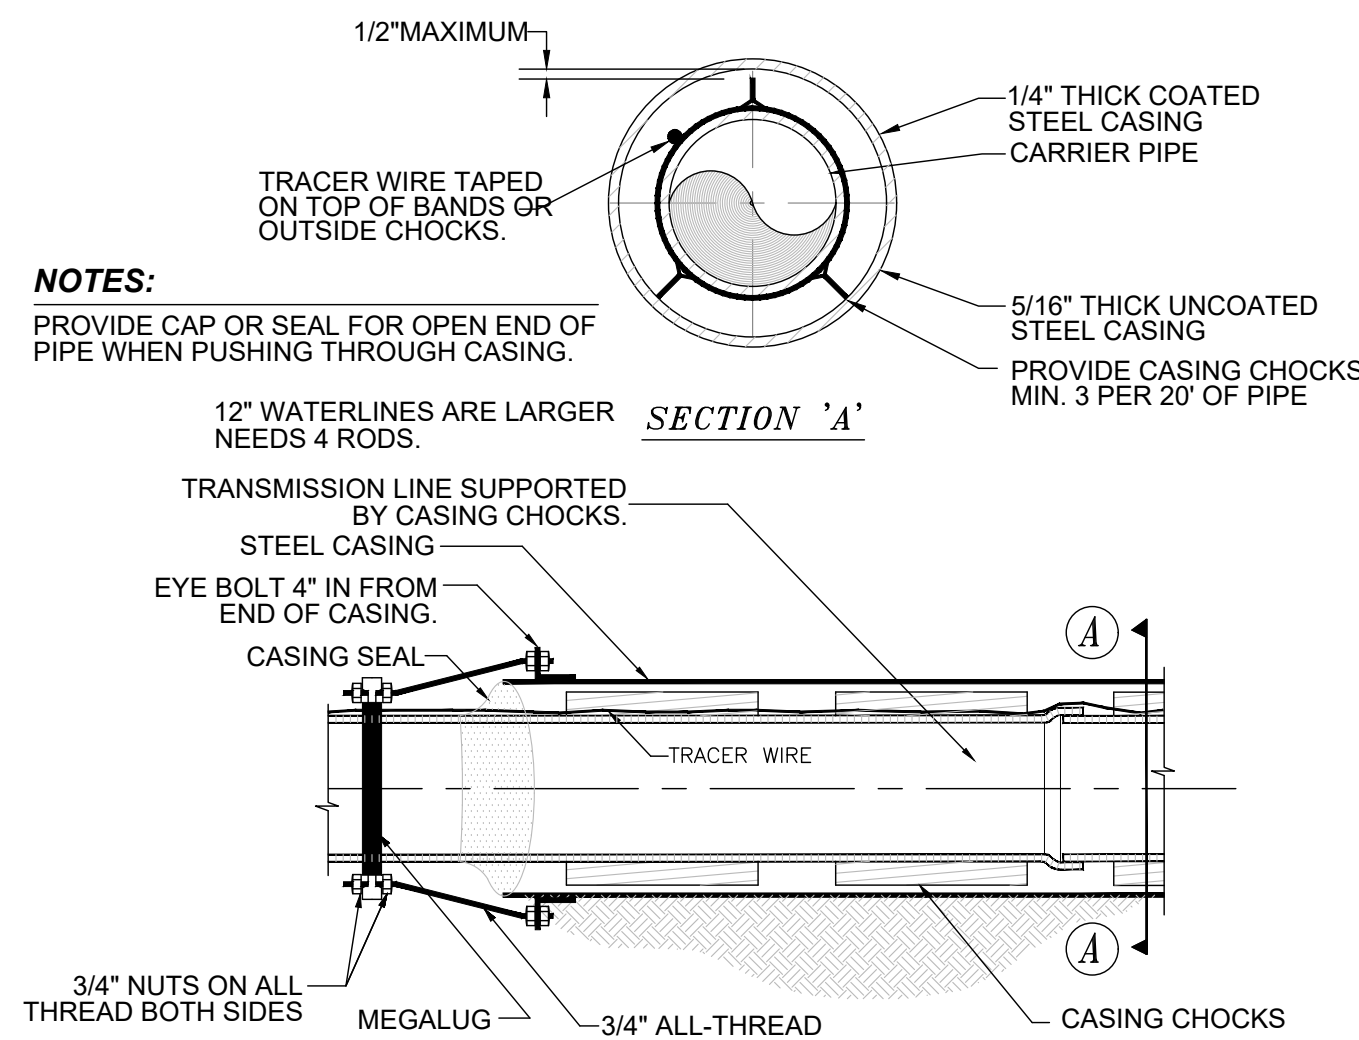


CASING DETAIL

NTS

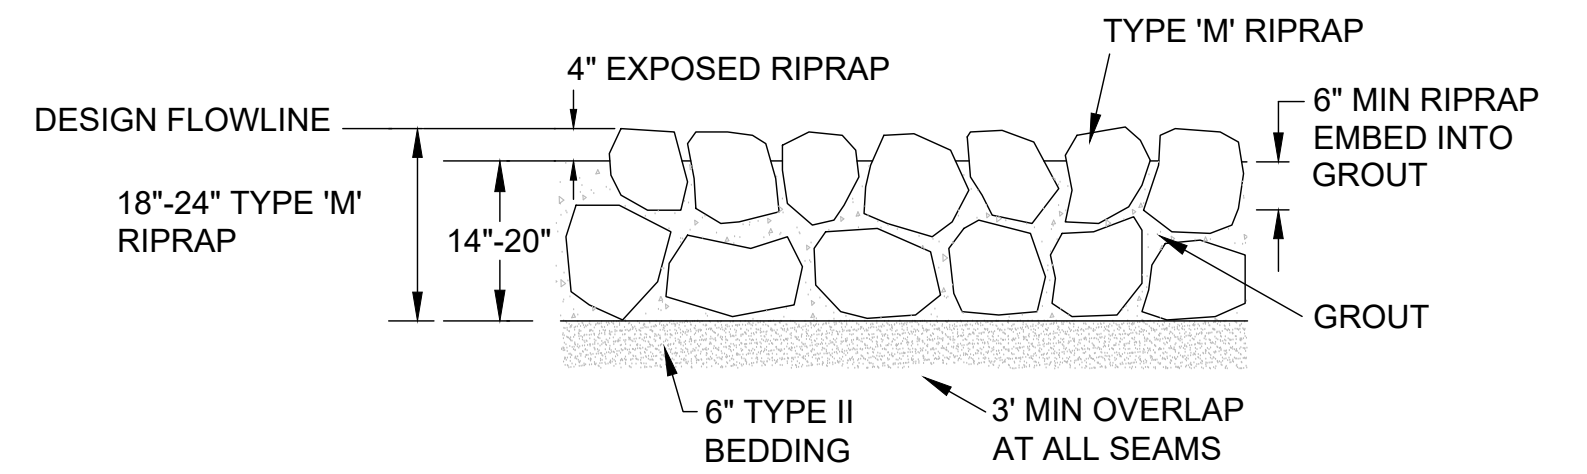

RIPRAP DETAIL

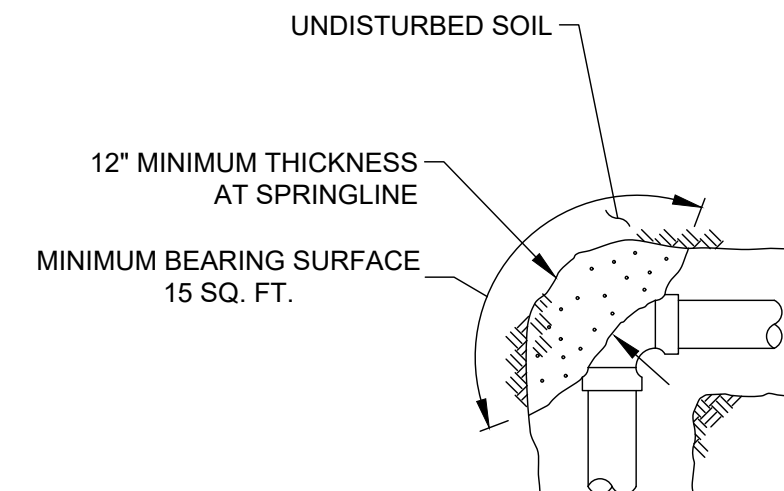


NOTE:


FIGURE (100%) AT THRUST BLOCK INDICATES PERCENT OF TOTAL THRUST TO BE APPLIED FOR BEARING AREA

THRUST BLOCK DETAIL

NTS

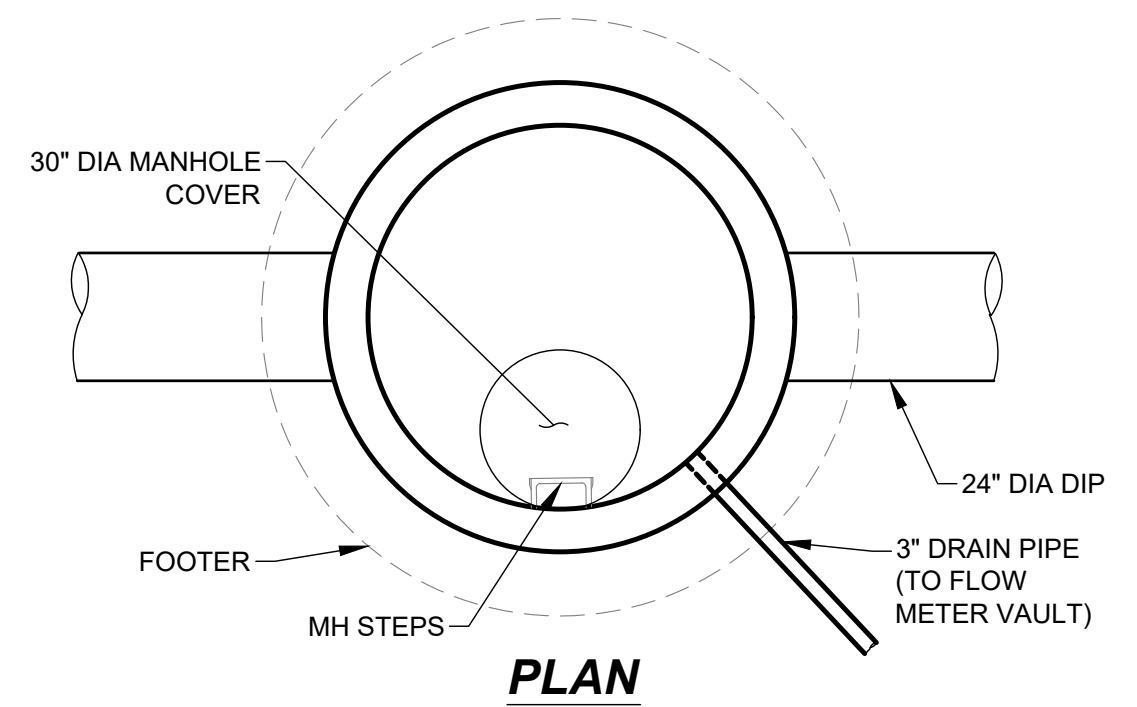


PLAN

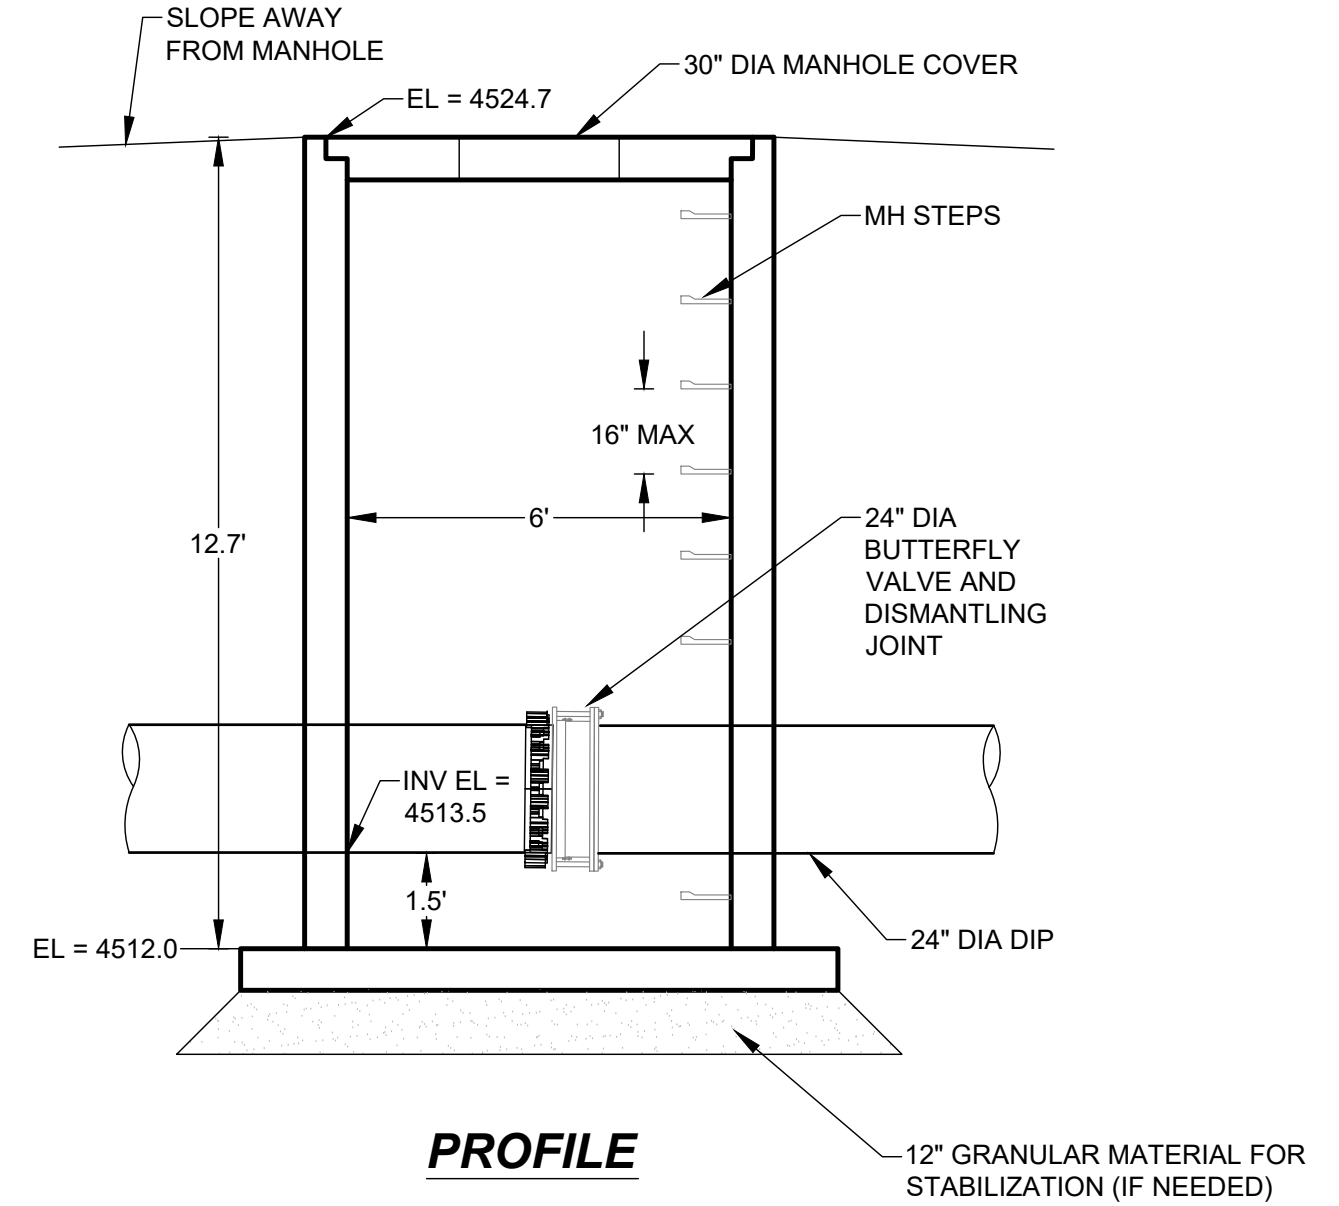

PROFILE

FLOW METER MANHOLE DETAILS

4/6


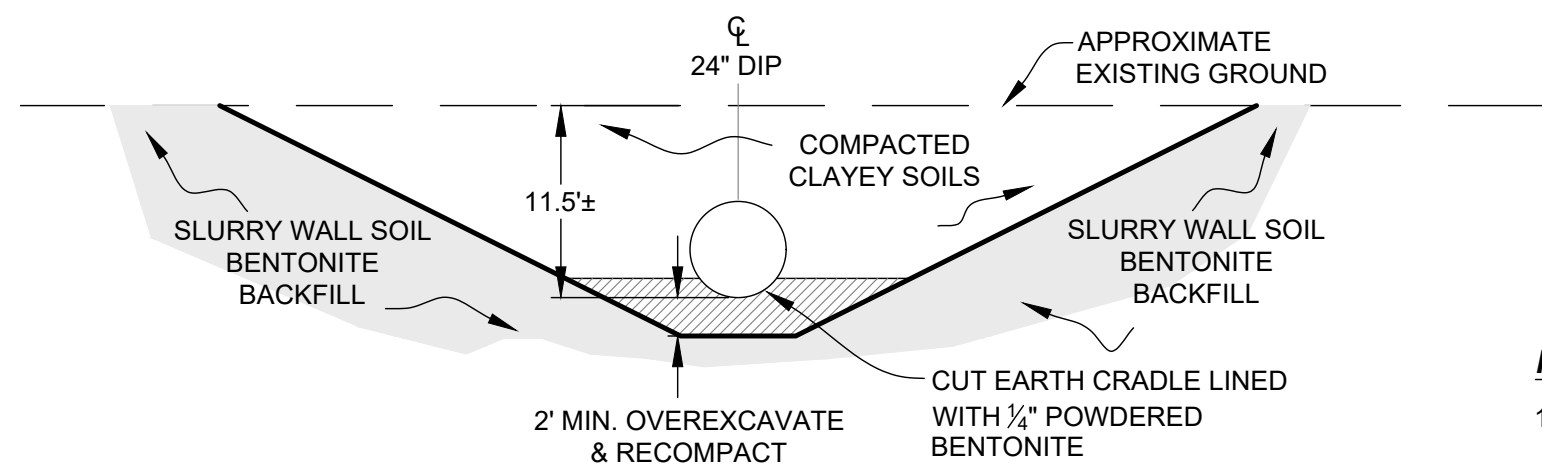


SECTION

NOTE:

1. CLAY BACKFILL FOR SLURRY WALL CROSSING SHALL HAVE A MINIMUM PI OF 12 AND A MINIMUM OF 30% PASSING THE -200 SIEVE.


 
SLURRY WALL CROSSING DETAIL

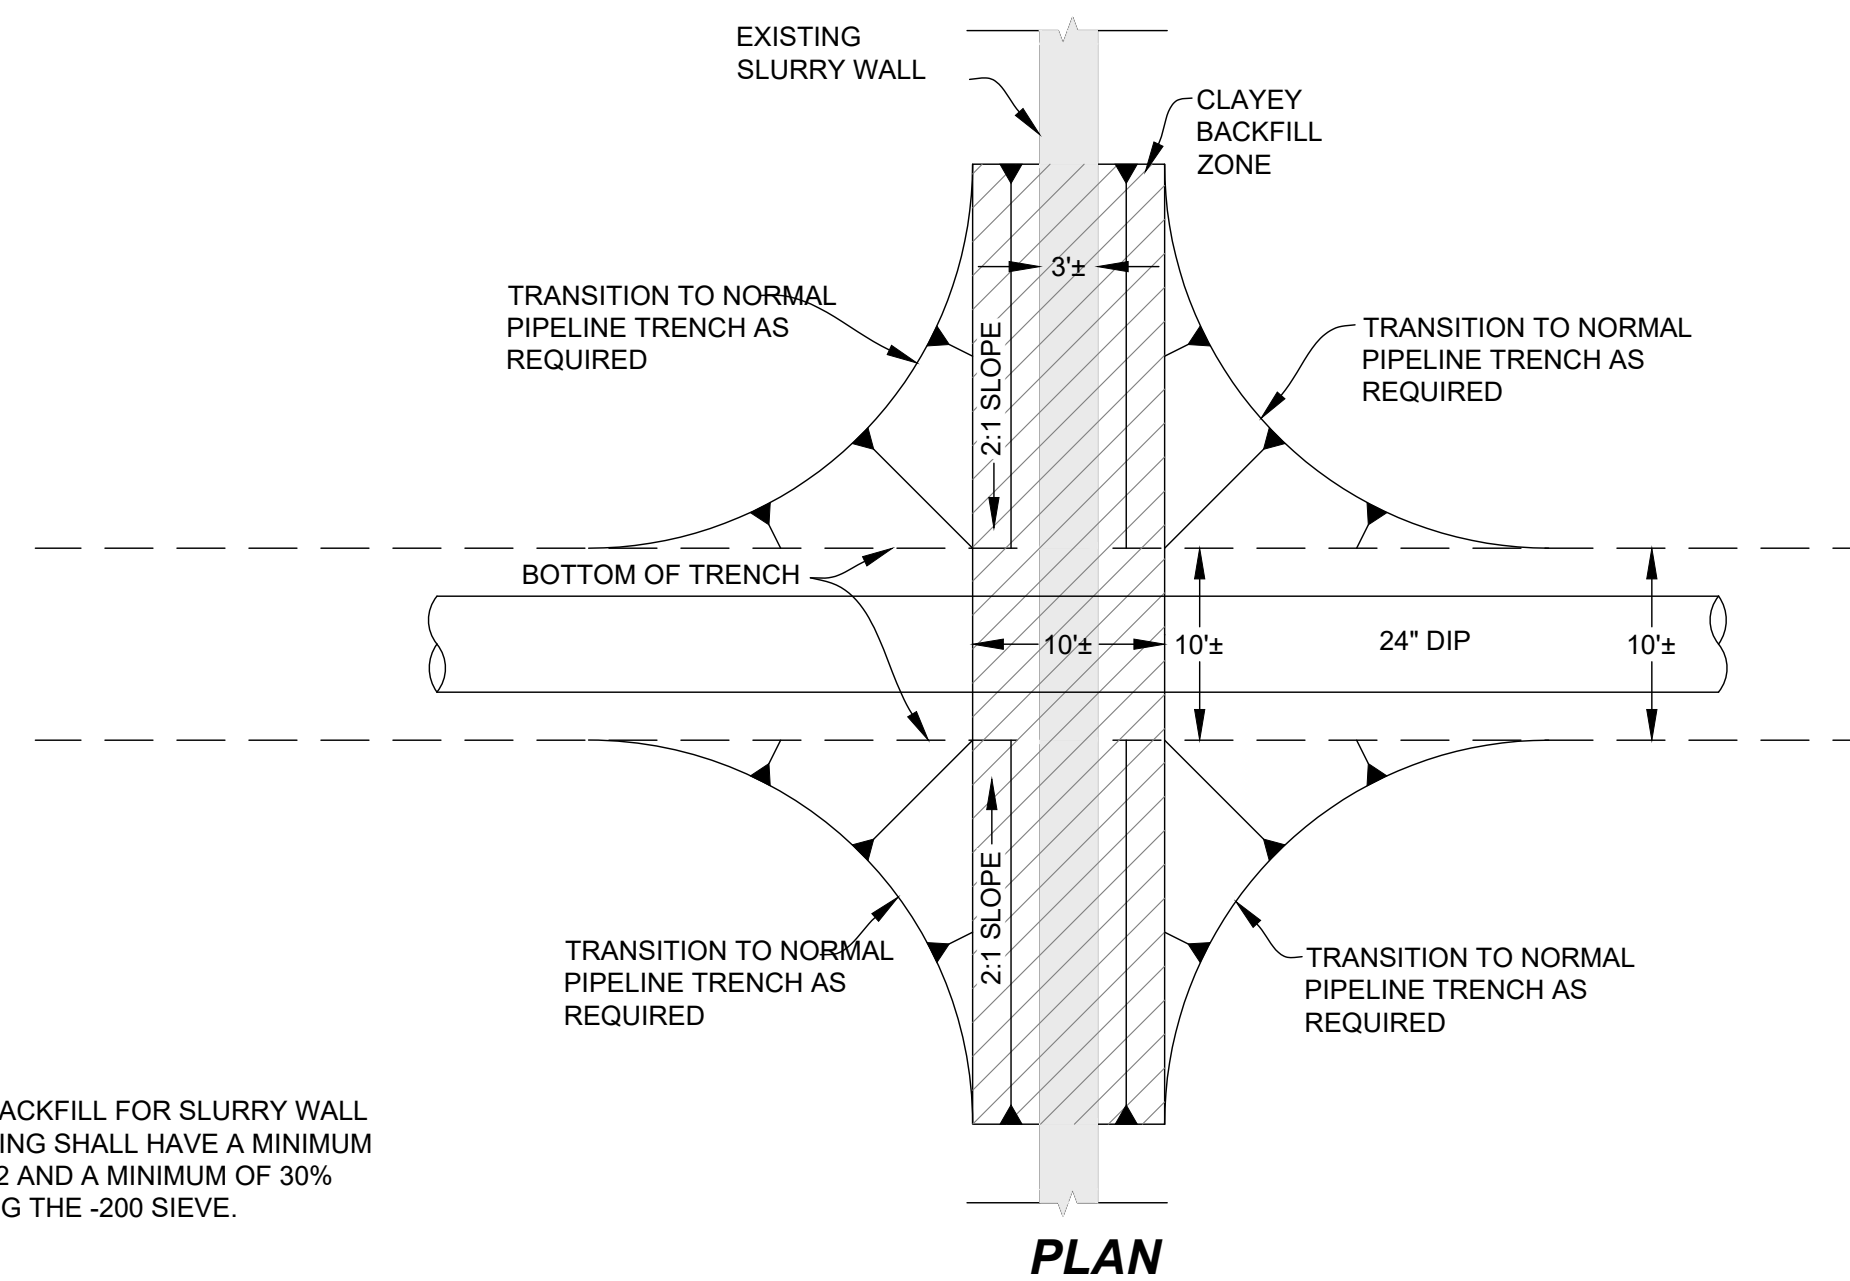


PLAN

SEO CONSTRUCTION FILE NO. -----				SOUTH RESERVOIR PUMPING FACILITIES & DISCHARGE			
REVISIONS				MISCELLANEOUS DETAILS			
NO.	DESCRIPTION	DATE	BY				
1	DRAFT	4-16-21	BAB				
2	FOR BID	11-12-21	BAB				
				DEERE & AULT		800 S. AIRPORT RD., BLDG. A, SUITE 205 LONGMONT, CO 80503 TEL. 303.651.1468 FAX. 303.651.1469	
				A SCHNABEL ENGINEERING COMPANY			
				DESIGNED BY: BAB	APPROVED BY: GGC	JOB NO.	SHEET:
				DRAWN BY: HOG	DATE: 4/15/21	20C26014.02	12
				CHECKED BY: MAS	SCALE: AS NOTED		



Friday, November 12, 2021 3:45:54 PM DRAWING: G:\2020\Longmont\20C26014.02 Temporary Outlet - Pump Facility\03_SE_Products\08-CAD\04-CONTRACT_DWG\SPPE Pipeline Profiles.DWG

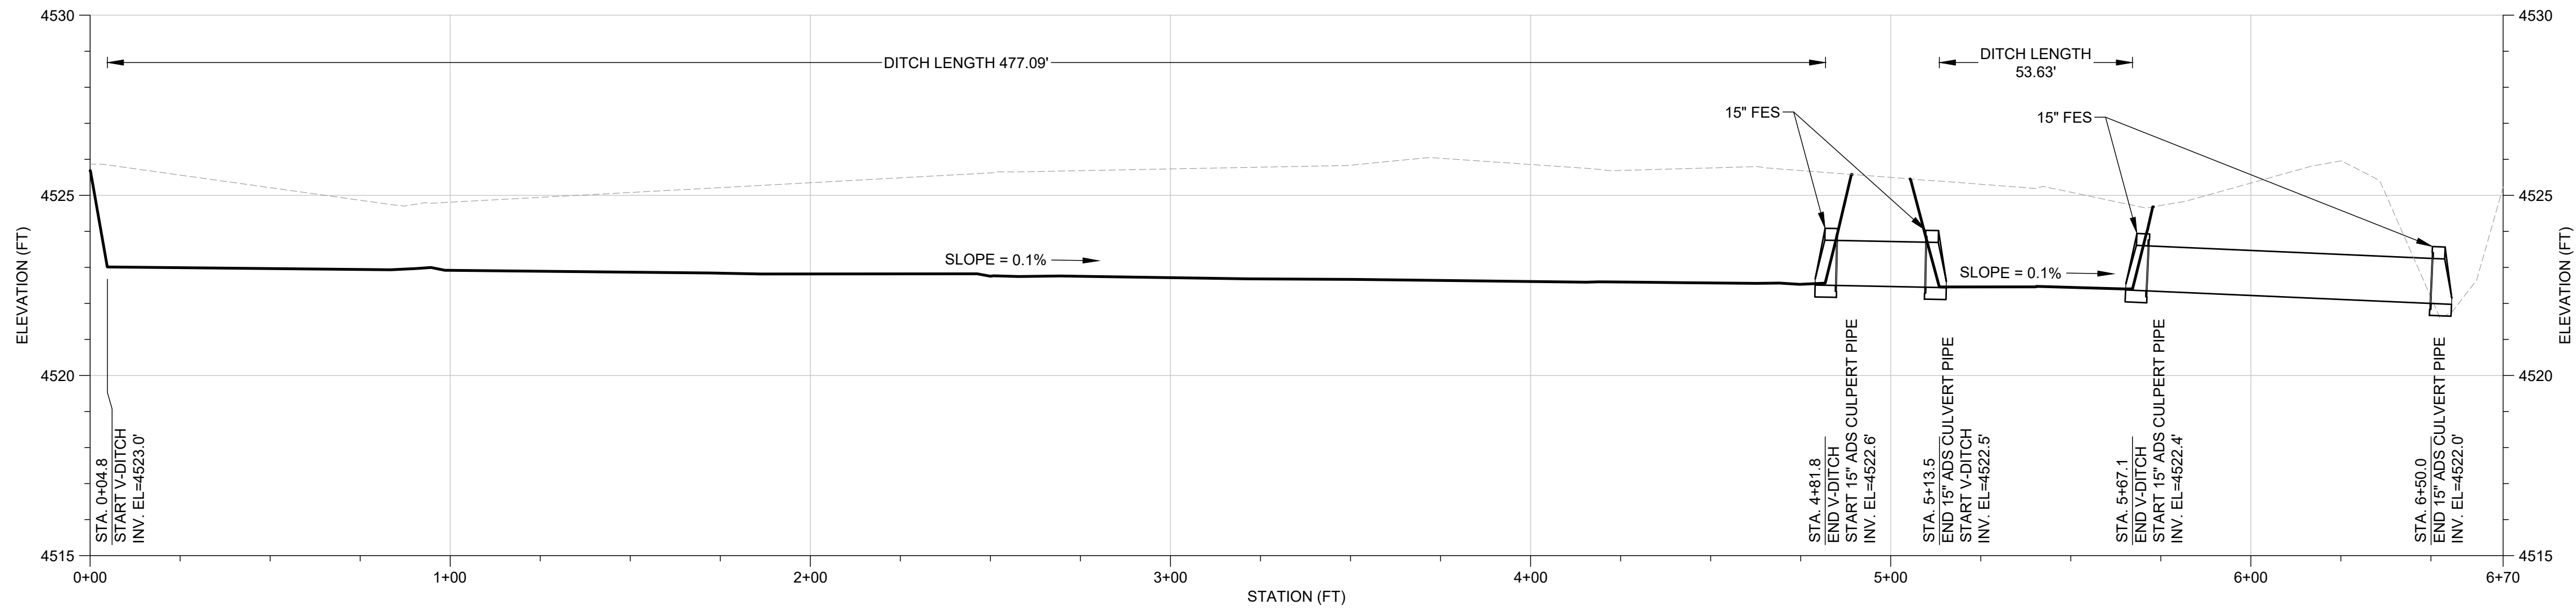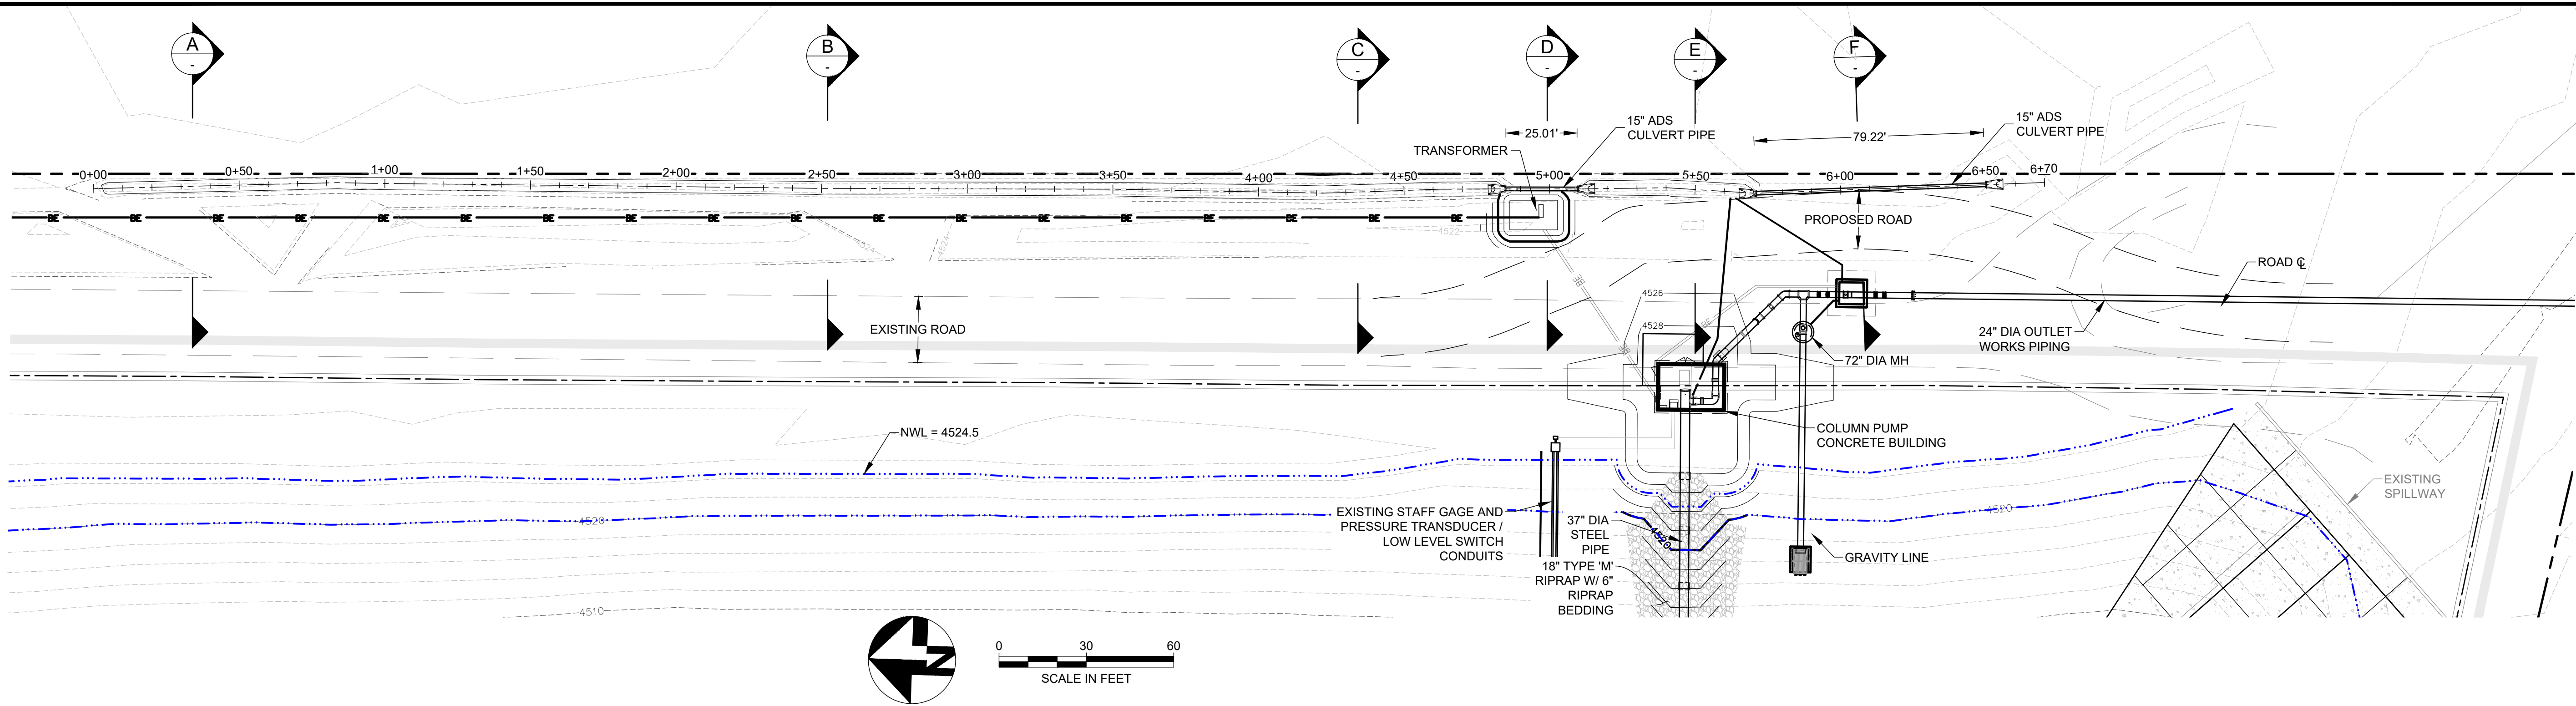



PROFILE

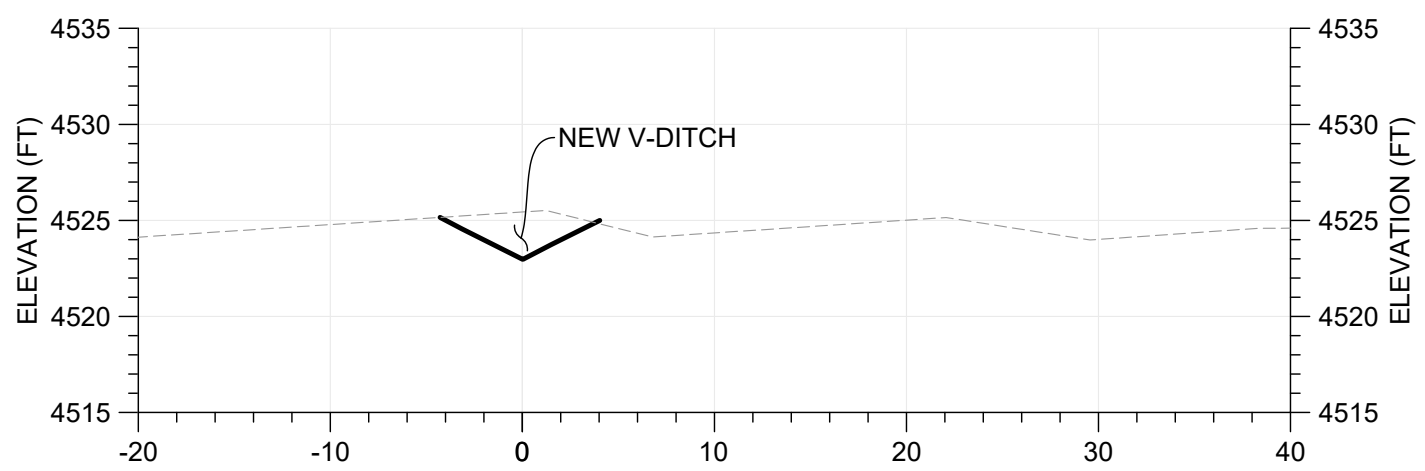



SECTION A

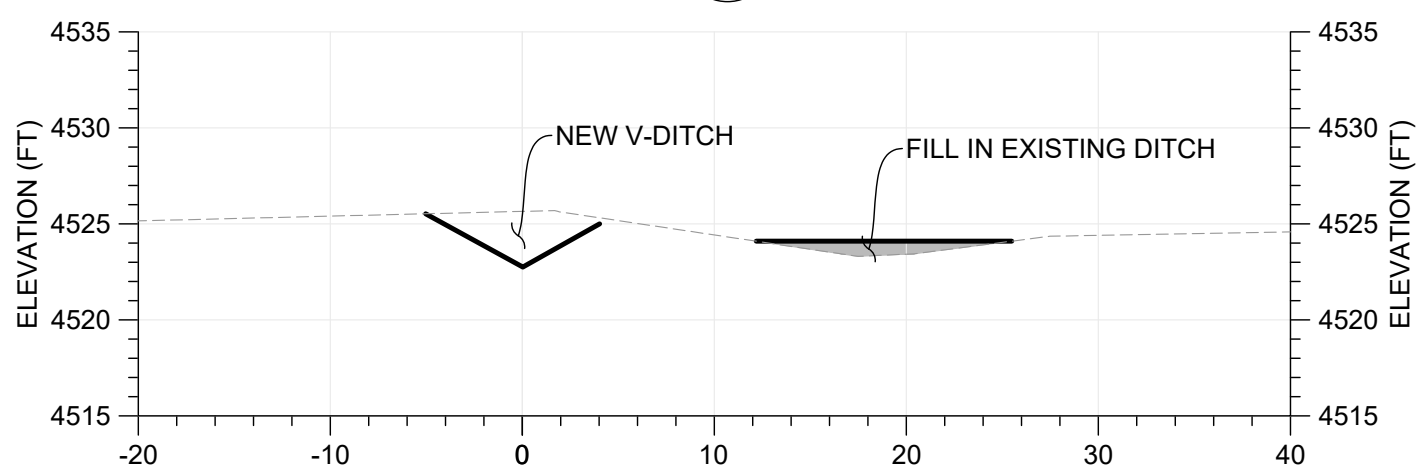 



SECTION B

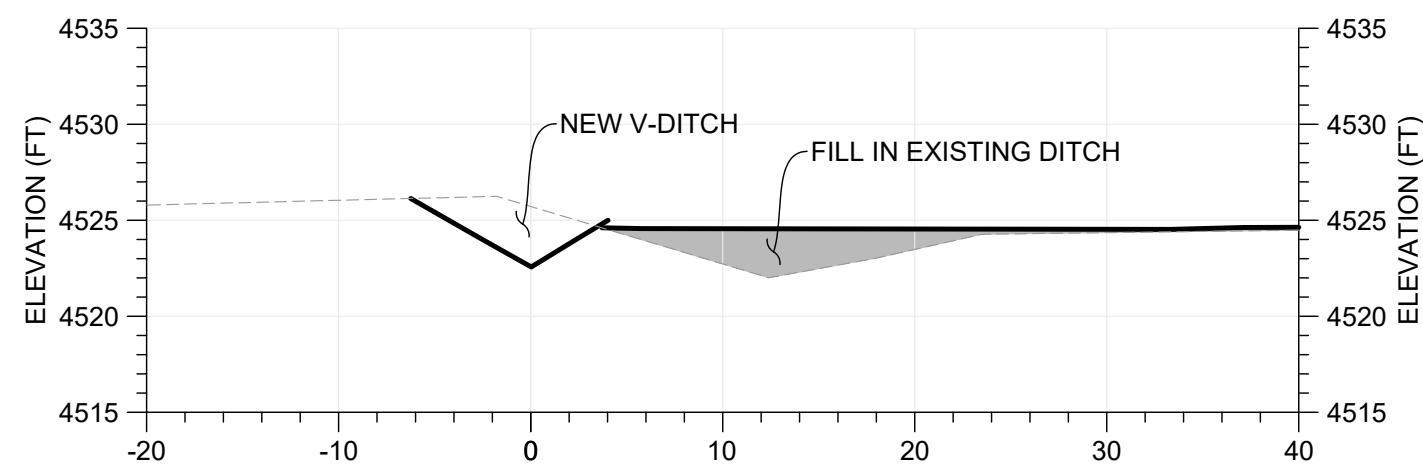 



SECTION C

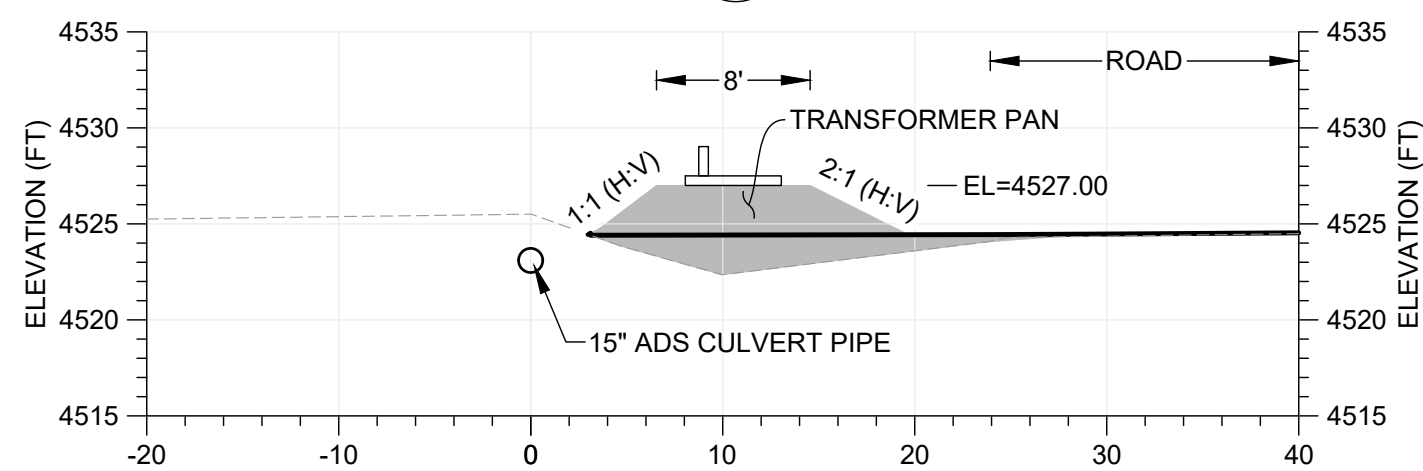 



SECTION D

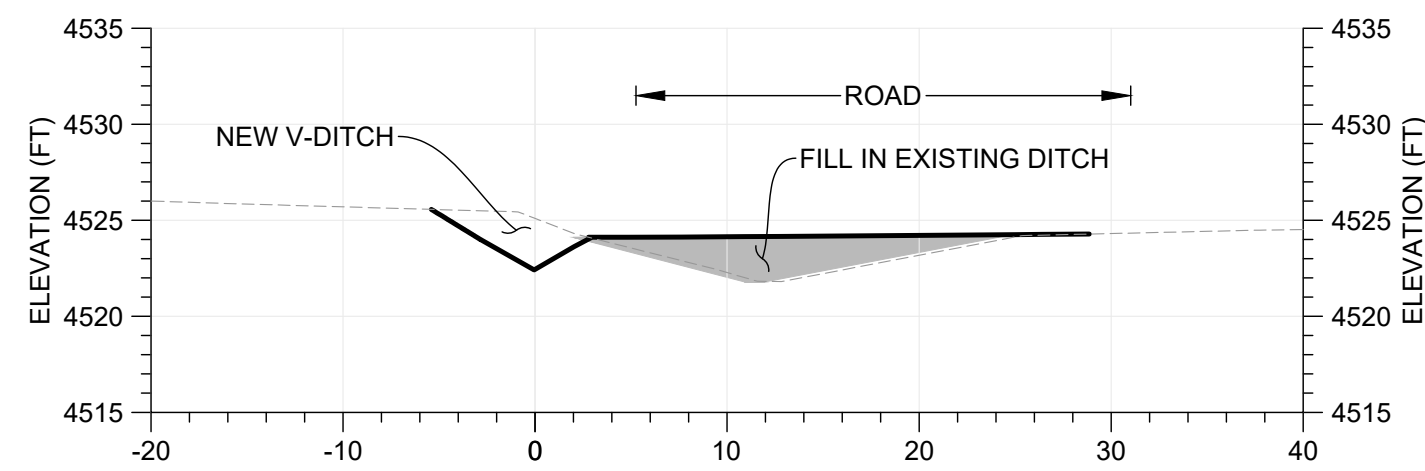 


SECTION E

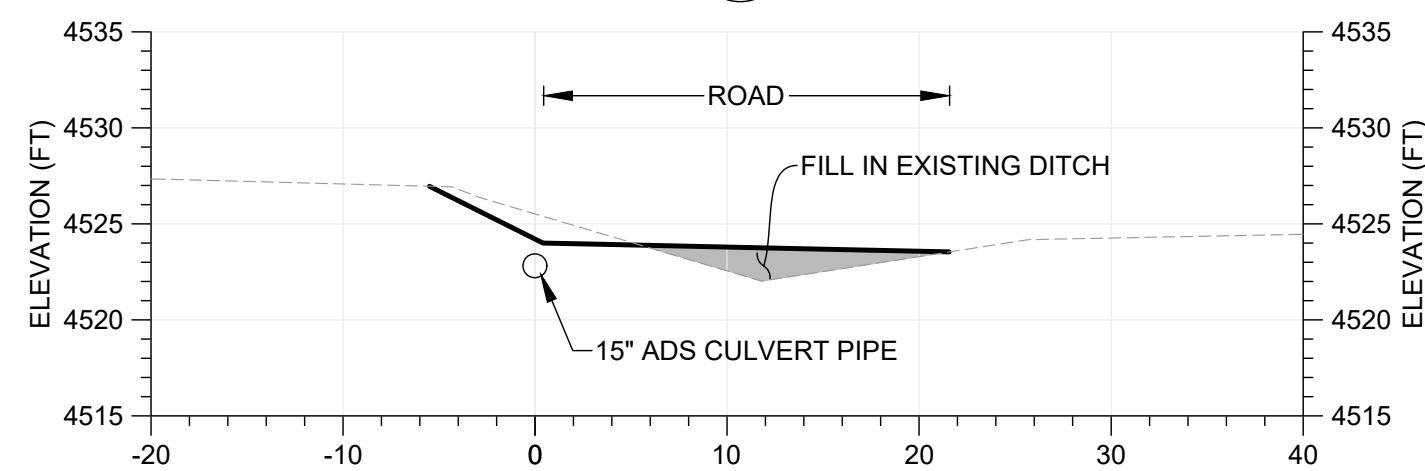 

SECTION F

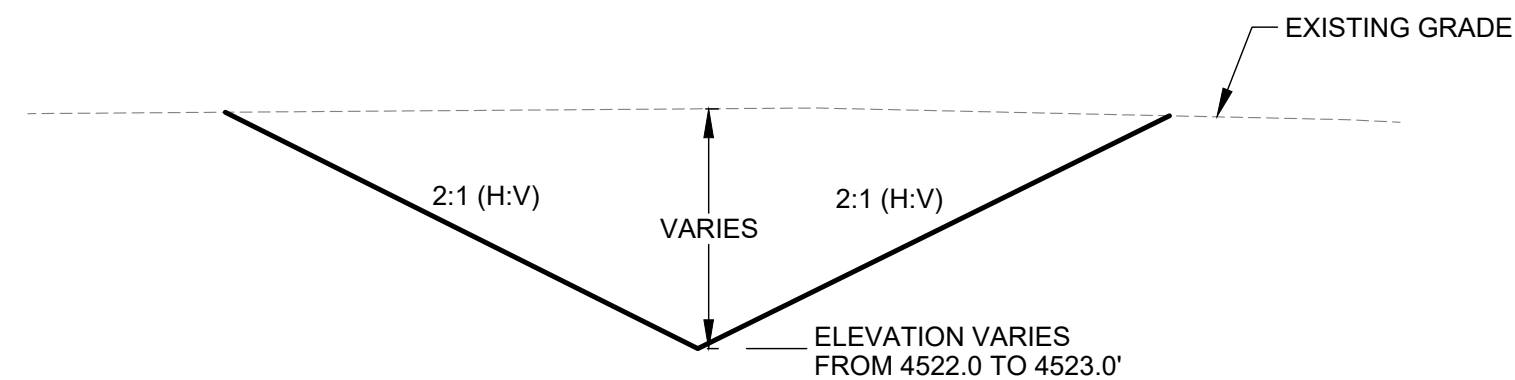 

TYPICAL V-NOTCH DETAIL

 

SEO CONSTRUCTION FILE NO.				SOUTH RESERVOIR PUMPING FACILITIES & DISCHARGE			

REVISIONS				ROAD FILL & DITCH PLAN			
NO.	DESCRIPTION	DATE	BY				
1	DRAFT	4-16-21	BAB				
2	FOR BID	11-12-21	BAB				
				DEERE & AULT		600 S. AIRPORT RD., BLDG. A, SUITE 205 LONGMONT, CO 80503 TEL 303.651.1468 FAX 303.651.1469	
				A SCHAFFEL ENGINEERING COMPANY			
				DESIGNED BY: BAB	APPROVED BY: GGC	JOB NO.	SHEET:
				DRAWN BY: HOG	DATE: 4/15/21	20C26014.02	13
				CHECKED BY: MAS	SCALE: AS NOTED		

DESIGN CRITERIA

Maximum Pumping Flowrate (Out)	30 CFS	cfs
Minimum Reservoir Elevation	4520	ft
Maximum Reservoir Elevation (HWL)	4090	ft
Reservoir Pumping Elevation (Min.)	4498	ft

PUMP SCHEDULE (SUPPLIED BY OWNER)

No.	Name	Location	Service	Type	Flow CFS	TDH (feet)	RPM (motor/pump)	HP	Voltage/ Phase	Remarks
P-1	Pump 1	South Reservoir	Reservoir water	Submersible	13-30	23-46	700-880	200	3	Pump Provided By Owner

EQUIPMENT SCHEDULE


No.	Name	Service	Voltage/ Phase	Size	Type	Rated Pressure	Operator	Remarks,
M-1	Water Flow Meter	Reservoir water	TBD	24" Dia	Flanged Magnetic Flow Meter	150 psi		Rosemount 8750 (Flanged) By Owner

VALVE AND GATE SCHEDULE

Valves and Gates								
No.	Name	Service	Size	Type	Rated Pressure	Operator	Manufacturers	Comments
V-1	Air/Vac #1	Reservoir Water	2" Dia	Combination Air Release / Vacuum	150 psi	Float	APCO 145C w/ 8 Mils 2 Part NSF Epoxy (Interior & Exterior) or Approved Equal	Per Detail Sheet 12
V-2	Air/Vac #2	Reservoir Water	3" Dia	Combination Air Release / Vacuum	150 psi	Float	APCO 147C w/ 8 Mils 2 Part NSF Epoxy (Interior & Exterior) or Approved Equal	Per Detail Sheet 12
V-3	Pump Line Isolation Valve	Reservoir Water	24" Dia	Ground Hog Butterfly Valve	150 psi	Valve Box/Nut		
V-4	Gravity Control Valve	Reservoir Water	24" Dia	Butterfly Valve	150 psi	Gear & Handwheel	DeZurik BAW Class 150B (Flanged) w/ 8 Mils 2 Part NSF Epoxy (Interior & Exterior) or Approved Equal	
V-5	Gravity Line Check Valve	Reservoir Water	24" Dia	Check Valve		NA	Tideflex Series 35	

PIPING MATERIAL SCHEDULE

MATERIAL	SIZE	PIPE CLASS	LINING	COATING	END CONNECTIONS
WELDED STEEL AWWA C200 COATED & LINED	24" ID	5/16" WALL THICKNESS	20 MILS OF POTA POX PLUS COLOR : WHITE (11WH)	20 MILS OF POTA POX PLUS COLOR : DELFT BLUE (39BL) 5.5 MILS OF ENDURA SHIELD II TOP COAT (UV EXPOSED PIPE)	CLASS D FLANGE
DUCTILE IRON PIPE	24"	PRESSURE CLASS 200	MORTAR LINED 3/16"	ASPHALT COATING: 1 MIL.	MECHANICAL JOINTS W/ EBBA IRON SIZE 1100 MEGELUG
HDPE (DIP SIZE)	24"	DR17	NA	NA	FUSE WELDED JOINTS

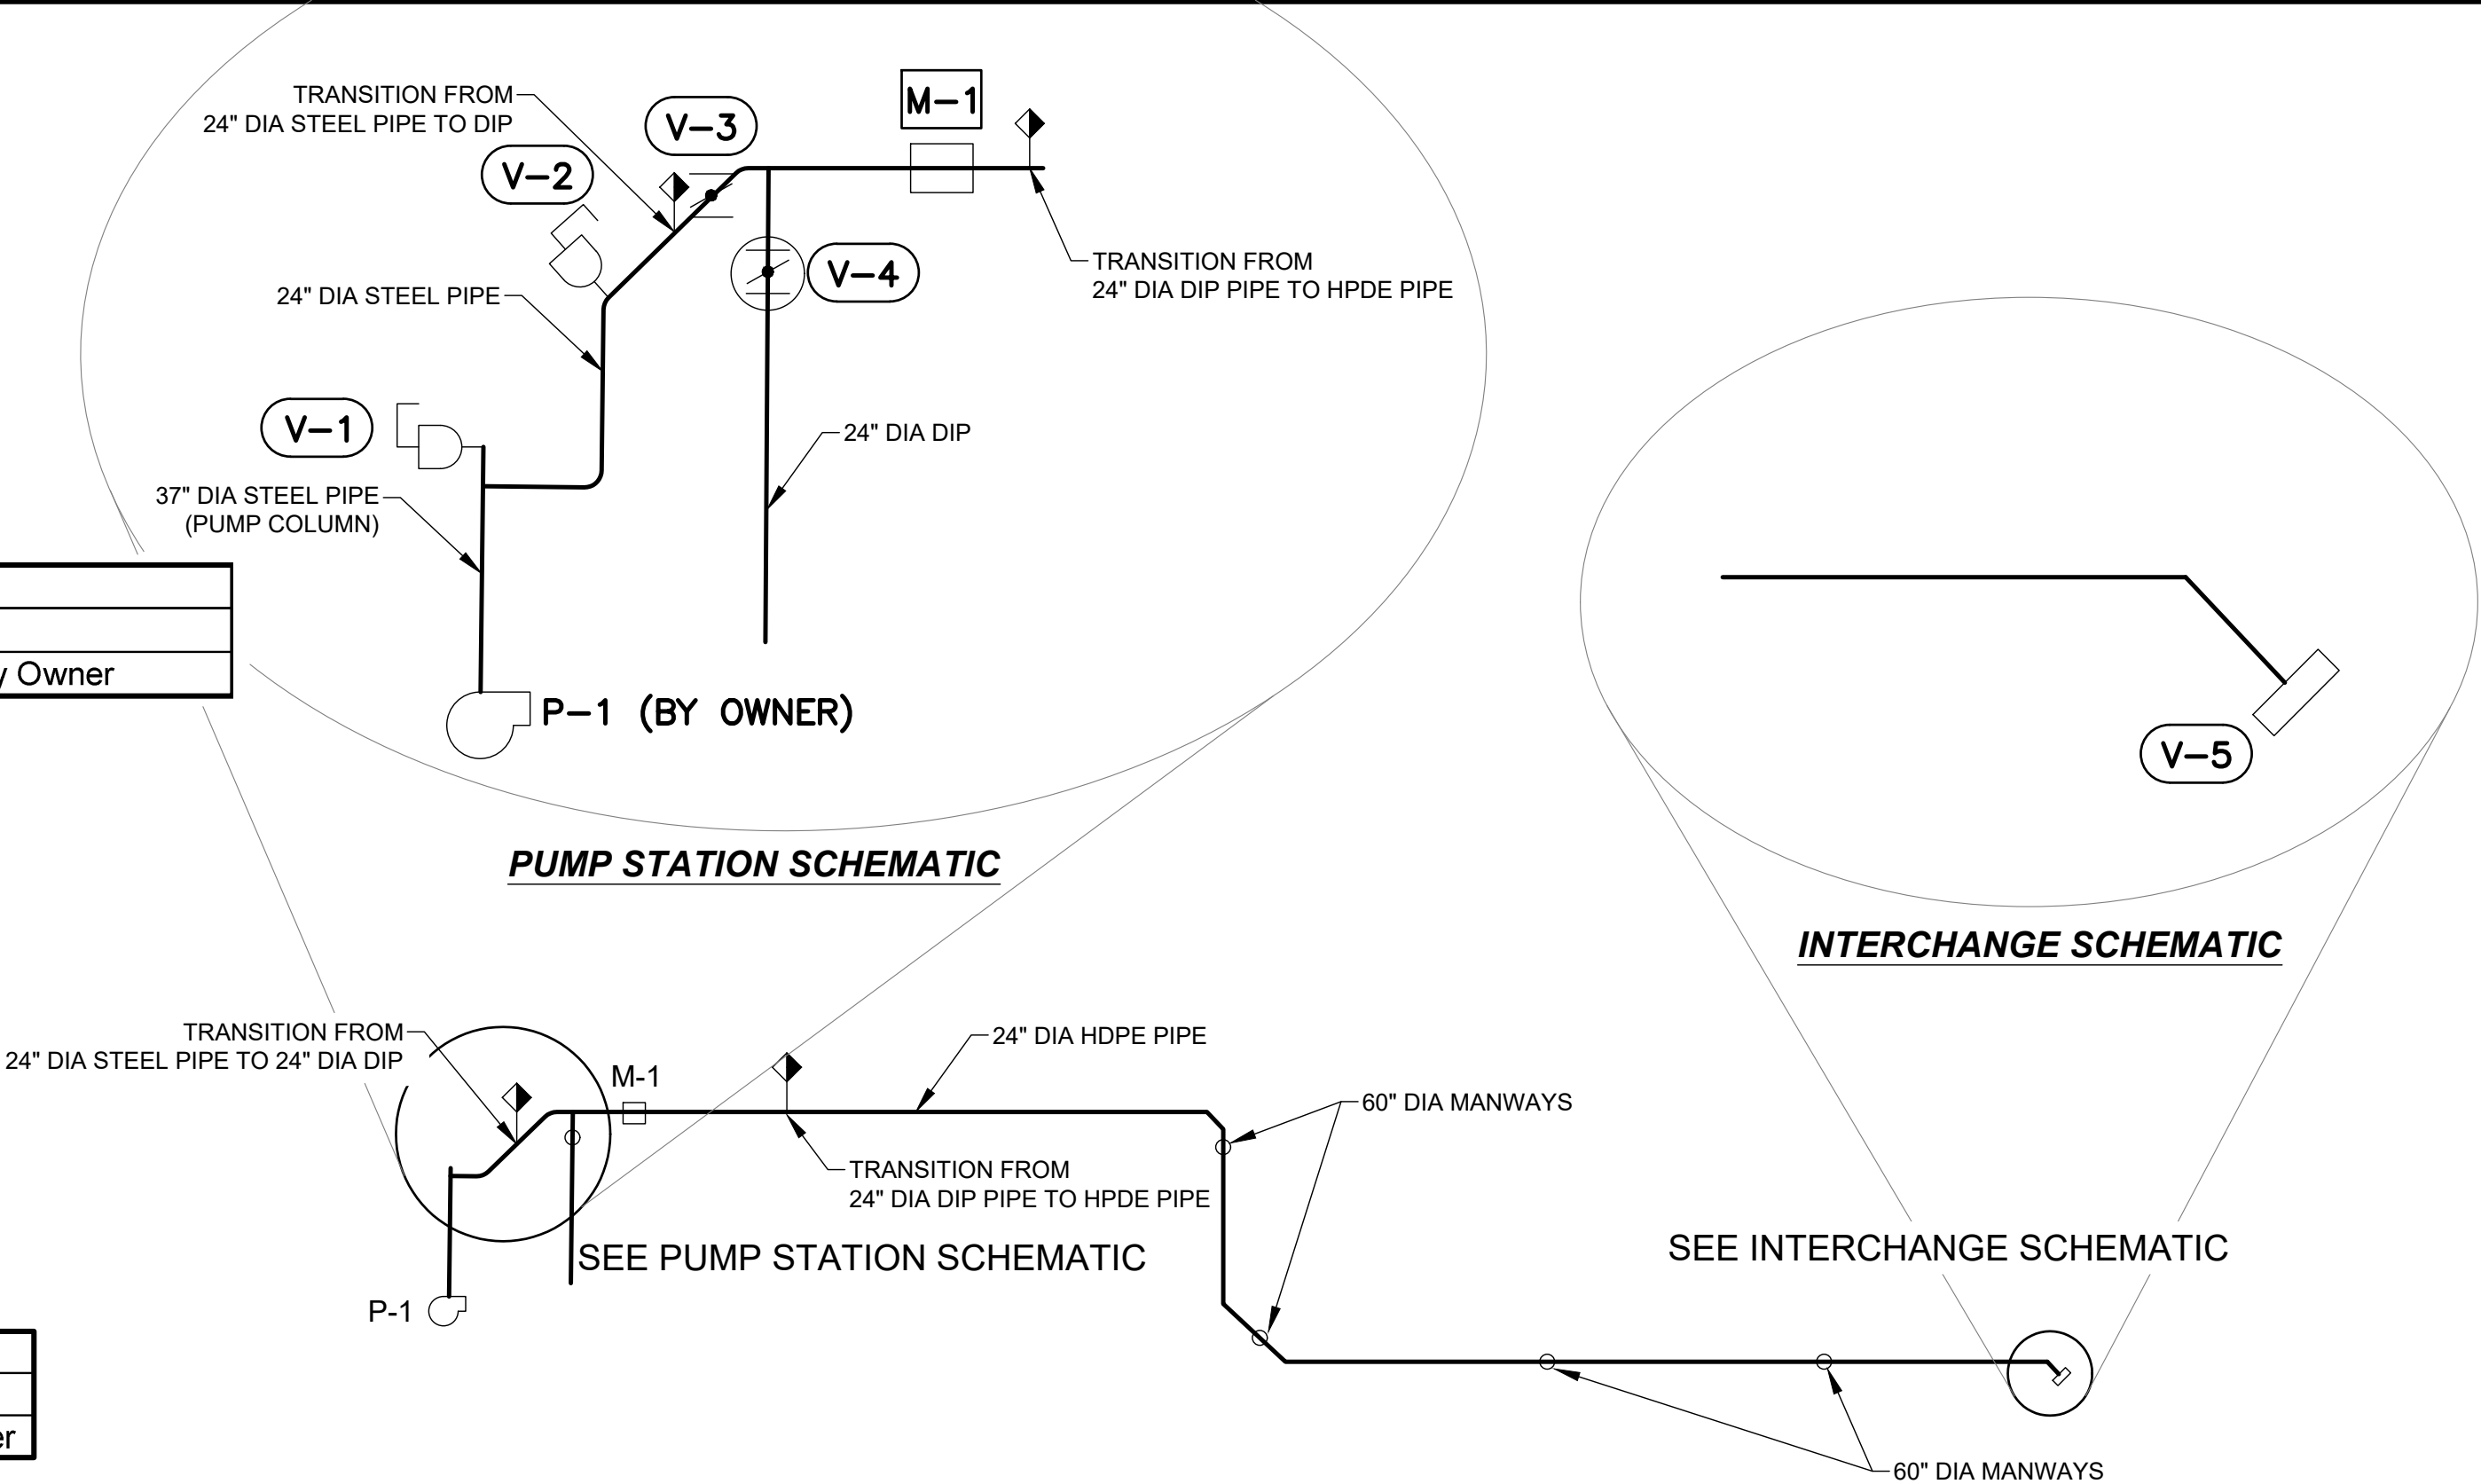

Friday, November 12, 2021 3:45:59 PM DRAWING: G:\2020\Longmont\20C26014.02 Temporary Outlet - Pump Facility\03_SE_Products\08-24D_04-CONTRACT_DWG\SPF_PIPE & VALVE SCHEDULES.DWG

REVISIONS			
NO.	DESCRIPTION	DATE	BY
1	DRAFT	4-16-21	BAB
2	FOR BID	11-12-21	BAB

SOUTH RESERVOIR PUMPING FACILITIES & DISCHARGE

PIPE & VALVE SCHEDULE

DESIGNED BY: **BAB**

APPROVED BY: **GGC**

DRAWN BY: **_HOG**

DATE: **4/15/21**

CHECKED BY: **_MAS**

SCALE: **AS NOTED**

DEERE & AULT
A SCHWABER ENGINEERING COMPANY

600 S. AIRPORT RD., BLDG. A, SUITE 205
LONGMONT, CO 80503
TEL 303.651.1468 FAX 303.651.1469

JOB NO. **20C26014.02**

SHEET: **14**