


September 24, 2018

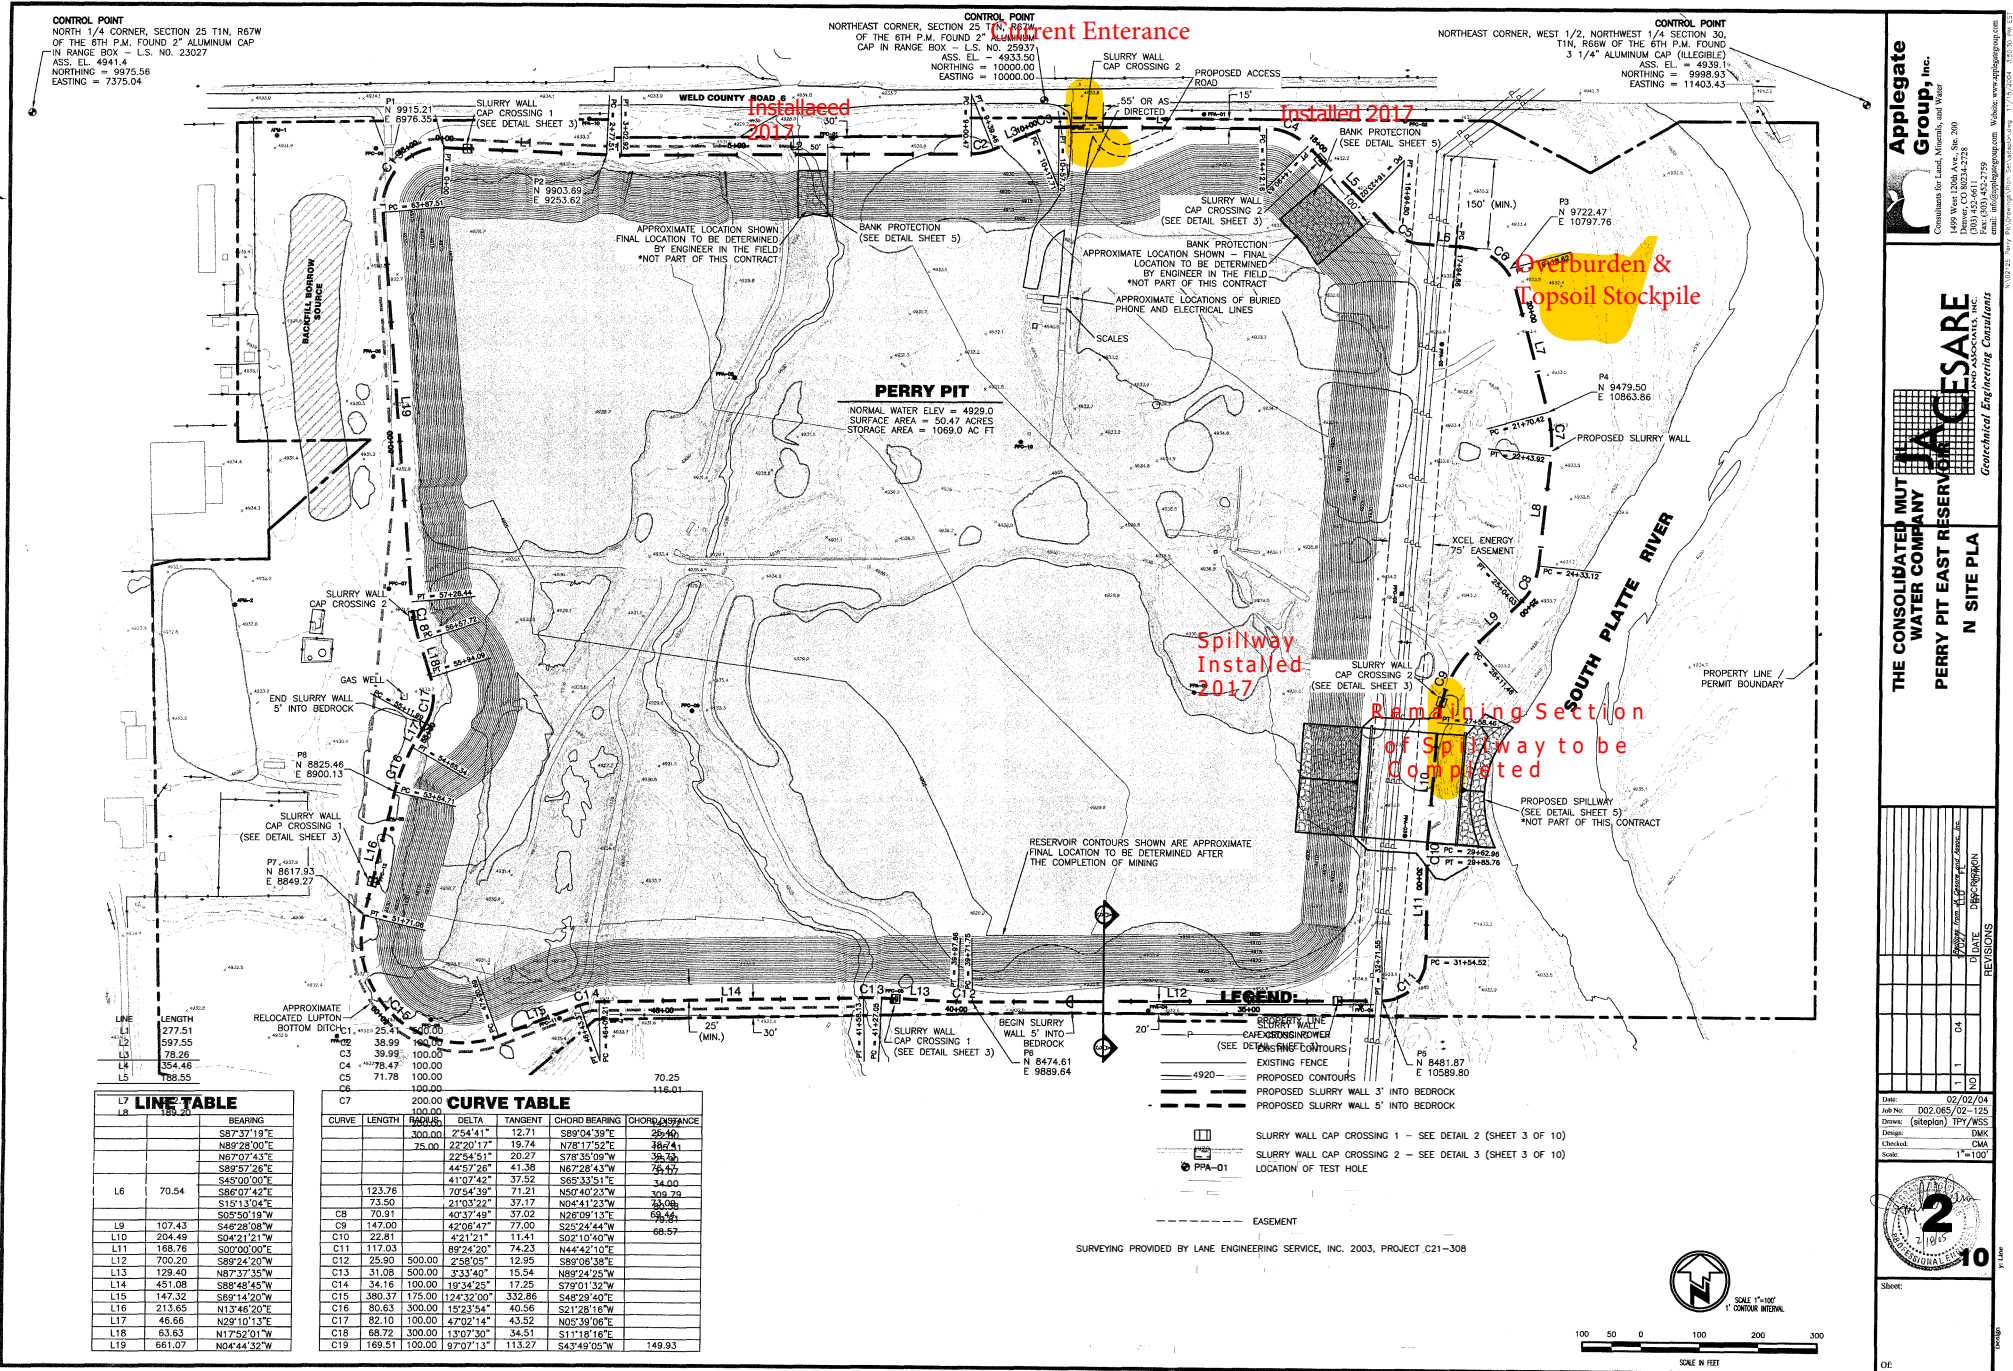

Applegate Group, Inc.
Consultants for Land, Mineral, and Water
1499 West 120th Ave., Ste. 200
Bloomington, MN 55424-2228
Tel: (612) 452-2759
Fax: (612) 452-2759
Web: www.applegategroup.com

THE CONSOLIDATED MUTUAL WATER COMPANY
PERRY PIT EAST RESERVOIR
N SITE PLAN

JACQUES
Geotechnical Engineering Consultants

DATE: 02/02/04
JOB NO: 002.065/02-125
DESIGN: (signature) TPY/MS
CHECKED: CMA
SCALE: 1"=100'

2

10

SCALE IN FEET
100 50 0 100 200 300