


**NO CONSTRUCTION AS OF 7/19/19
WAITING ON FINAL RECORDING
WITH WELD COUNTY**



- LEGEND:**
- EXISTING PROPERTY BOUNDARY
 - G- EXISTING XCEL & KERR MCGEE / ANADARKO GAS
 - E- EXISTING UNITED POWER ELECTRIC
 - T- EXISTING CENTURYLINK TELEPHONE
 - OE- EXISTING UNITED POWER OVERHEAD ELECTRIC
 - - - EXISTING EASEMENT
 - - - MINING LIMIT
 - - - SLURRY WALL
 - - - PERMIT BOUNDARY

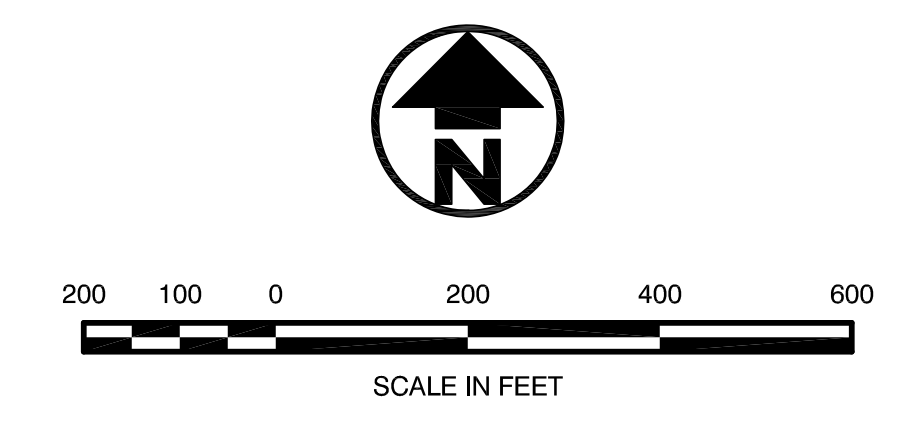

J&T Consulting, Inc.
 305 N Denver Avenue - Suite D
 Fort Lupton, CO 80621
 Ph: 303-867-6222 Fax: 303-867-6224
 www.jtconsulting.com

Bennett Gravel Pit
 Lighting Plan

Northern Colorado Constructors, Inc.
M-2016-085

REVISIONS		No.	Date	By	Chk	Description

Job # 16116
 Date 1.8.19
 Drawn By WSS
 Designed By TPY
 Checked By JCY
 File JT-Dust control
 Scale 1" = 200'
 Sheet: 1 of 1

P:\16116 Bennett Mine Permitting\Drawings\Plan Sheets\UT Lighting Plan.dwg, LIGHT, 1/8/2019 8:36:45 AM