

LEGEND:

---	EXISTING PROPERTY BOUNDARY
-G-	EXISTING XCEL & KERR MCGEE / ANADARKO GAS
-E-	EXISTING UNITED POWER ELECTRIC
-T-	EXISTING CENTURYLINK TELEPHONE
-OE-	EXISTING UNITED POWER OVERHEAD ELECTRIC
---	EXISTING EASEMENT
---	MINING LIMIT
---	SLURRY WALL
---	PERMIT BOUNDARY

Weed Control -
 - Application Date: May/June 2020
 - 2% Landmaster and Polaris to Treat
 the following:
 - Canadian Thistle
 - Koshia
 - Scotch Thistle
 - Knapp Weed
 - Downy Brome


J&T Consulting, Inc.
 305 N Denver Avenue - Suite D
 Fort Lupton, CO 80621
 Ph: 303-867-6222 Fax: 303-867-6224
 www.jtconsulting.com

Bennett Gravel Pit
 Lighting Plan

Northern Colorado Constructors, Inc.
 M-2016-085

REVISIONS		Description	
No.	Date	By	Chk

Job # 16116
 Date 1.8.19
 Drawn By WSS
 Designed By TPY
 Checked By JCY
 File JT-Dust control
 Scale 1" = 200'
 Sheet: 1 of 1

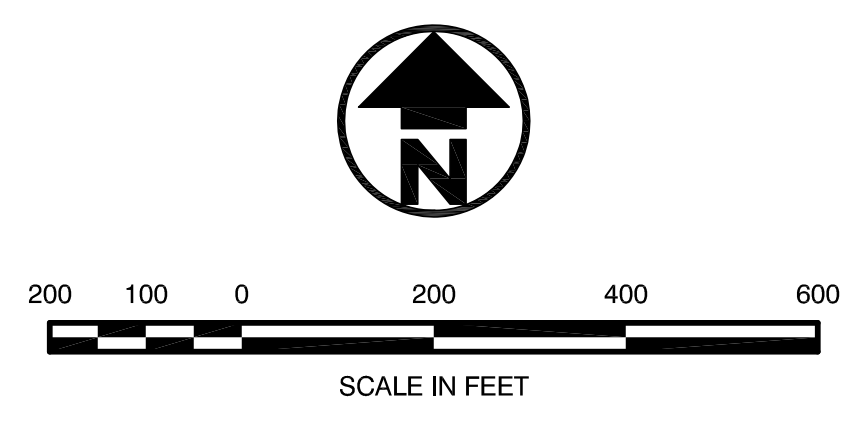

P:\16116 Bennett Mine Permitting\Drawings\Plan Sheets\UT Lighting Plan.dwg, LIGHT, 1/8/2019 8:36:45 AM