



- NOTES:
- PERFORATED PVC DRAIN PIPE FILTER PACK/BEDDING SHALL BE CONSTRUCTED WITH ASTM C33 No. 8 AGGREGATE WITH 6" MIN. THICKNESS ON ALL SIDES WRAPPED WITH MIRIFI FILTER FABRIC AROUND EXTERIOR OF THE ASTM C33 No. 8 AGGREGATE.
 - SOLID PVC PIPE BEDDED SHALL CONSIST OF 6" MIN. THICKNESS ASTM C33 No. 8 AGGREGATE.

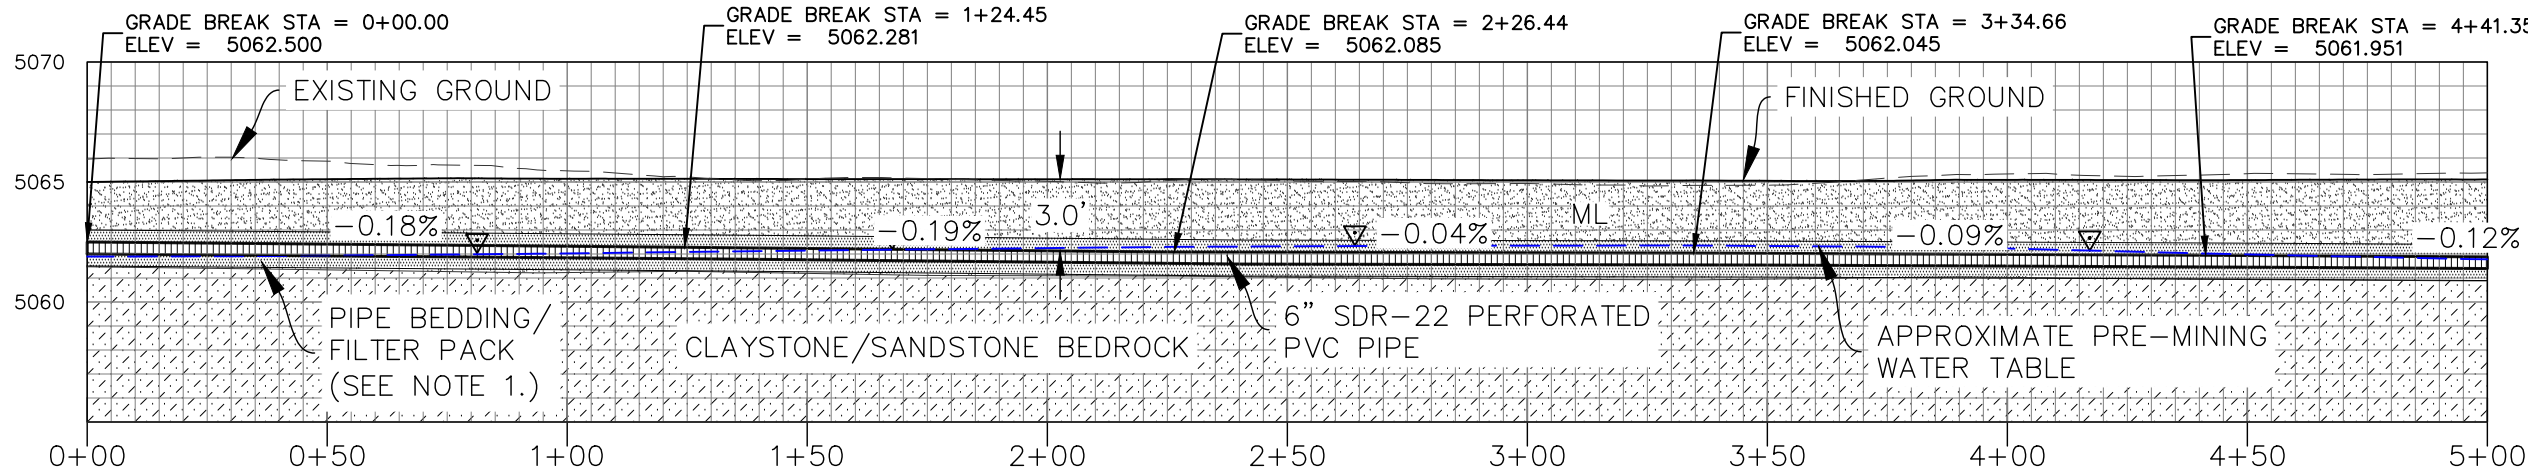

REVISIONS				OWNER		CONTRACTOR					PROJECT			SHEET	
REV	DESCRIPTION	DATE	APPROVED	CITY OF LAFAYETTE		ROCK PRODUCTS OF COLORADO L.L.C. P.O. BOX 893 BROOMFIELD, CO 80038		DESIGNED PFW	CHECKED KR	DRAWN PFW	GOOSE HAVEN RESERVOIRS COMPLEX EXPANSION #2, #4 – EXHIBIT G UNDERDRAIN PLAN AND PROFILE		C-2		
			DRAWING NO. 2 OF 7												
			REVISION 0												
			SCALE V: 1"=8', H: 1"=40'												
				CAD FILE NAME EXHIBIT G C2_C7.DWG	PLOT DATE 10/5/22	APPROVED		DATE		CONTRACT		DATE October 5, 2022		W.I. JOB	