



NOTES:
1. PERFORATED PVC DRAIN PIPE FILTER PACK/BEDDING SHALL BE CONSTRUCTED WITH ASTM C33 No. 8 AGGREGATE WITH 6" MIN. THICKNESS ON ALL SIDES WRAPPED WITH MIRIFI FILTER FABRIC AROUND EXTERIOR OF THE ASTM C33 No. 8 AGGREGATE.
2. SOLID PVC PIPE BEDDED SHALL CONSIST OF 6" MIN. THICKNESS ASTM C33 No. 8 AGGREGATE.

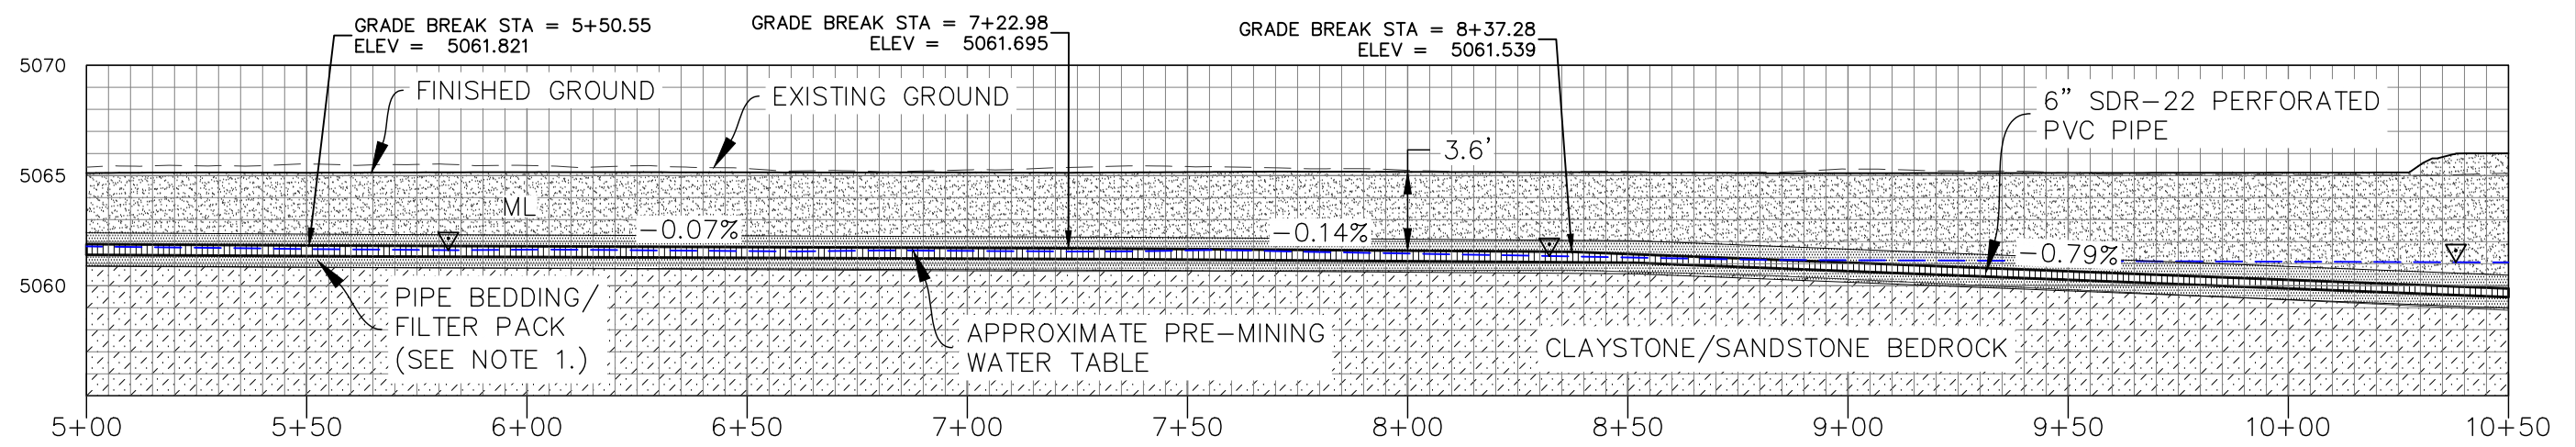

REVISIONS				OWNER CITY OF LAFAYETTE	CONTRACTOR ROCK PRODUCTS OF COLORADO L.L.C. P.O. BOX 893 BROOMFIELD, CO 80038	 GOOSE HAVEN RESERVOIRS COMPLEX EXPANSION #2, #4 – EXHIBIT G UNDERDRAIN PLAN AND PROFILE				SHEET C-3	
REV	DESCRIPTION	DATE	APPROVED							DRAWING NO. 3 OF 7	
										REVISION 0	
										SCALE V: 1"=8', H: 1"=40'	
CAD FILE NAME EXHIBIT G C2_C7.DWG		PLOT DATE 10/5/22		APPROVED	DATE	DESIGNED PFW	CHECKED KR	DRAWN PFW	CONTRACT	DATE October 5, 2022	W.I. JOB