



NOTES:  
1. PERFORATED PVC DRAIN PIPE FILTER PACK/BEDDING SHALL BE CONSTRUCTED WITH ASTM C33 No. 8 AGGREGATE WITH 6" MIN. THICKNESS ON ALL SIDES WRAPPED WITH MIRIFI FILTER FABRIC AROUND EXTERIOR OF THE ASTM C33 No. 8 AGGREGATE.  
2. SOLID PVC PIPE BEDDED SHALL CONSIST OF 6" MIN. THICKNESS ASTM C33 No. 8 AGGREGATE.

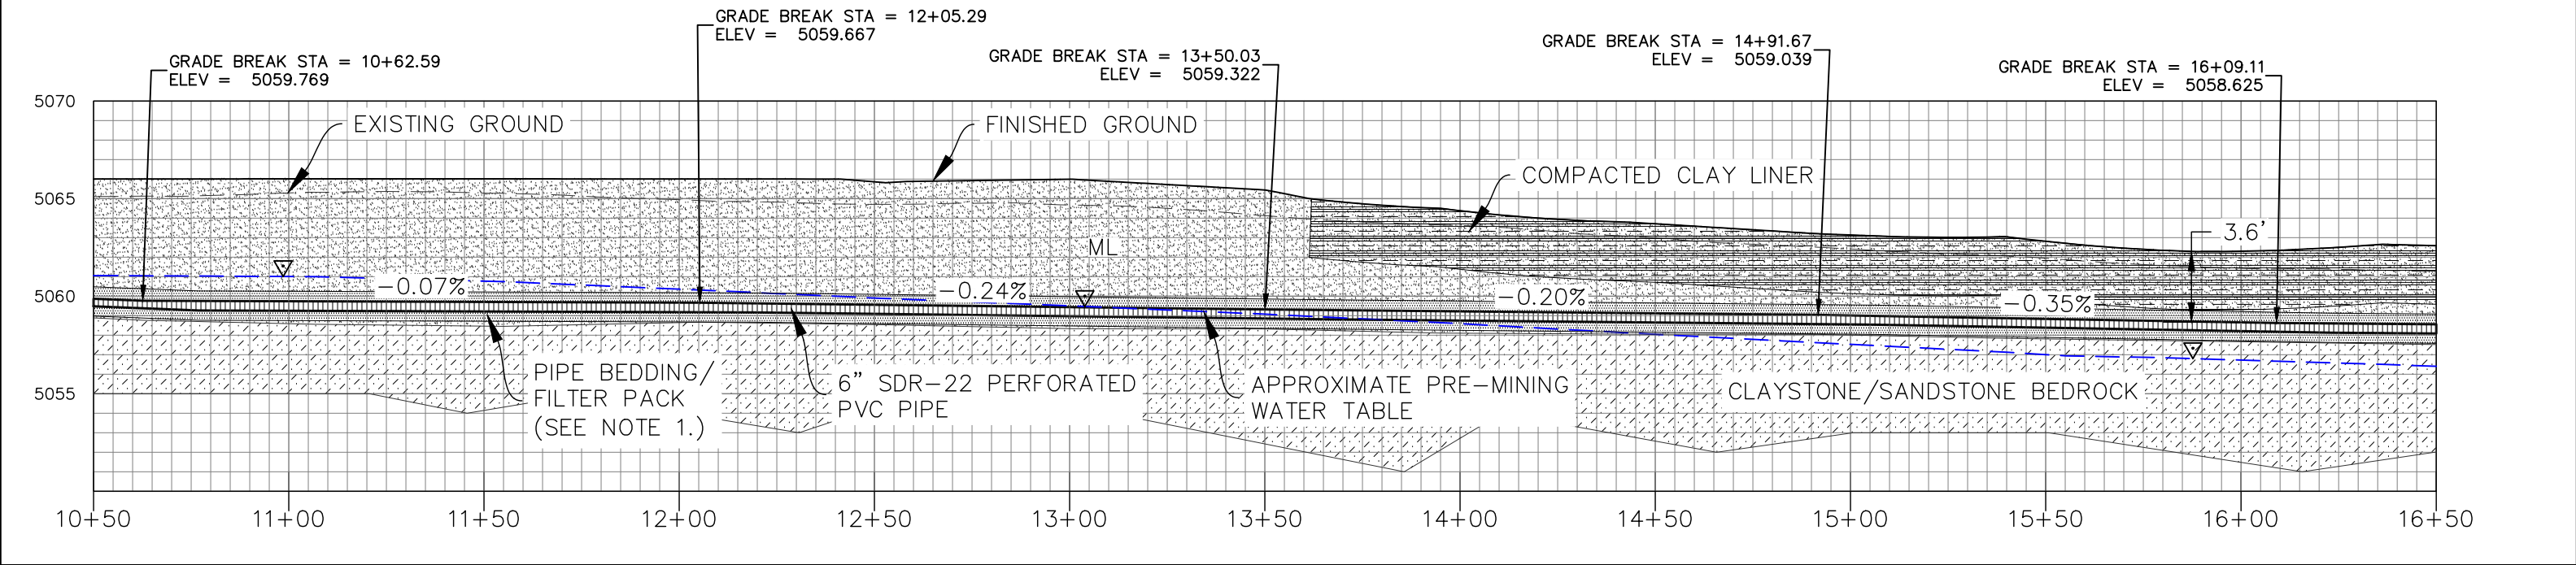

REVISIONS				OWNER  CITY OF LAFAYETTE		CONTRACTOR  ROCK PRODUCTS OF COLORADO L.L.C. P.O. BOX 893 BROOMFIELD, CO 80038		 Weiland, Inc. Environmental & Engineering PO BOX 18087 Boulder CO 80508 PH 303-443-9581			PROJECT  GOOSE HAVEN RESERVOIRS COMPLEX EXPANSION #2, #4 – EXHIBIT G UNDERDRAIN PLAN AND PROFILE			SHEET  C-4	
REV	DESCRIPTION	DATE	APPROVED											DRAWING NO. 4 OF 7	
														REVISION 0	
														SCALE V: 1"=8', H: 1"=40'	
CAD FILE NAME EXHIBIT G C2_C7.DWG		PLOT DATE 10/5/22		APPROVED		DATE		DESIGNED PFW	CHECKED KR	DRAWN PFW	CONTRACT		DATE October 5, 2022	W.I. JOB	