


NOTES:
1. PERFORATED PVC DRAIN PIPE FILTER PACK/BEDDING SHALL BE CONSTRUCTED WITH
ASTM C33 No. 8 AGGREGATE WITH 6" MIN. THICKNESS ON ALL SIDES WRAPPED WITH
MIRIFI FILTER FABRIC AROUND EXTERIOR OF THE ASTM C33 No. 8 AGGREGATE.
2. SOLID PVC PIPE BEDDED SHALL CONSIST OF 6" MIN. THICKNESS ASTM C33 No. 8
AGGREGATE.

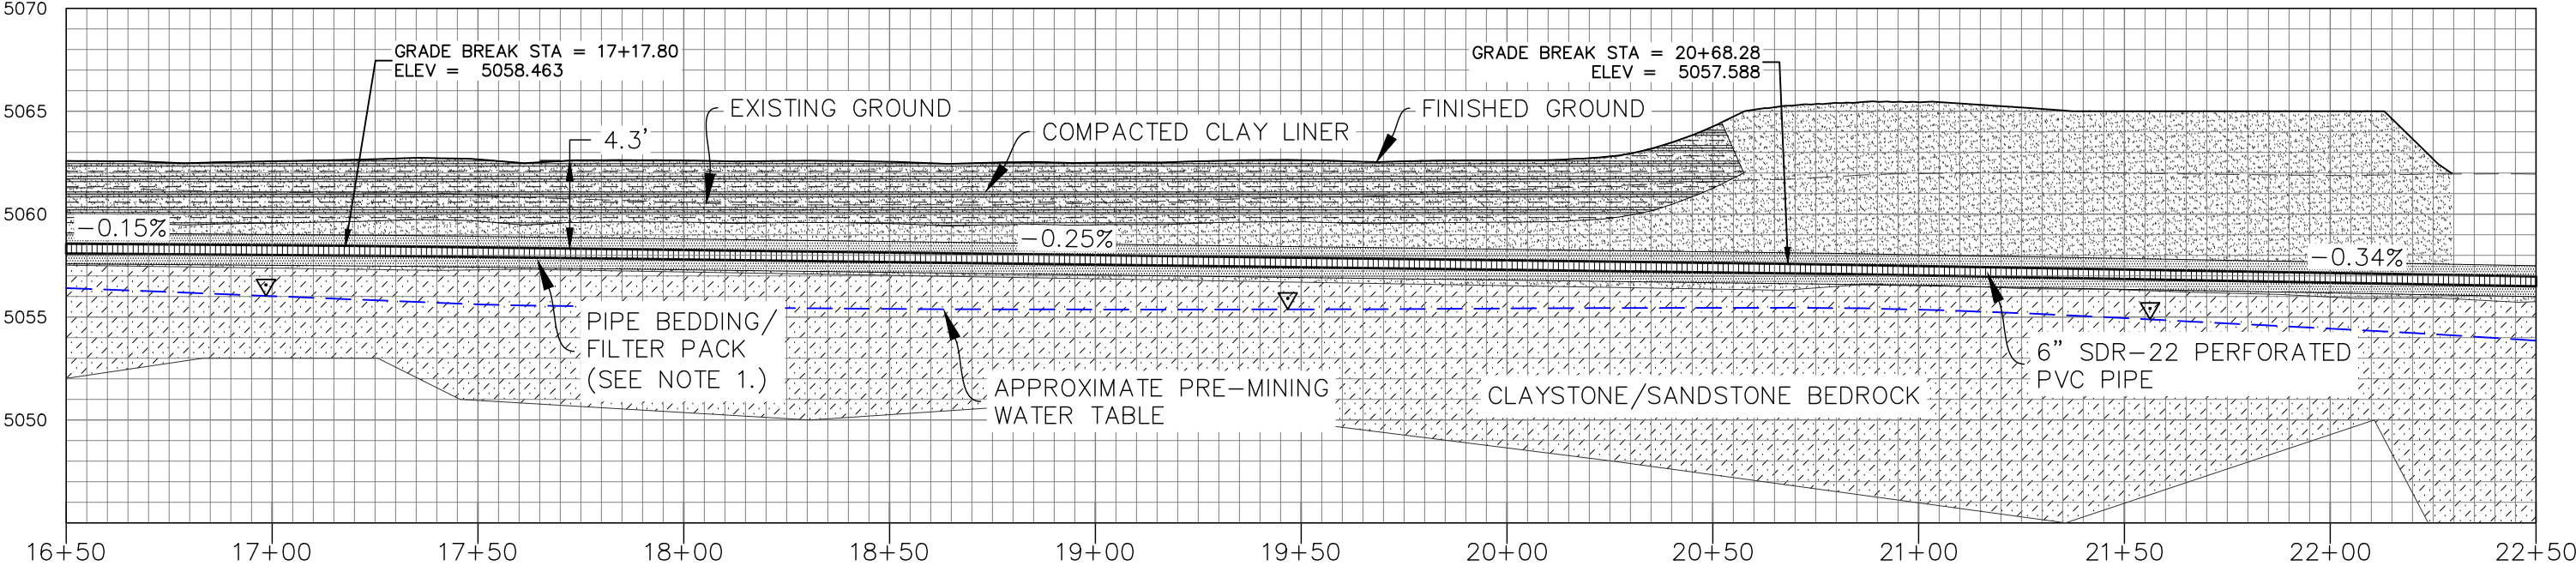

REVISIONS				OWNER	CONTRACTOR	PROJECT	SHEET		
REV	DESCRIPTION	DATE	APPROVED				C-5		
				CITY OF LAFAYETTE	ROCK PRODUCTS OF COLORADO L.L.C. P.O. BOX 893 BROOMFIELD, CO 80038	GOOSE HAVEN RESERVOIRS COMPLEX EXPANSION #2, #4 – EXHIBIT G UNDERDRAIN PLAN AND PROFILE	DRAWING NO. 5 OF 7		
							REVISION 0		
				CAD FILE NAME EXHIBIT G C2_C7.DWG	PLOT DATE 10/5/22	APPROVED	DATE October 5, 2022	W.I. JOB	SCALE V: 1"=8', H: 1"=40'
						DESIGNED PFW	CHECKED KR	DRAWN PFW	