

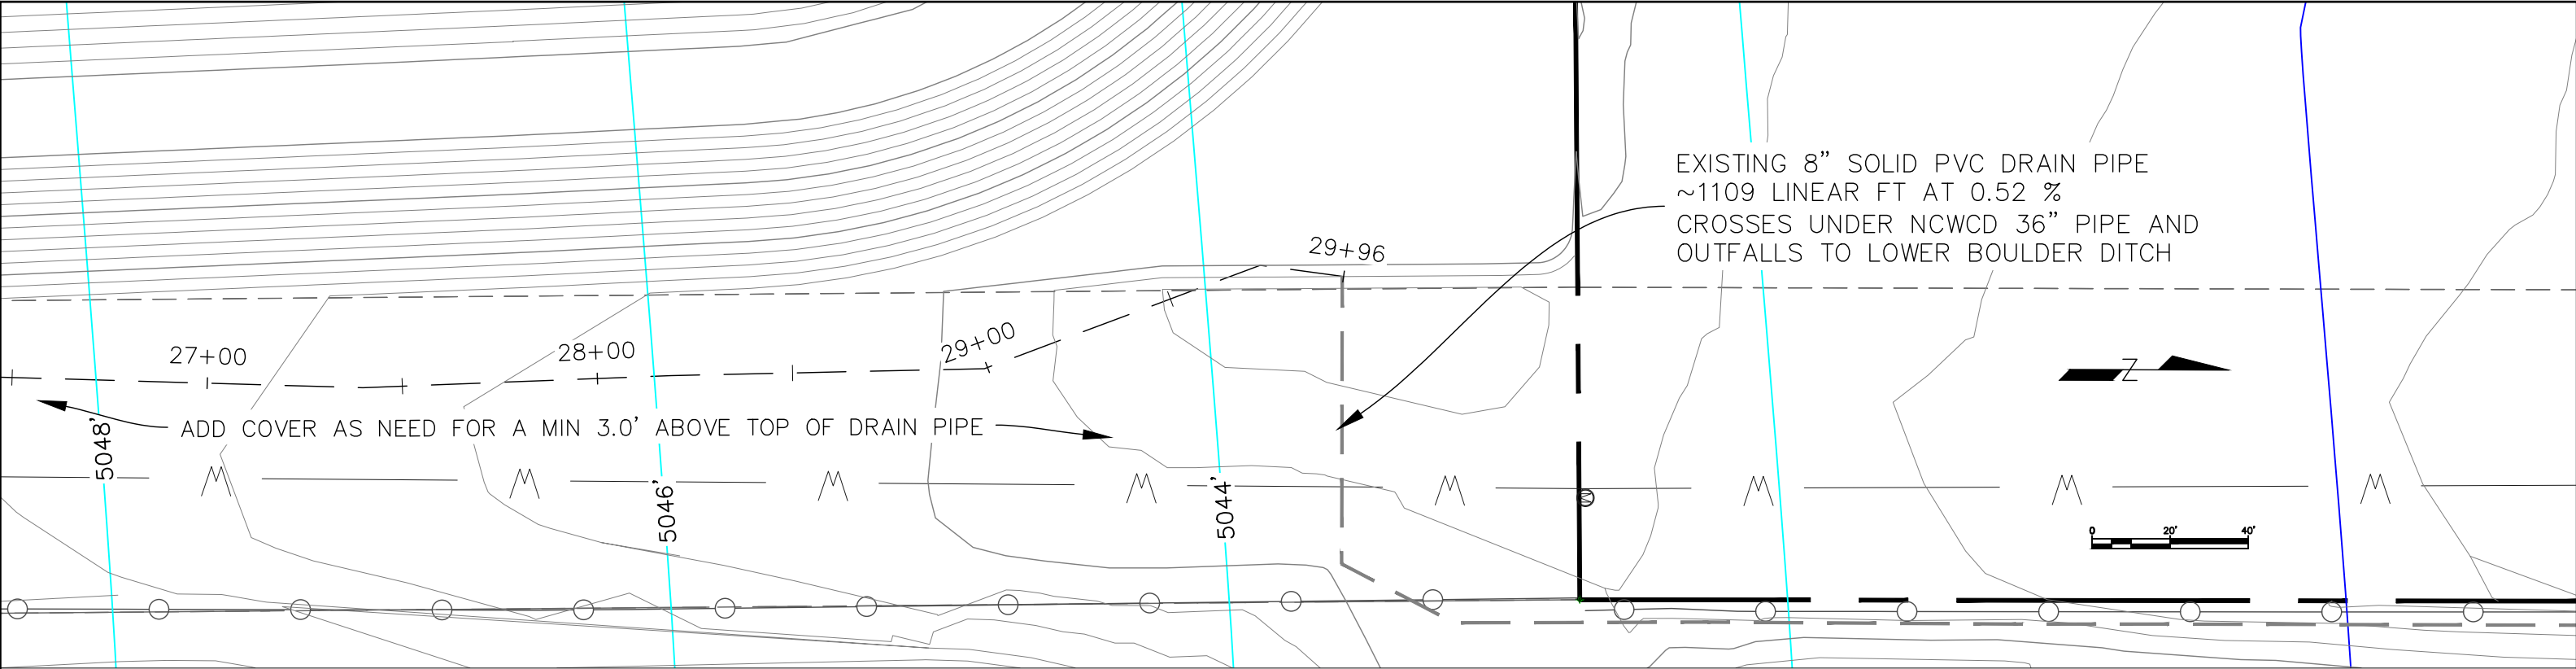


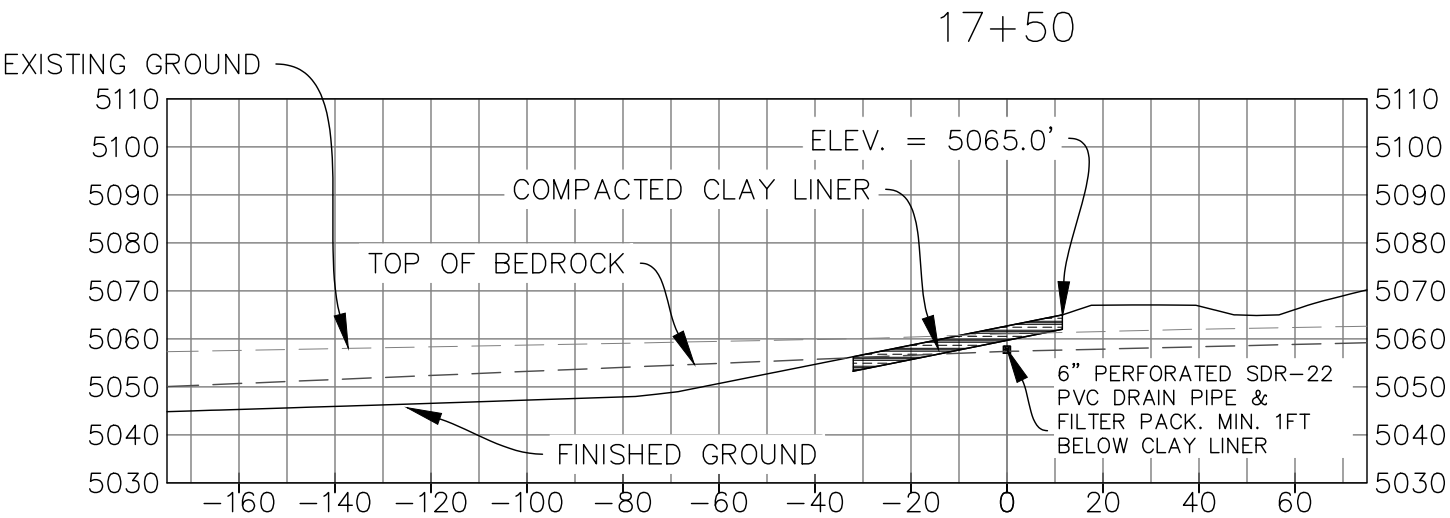

- NOTES:
1. PERFORATED PVC DRAIN PIPE FILTER PACK/BEDDING SHALL BE CONSTRUCTED WITH ASTM C33 No. 8 AGGREGATE WITH 6" MIN. THICKNESS ON ALL SIDES WRAPPED WITH MIRIFI FILTER FABRIC AROUND EXTERIOR OF THE ASTM C33 No. 8 AGGREGATE.
 2. SOLID PVC PIPE BEDDED SHALL CONSIST OF 6" MIN. THICKNESS ASTM C33 No. 8 AGGREGATE.

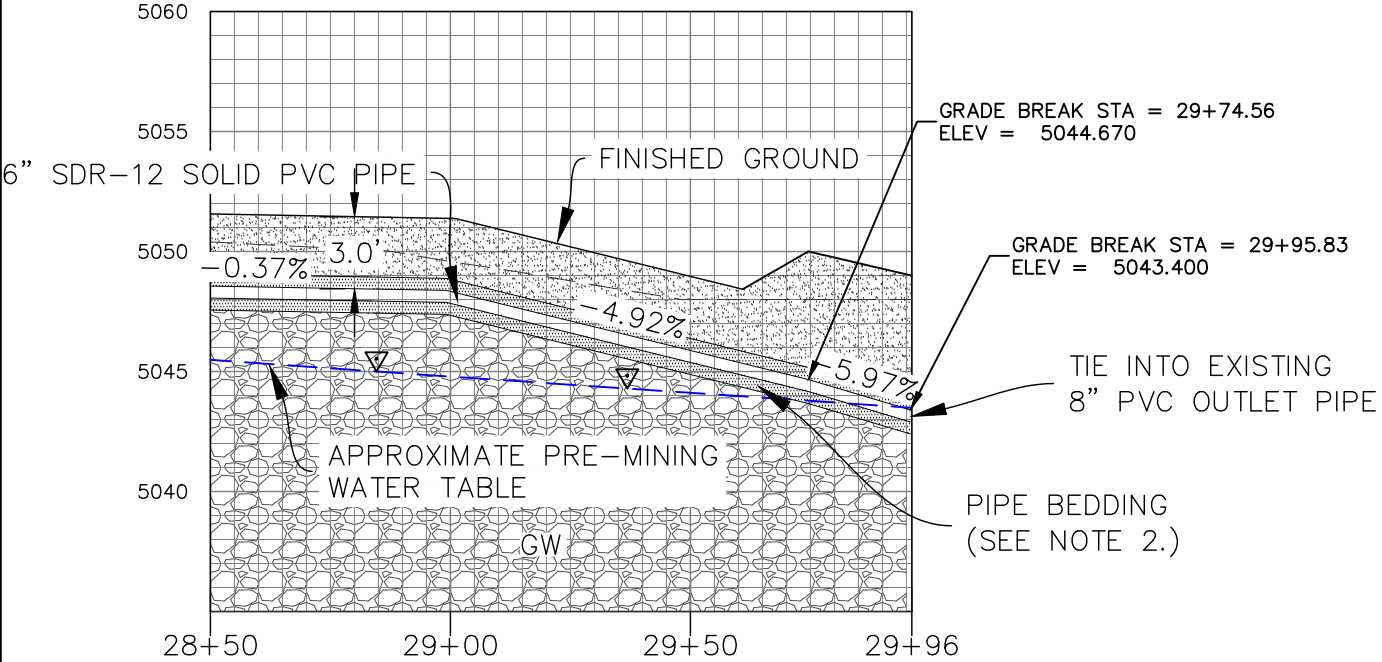

TYPICAL SOUTH UNDERDRAIN CROSS SECTION
WHERE DRAIN OCCURS UNDER CLAY LINER

REVISIONS				OWNER CITY OF LAFAYETTE	CONTRACTOR ROCK PRODUCTS OF COLORADO L.L.C. P.O. BOX 893 BROOMFIELD, CO 80038	 Weiland Inc. Environmental & Engineering PO BOX 18007 Boulder, CO 80508 ph 303-443-9521				PROJECT GOOSE HAVEN RESERVOIRS COMPLEX EXPANSION #2, #4 – EXHIBIT G UNDERDRAIN PLAN AND PROFILE			SHEET C-7	
REV	DESCRIPTION	DATE	APPROVED										DRAWING NO. 7 OF 7	
													REVISION 0	
CAD FILE NAME EXHIBIT G C2_C7.DWG		PLOT DATE 10/5/22		APPROVED	DATE	DESIGNED PFW	CHECKED KR	DRAWN PFW	CONTRACT	DATE October 5, 2022	W.I. JOB	SCALE V: 1"=8', H: 1"=40'		